


LEGEND:

- STORM SEWER
- STORM SEWER INLET
- STORM SEWER CATCH BASIN
- STORM SEWER MANHOLE
- SANITARY SEWER
- SANITARY SEWER MAN HOLE
- WATERMAIN
- VALVE VAULT

GRAPHIC SCALE
H. 1" = 20ft. V. 1" = 5ft.

STORM STRUCTURES		
STRUCTURE #	TYPE	FRAME & GRATE
SS A33-1	MH TYPE A, 6' DIA.	TYPE 1 FR & CL
SS A33-2	INLET TYPE A	TYPE 8 GRATE
SS A35	MH TYPE A, 6' DIA.	TYPE 1 FR & CL
SS A36	INLET TYPE A	TYPE 8 GRATE
SS A37	MH TYPE A, 6' DIA.	TYPE 1 FR & CL
SS A37-1	MH TYPE A, 6' DIA.	TYPE 1 FR & CL
SS A38	CB TYPE A, 4' DIA.	TYPE 23 FR & GR
SS A38-1	CB TYPE C	TYPE 23 FR & GR
SS A38-2	CB TYPE C	TYPE 8 GRATE
SS A38-2A	INLET TYPE A	TYPE 8 GRATE
SS A38-3	12" DIA PES	
SS D1	MH TYPE A, 6' DIA.	TYPE 23 FR & GR, TYPE 1 FR & CL
SS D2	CB TYPE A, 4' DIA.	TYPE 23 FR & GR
SS D2-1	INLET TYPE A	TYPE 23 FR & GR
SS E1	MH TYPE A, 6' DIA.	TYPE 23 FR & GR, TYPE 1 FR & CL
SS E2	INLET TYPE A	TYPE 23 FR & GR
SS F6	MH TYPE A, 7' DIA.	TYPE 1 FR & CL
SS F7	CB TYPE A, 4' DIA.	TYPE 23 FR & GR
SS F7-1	INLET TYPE A	TYPE 23 FR & GR
SS F7-2	INLET TYPE A	TYPE 8 GRATE

* MANHOLE WITH RESTRICTOR PLATE SEE DETAIL

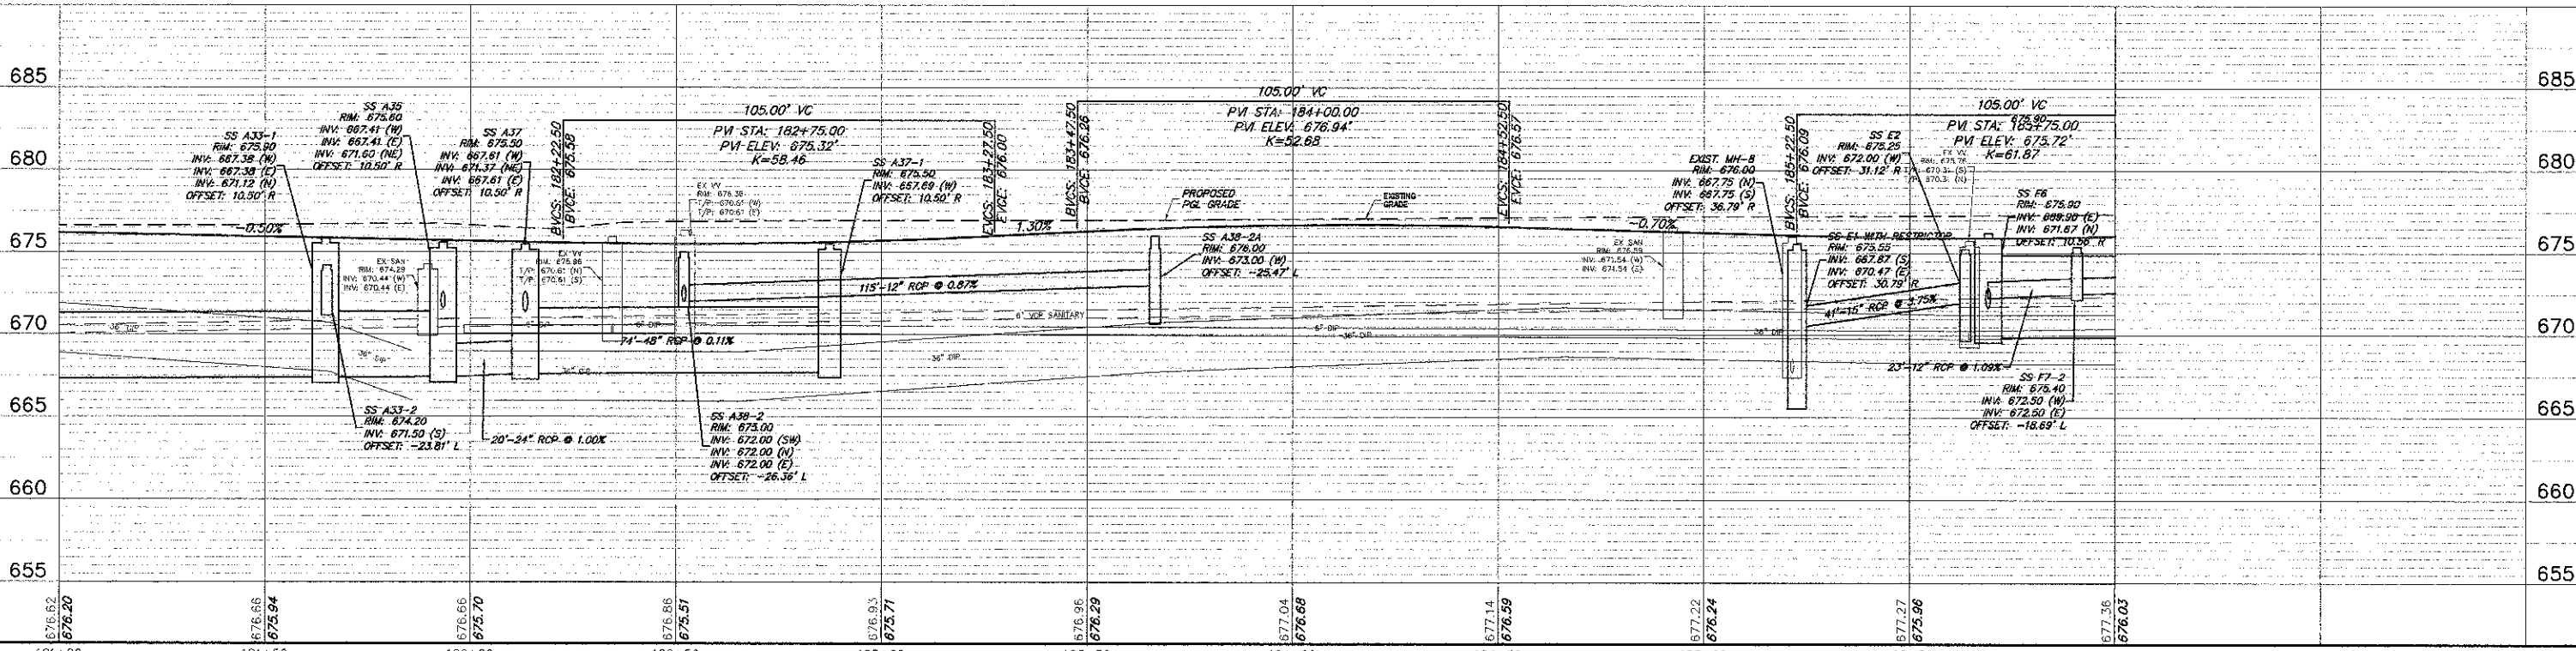

FILE NAME = 4165.800-PR3.dwg	USER NAME = PAUL SWIATEK	DESIGNED - BVS	REVISED -	STATE OF ILLINOIS DEPARTMENT OF TRANSPORTATION	DRAINAGE AND UTILITY - PLAN AND PROFILE KENSINGTON ROAD IMPROVEMENTS	FAU RATE	SECTION	COUNTY	TOTAL SHEETS	SHEET NO.
PLOT SCALE = 1" = 48'	CHECKED - KLB	REVISED -	1295			09-00154-00-PV	COOK	119	48	
PLOT DATE = 10/17/2012	DATE - 10/17/12	REVISED -	CONTRACT #:			63746		ILLINOIS FED. AID PROJECT		
SCALE: 1"=20'		SHEET NO. OF SHEETS				STA. 181+00 TO STA. 186+00				