


MATCH LINE STA 96+00 (SEE BELOW)

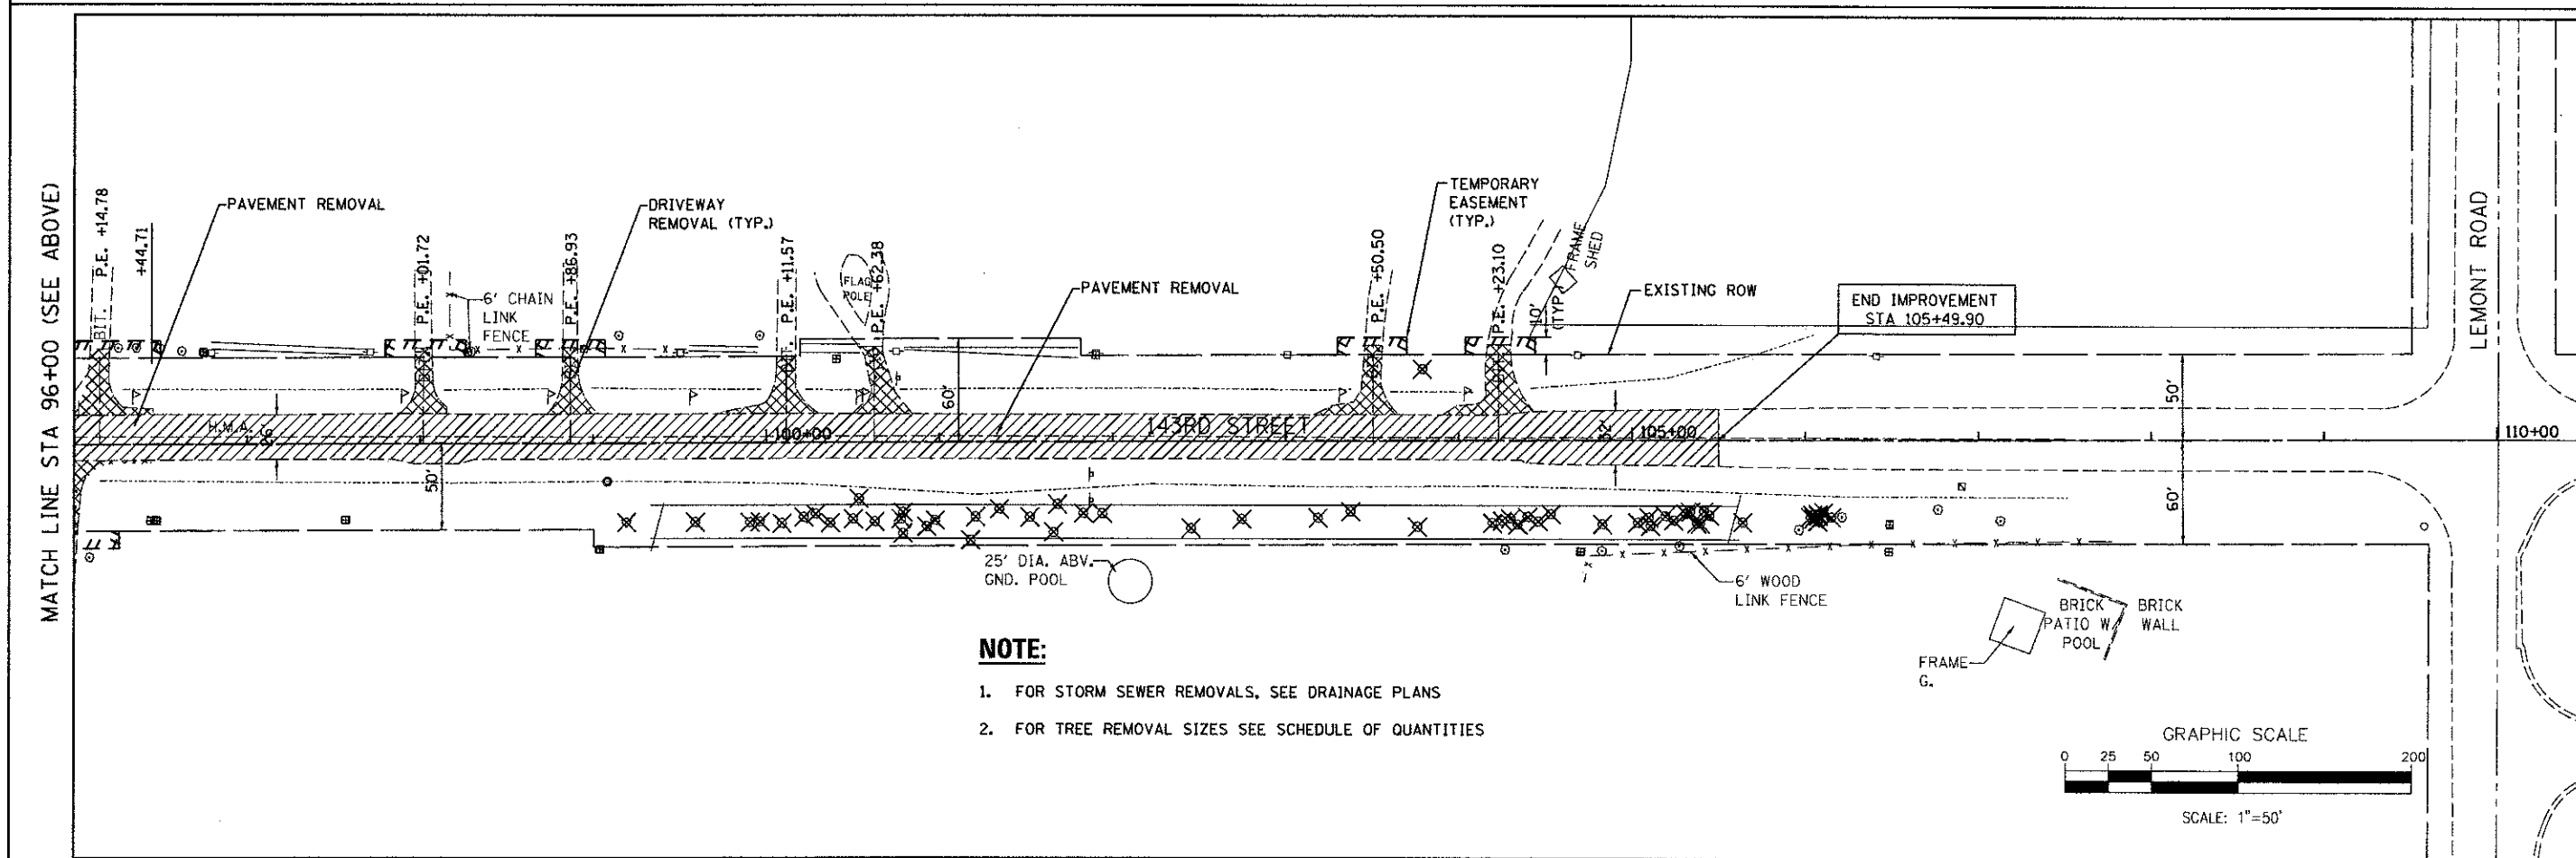

NOTE:

1. FOR STORM SEWER REMOVALS, SEE DRAINAGE PLANS
2. FOR TREE REMOVAL SIZES SEE SCHEDULE OF QUANTITIES

FILE NAME = ...\\w11\Co-9185609-sh1021-demo.dgn	DESIGNED - MC	REVISED -	 800 W. PULFON ST. CHICAGO, ILLINOIS 60611-1288 TEL: 312.456.6100 FAX: 312.686.1217 WEB: www.sepstein.com	STATE OF ILLINOIS DEPARTMENT OF TRANSPORTATION		REMOVAL PLAN		F.A.U. RTE. 1600	SECTION 06-00169-14-FP	COUNTY WILL	TOTAL SHEETS 55	SHEET NO. 21	
PLOT TIME = 5/4/14 6 PM	DRAWN - AP	REVISED -		SCALE: 1" = 50'		SHEET NO. 1 OF 1 SHEETS		STA. 82+00.00 TO STA. 110+00.00		CONTRACT NO. 63752			
PLOT DATE = 9/25/2012	CHECKED - GAO	REVISED -		ILLINOIS FED. AID PROJECT									
DATE = 9/28/2012	DATE = 9/28/2012	REVISED -											