
 




DATE	
BY	
REVISION	
PLAN	
NOTE BOOK	
NO.	
FILE NAME	

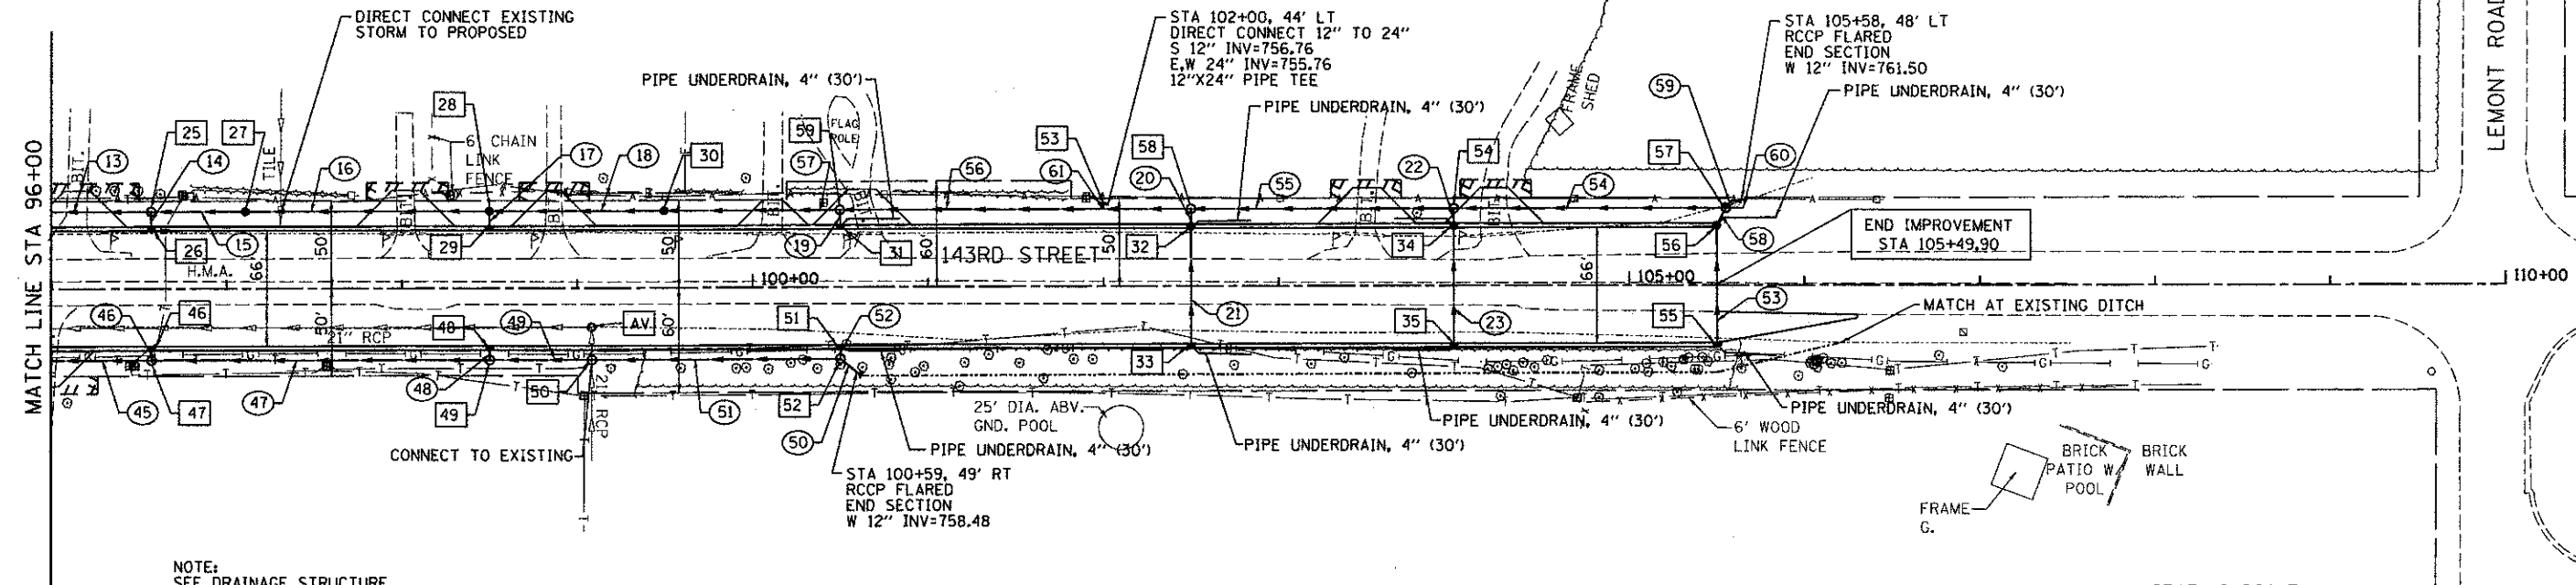

NOTE:
SEE DRAINAGE STRUCTURE
SCHEDULE FOR REMOVAL OF
EXISTING PIPE AND STRUCTURES.



DATE	
BY	
REVISION	
PROFILE	
NOTE BOOK	
NO.	
FILE NAME	

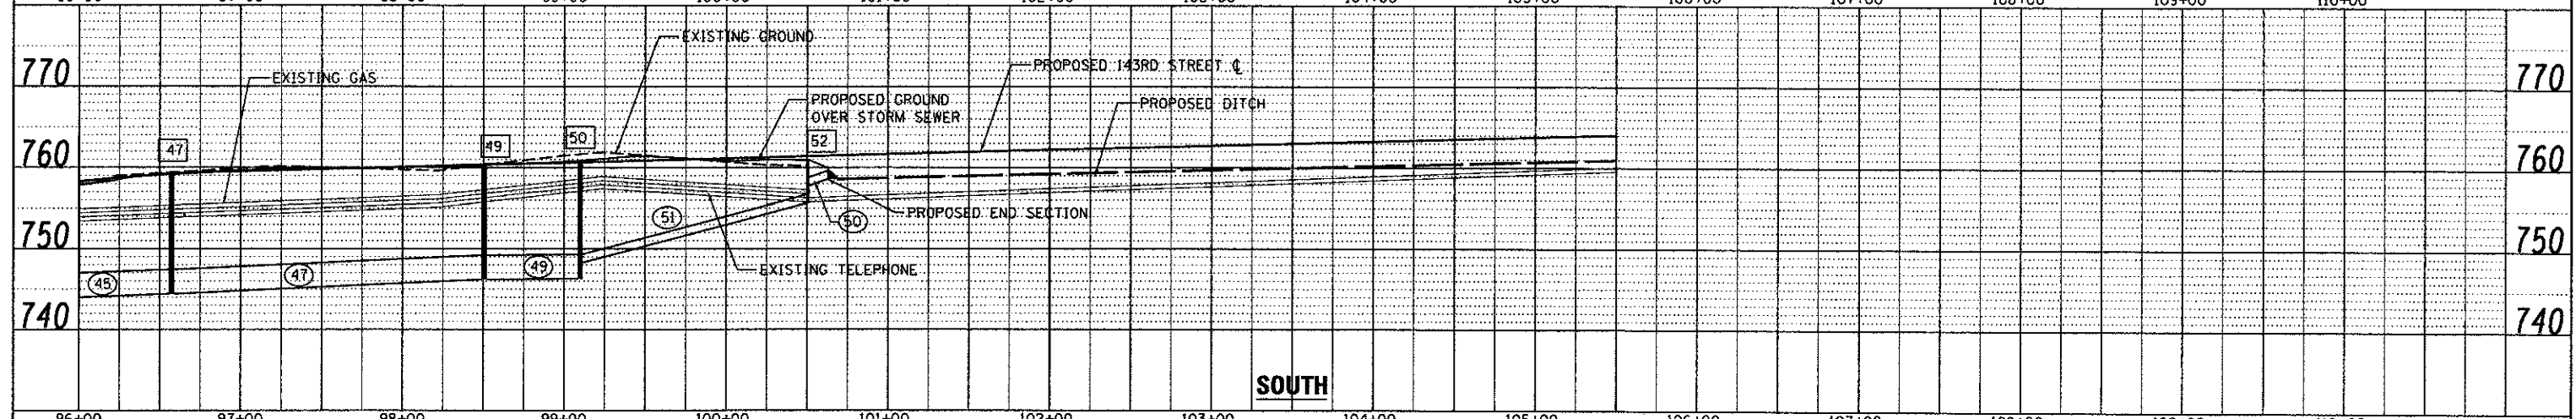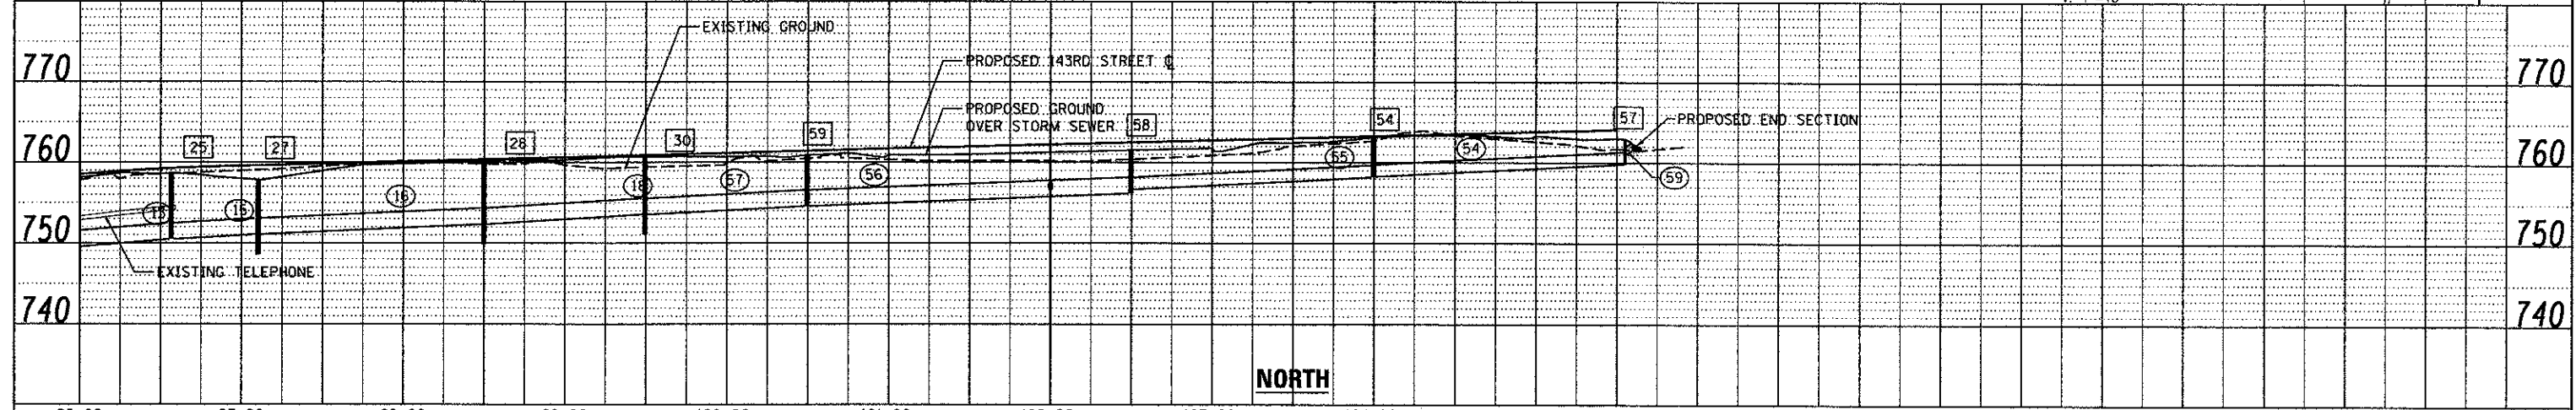

FILE NAME =	DESIGNED - CG	REVISED -		STATE OF ILLINOIS DEPARTMENT OF TRANSPORTATION	DRAINAGE AND UTILITY PLAN AND PROFILE	F.A.U. RTE.	SECTION	COUNTY	TOTAL SHEETS	SHEET NO.
...\\w.11co-9185809-sh1825-draun2.dgn	DRAWN - AP	REVISED -				1600	06-00169-14-FP	WILL	55	25
PLOT TIME = 5:49:58 PM	CHECKED - GAO	REVISED -				CONTRACT NO. 63752				
PLOT DATE = 9/25/2012	DATE - 09/28/2012	REVISED -				ILLINOIS FED. AID PROJECT				