
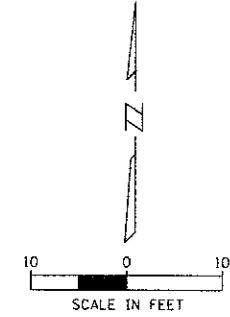


MATCH LINE STA. 59+00

MATCH LINE STA. 61+50

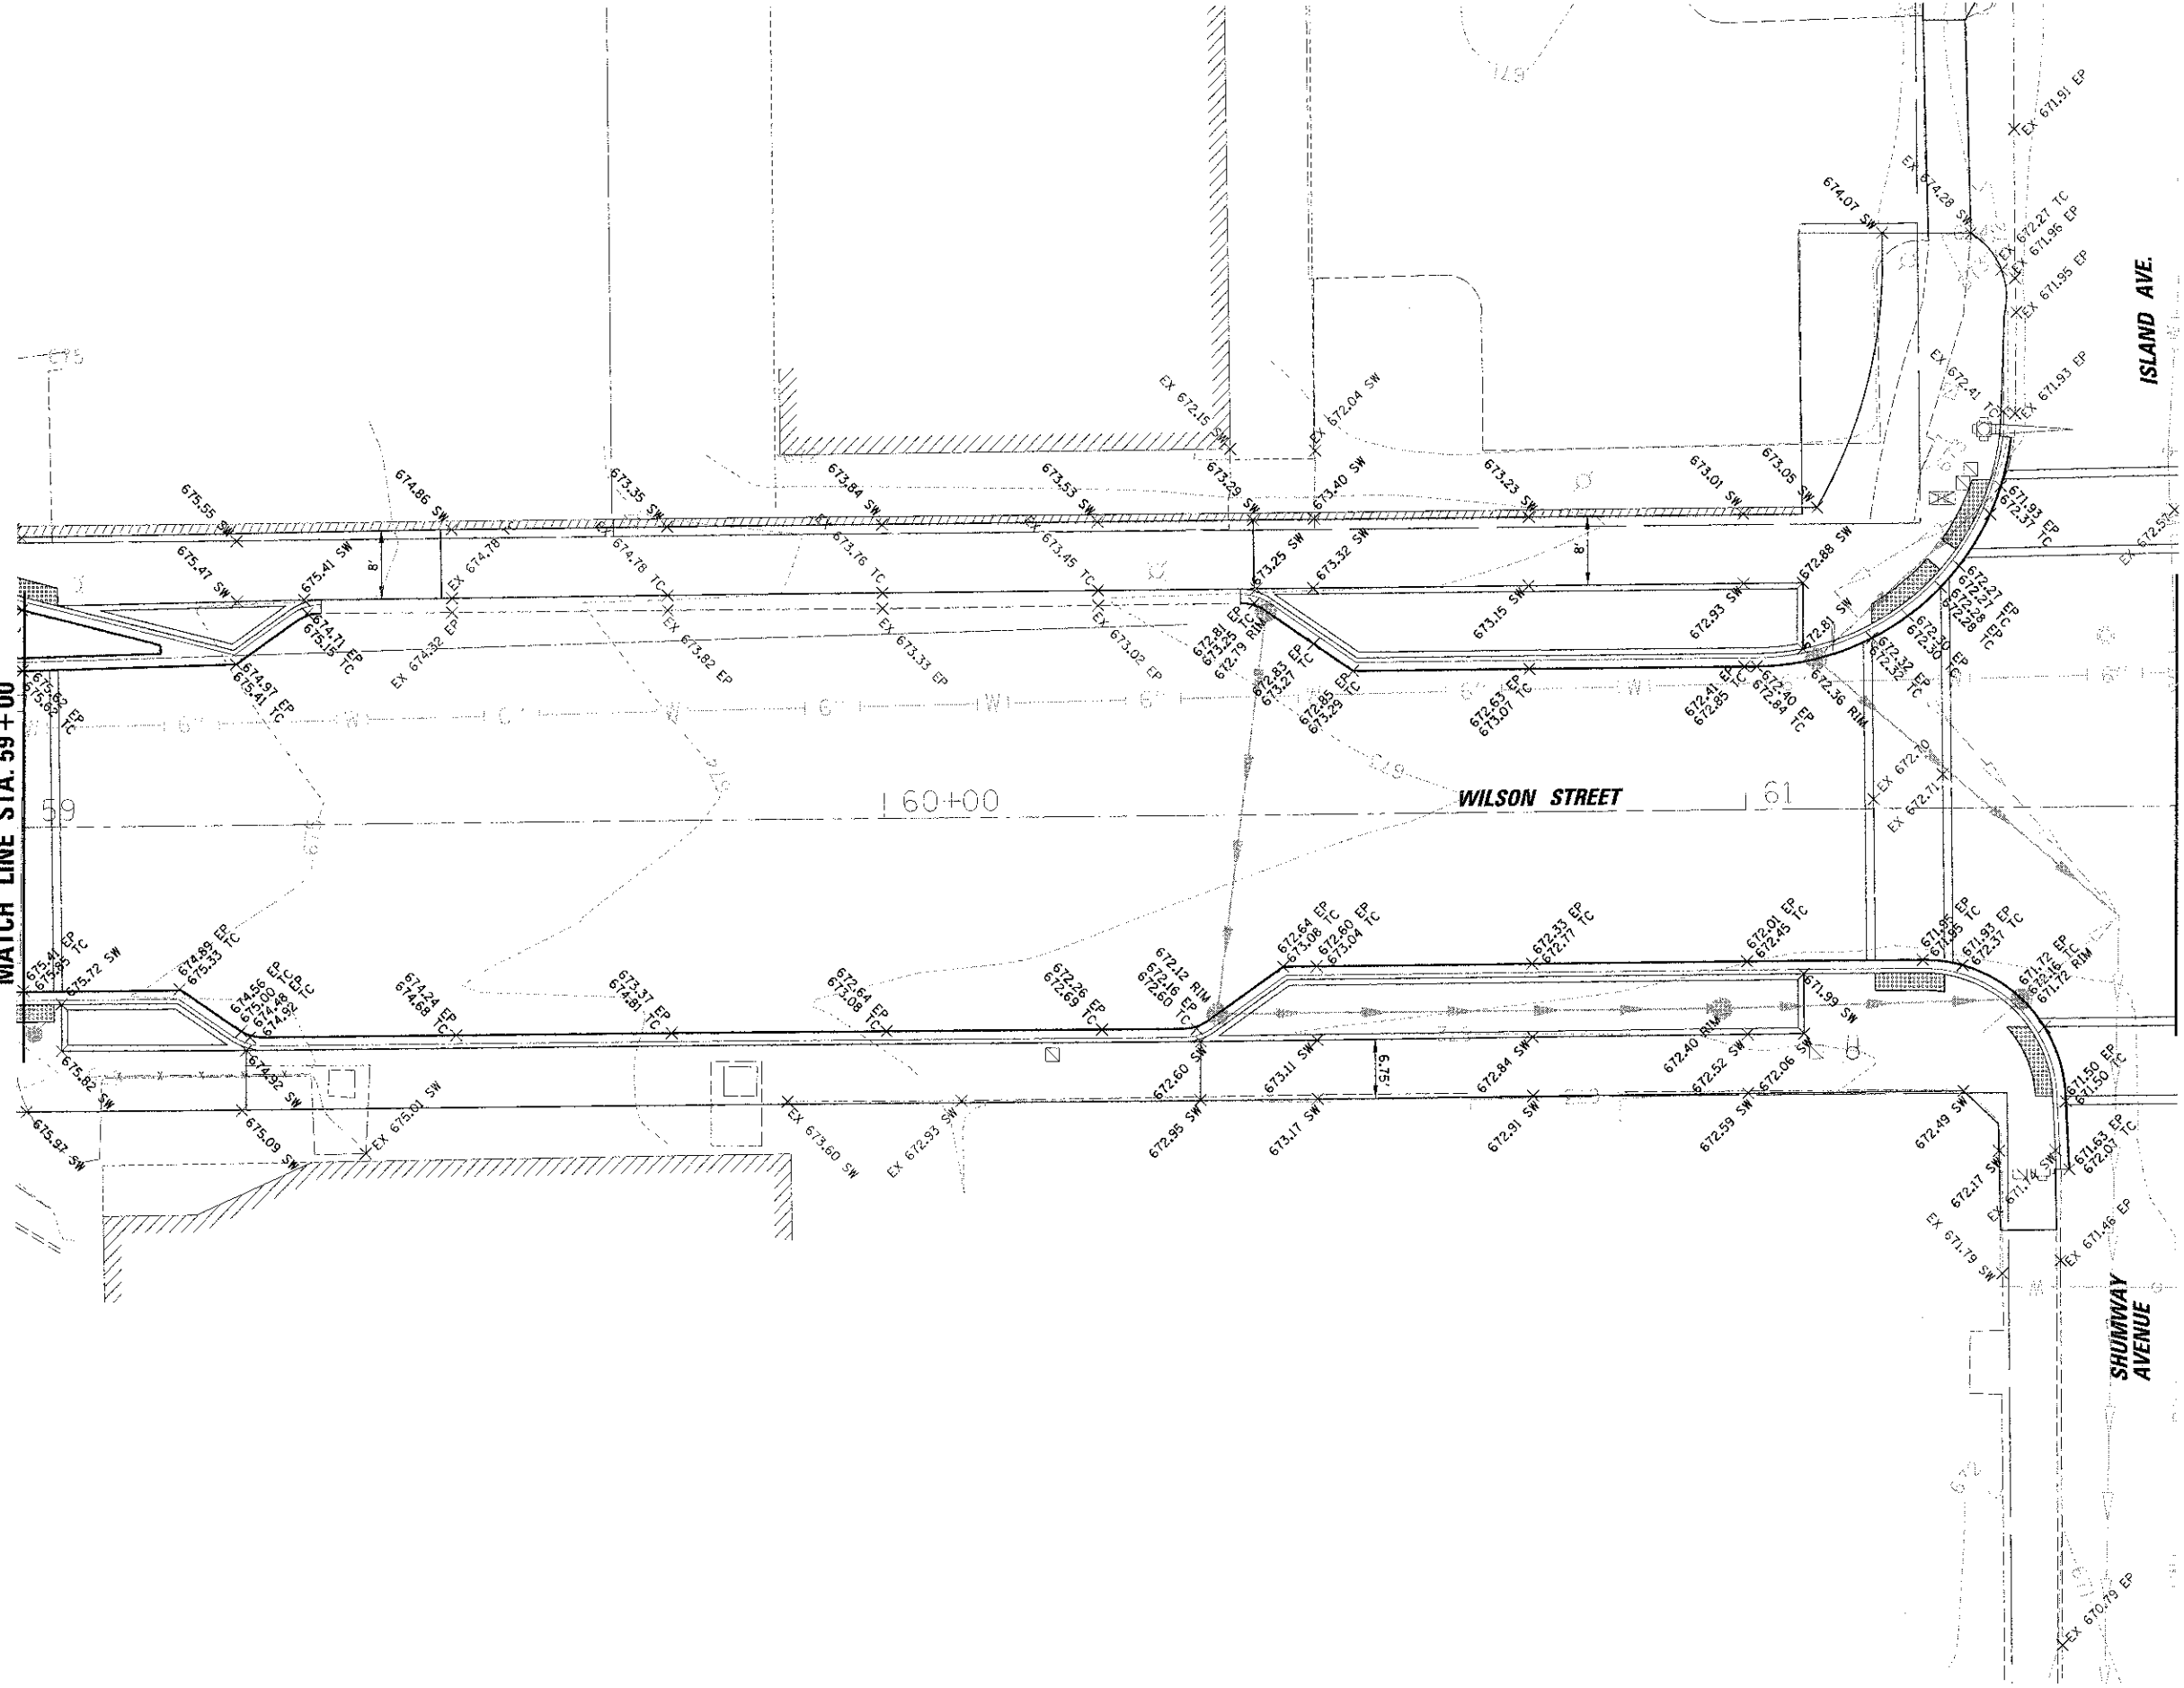

CHRISTOPHER B. BURKE
 ENGINEERING, LTD.
 9575 W. Higgins Road, Suite 600
 Rosemont, Illinois 60018
 (847) 823-0500

USER NAME = cberrell	DESIGNED <i>CJM</i>	REVISED -
DRAWN <i>MAX</i>	CHECKED <i>LMF</i>	REVISED -
DATE		REVISED -

PLANT SCALE = 1/8"	DATE
PLOT DATE = 10/23/2012	

**STATE OF ILLINOIS
 DEPARTMENT OF TRANSPORTATION**

**GRADING PLAN
 WILSON STREET**

SCALE: 1"=10' SHEET 16 OF 88 SHEETS STA. 59+00 TO STA. 61+50

F.A.U. RTE. 1441	SECTION 12-00073-01-TL	COUNTY KANE	TOTAL SHEETS 88	SHEET NO. 16
CONTRACT NO. 63763			ILLINOIS FED. AID PROJECT	