



F.A.P. RTE.	SECTION	COUNTY	TOTAL SHEETS	SHEET NO.
311	(1-1)R	KENDALL	514	404
STA. 780+44.91		TO STA. 918+85.88		
FED. ROAD DIST. NO. 5 ILLINOIS FED. AID PROJECT				

CONSTRUCTION NOTES:

THE LOCATION OF EXISTING UNDERGROUND UTILITIES SHOWN ON THIS PLAN IS APPROXIMATE AND MUST BE FIELD VERIFIED PRIOR TO EXCAVATION OR INSTALLATION. SEE CONTRACT #66420 DRAINAGE PLANS AND THE CITY OF OSWEGO WATER DEPARTMENT FOR WATER MAIN INFORMATION.

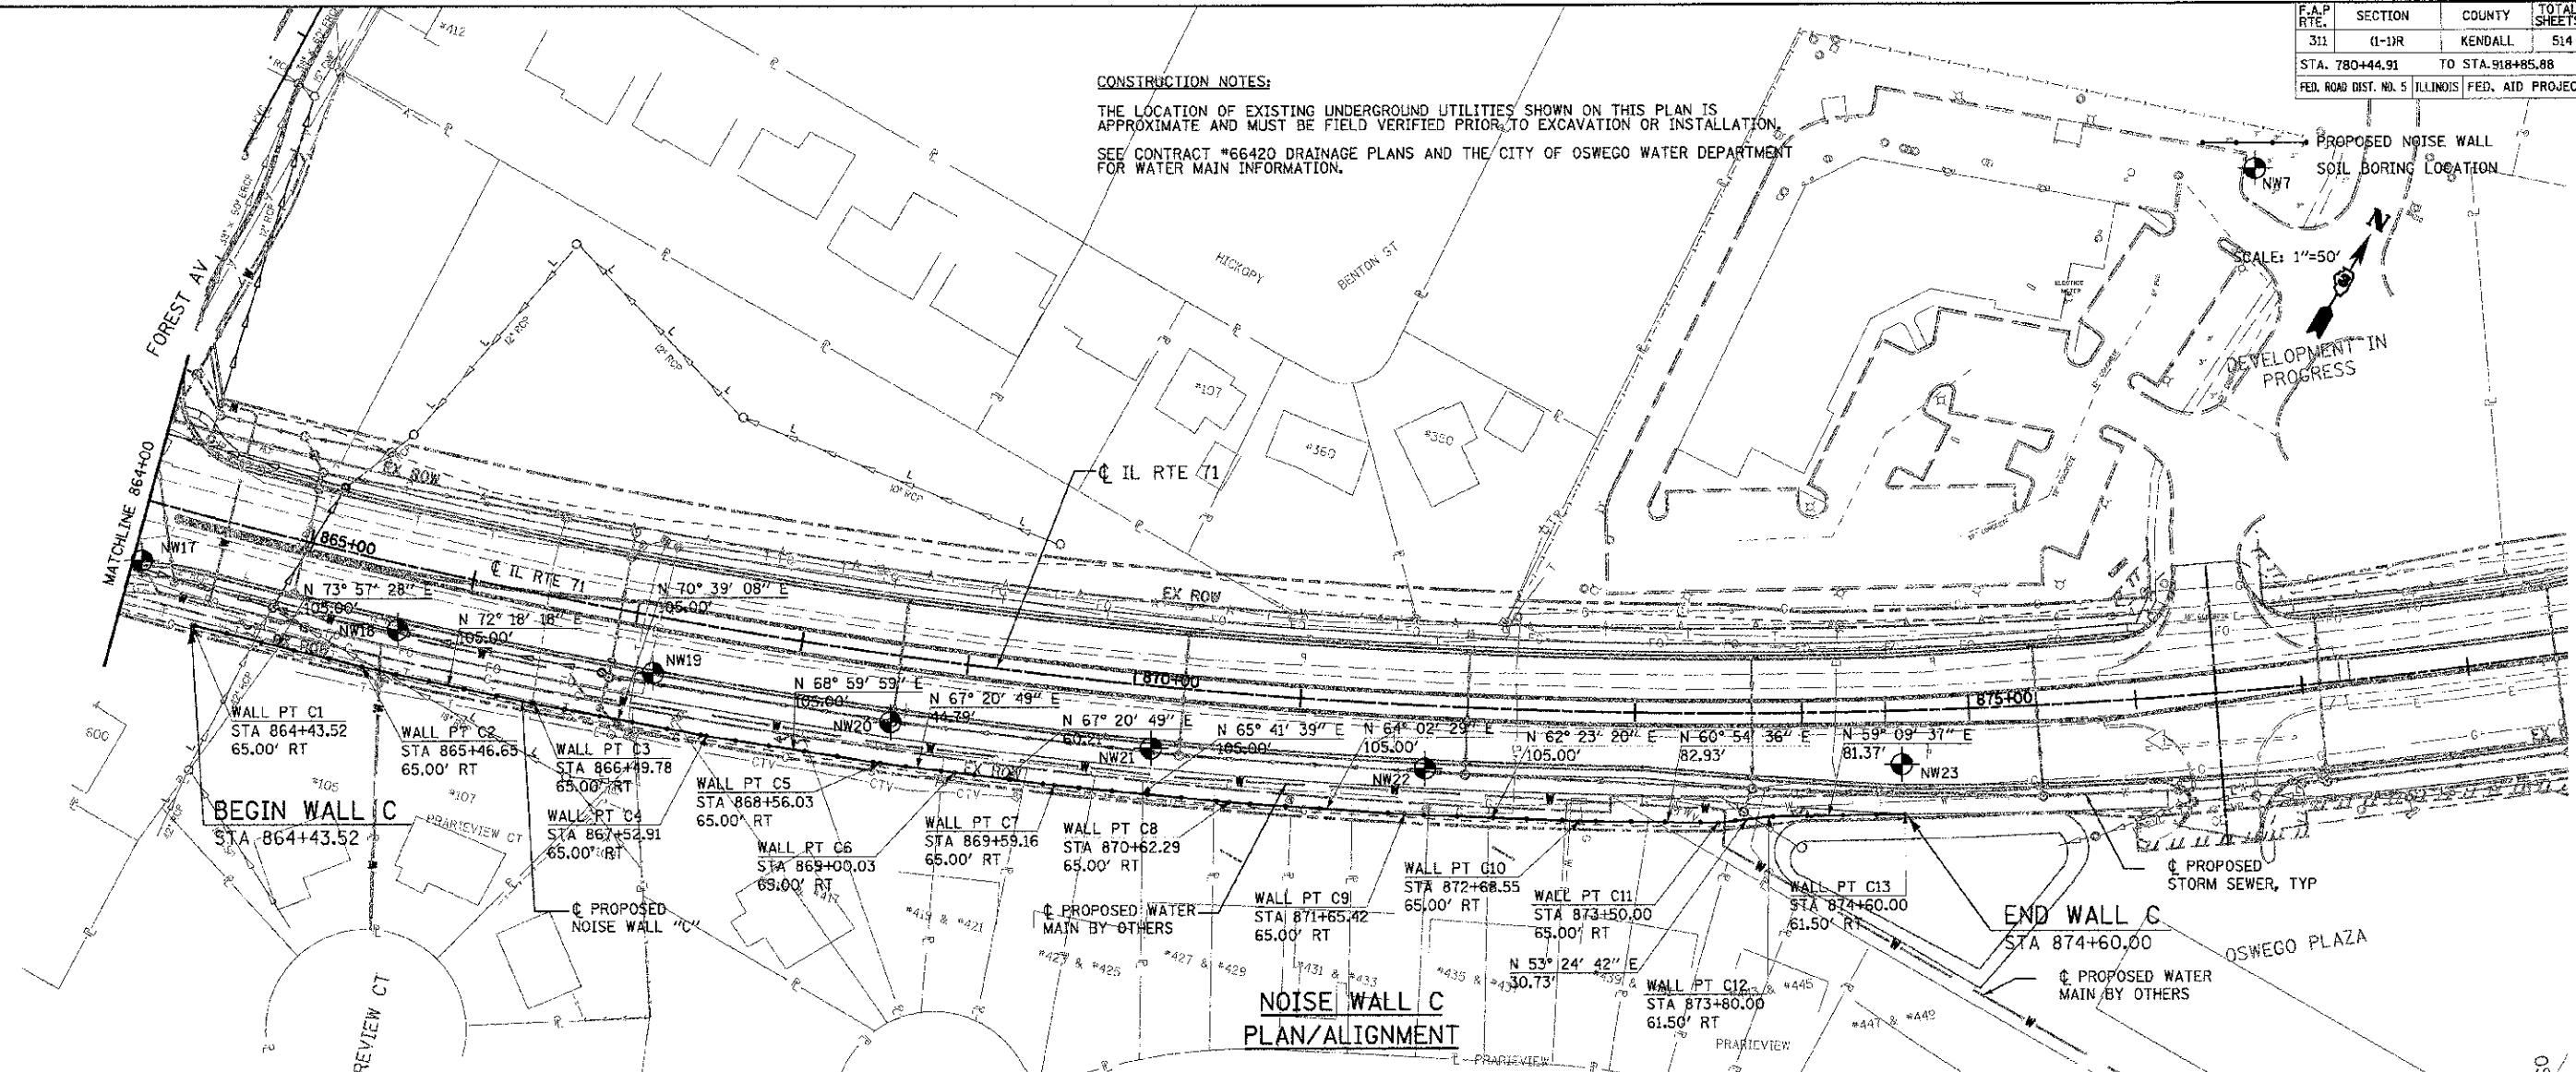

NOISE WALL C PLAN/ALIGNMENT

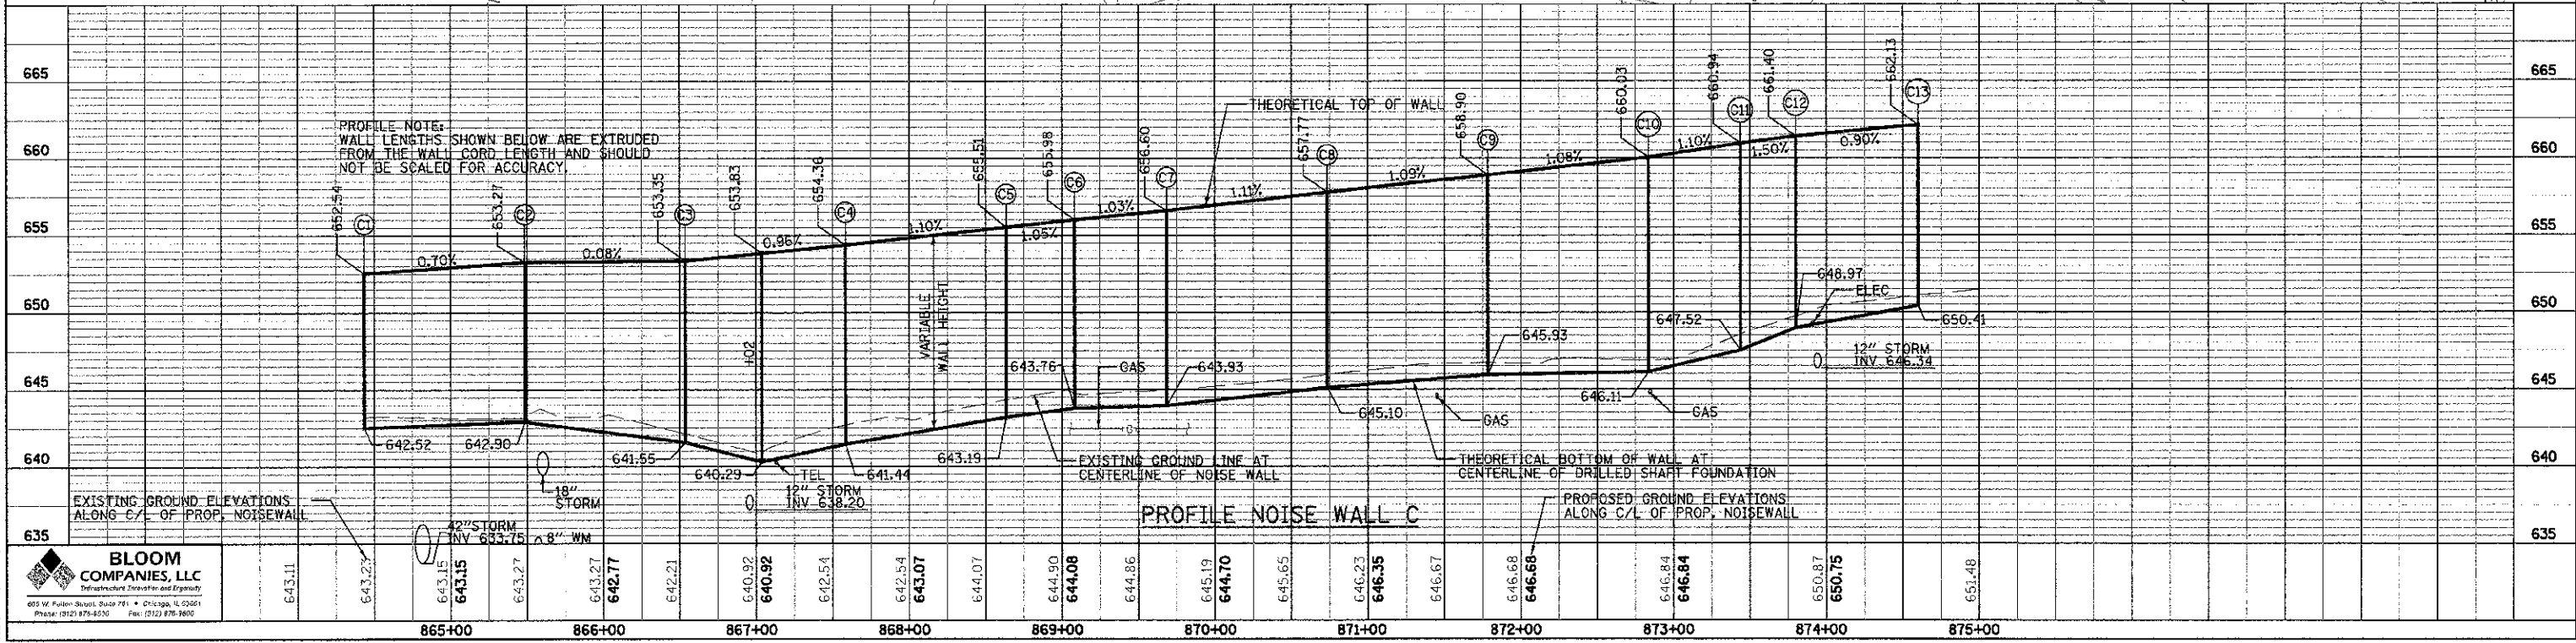

PROFILE NOISE WALL C

PROFILE NOTE:  
WALL LENGTHS SHOWN BELOW ARE EXTRUDED FROM THE WALL CORD LENGTH AND SHOULD NOT BE SCALED FOR ACCURACY.

DATE	BY	REVISION

DATE	BY	REVISION

DATE: 7/29/2012  
 FILE NAME: F:\BIDDING\11 71 DEVELOP\AL CAD\DWG\NOISEWALL.CAD.dgn  
 PLOT SCALE: 1"=50'  
 USER NAME: koby

**BLOOM COMPANIES, LLC**  
 Infrastructure Division and Engineering  
 605 W. Fulton Street, Suite 701 • Chicago, IL 60601  
 Phone: (312) 876-6510 Fax: (312) 876-9800