

 
 


 


| | | | | |
|---------------------|---------|-----------|------------------|-----------|
| F.A.P. RTE. | SECTION | COUNTY | TOTAL SHEETS | SHEET NO. |
| 322 | 11-13 | CHRISTIAN | 437 | 176 |
| STA. | | TO STA. | | |
| FED. ROAD DIST. NO. | | ILLINOIS | FED. AID PROJECT | |

LEGEND

-  LIGHTING CONTROLLER, POLE MOUNTED, 240 VOLT, 30 AMP
-  LIGHT POLE ALUMINUM, 45' MOUNTING HEIGHT 15' DAVIT ARM WITH 250 WATT HPS HORIZONTAL MOUNT LUMINAIRE
-  UNIT DUCT 600V, 2-1C NO. 10, 1C NO. 10 GROUND, (XLP-TYPE USE), 3/4" DIA POLYETHYLENE, UNLESS NOTED OTHERWISE
-  UNDERGROUND CONDUIT, PVC, 2" DIA, UNLESS NOTED OTHERWISE

SEE SHEET 168 FOR ELECTRICAL GENERAL NOTES

SCH. 80

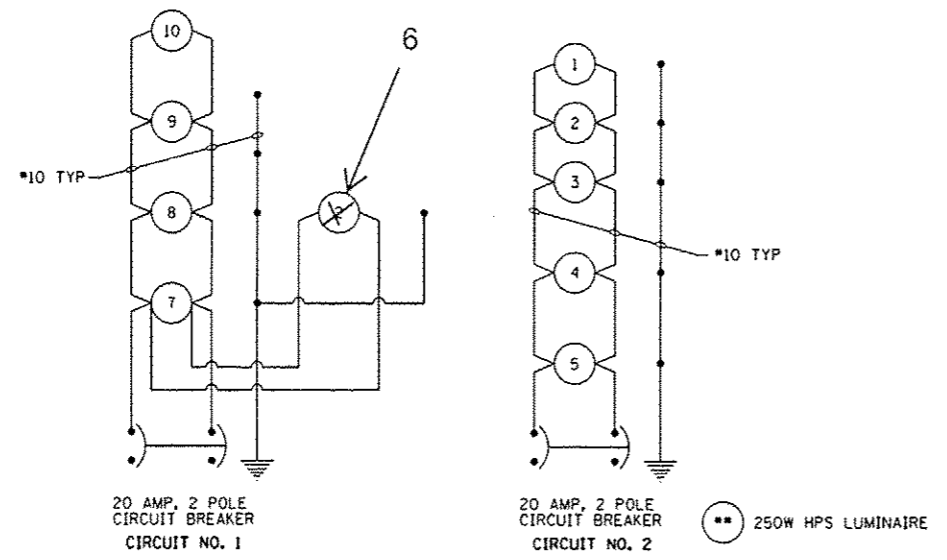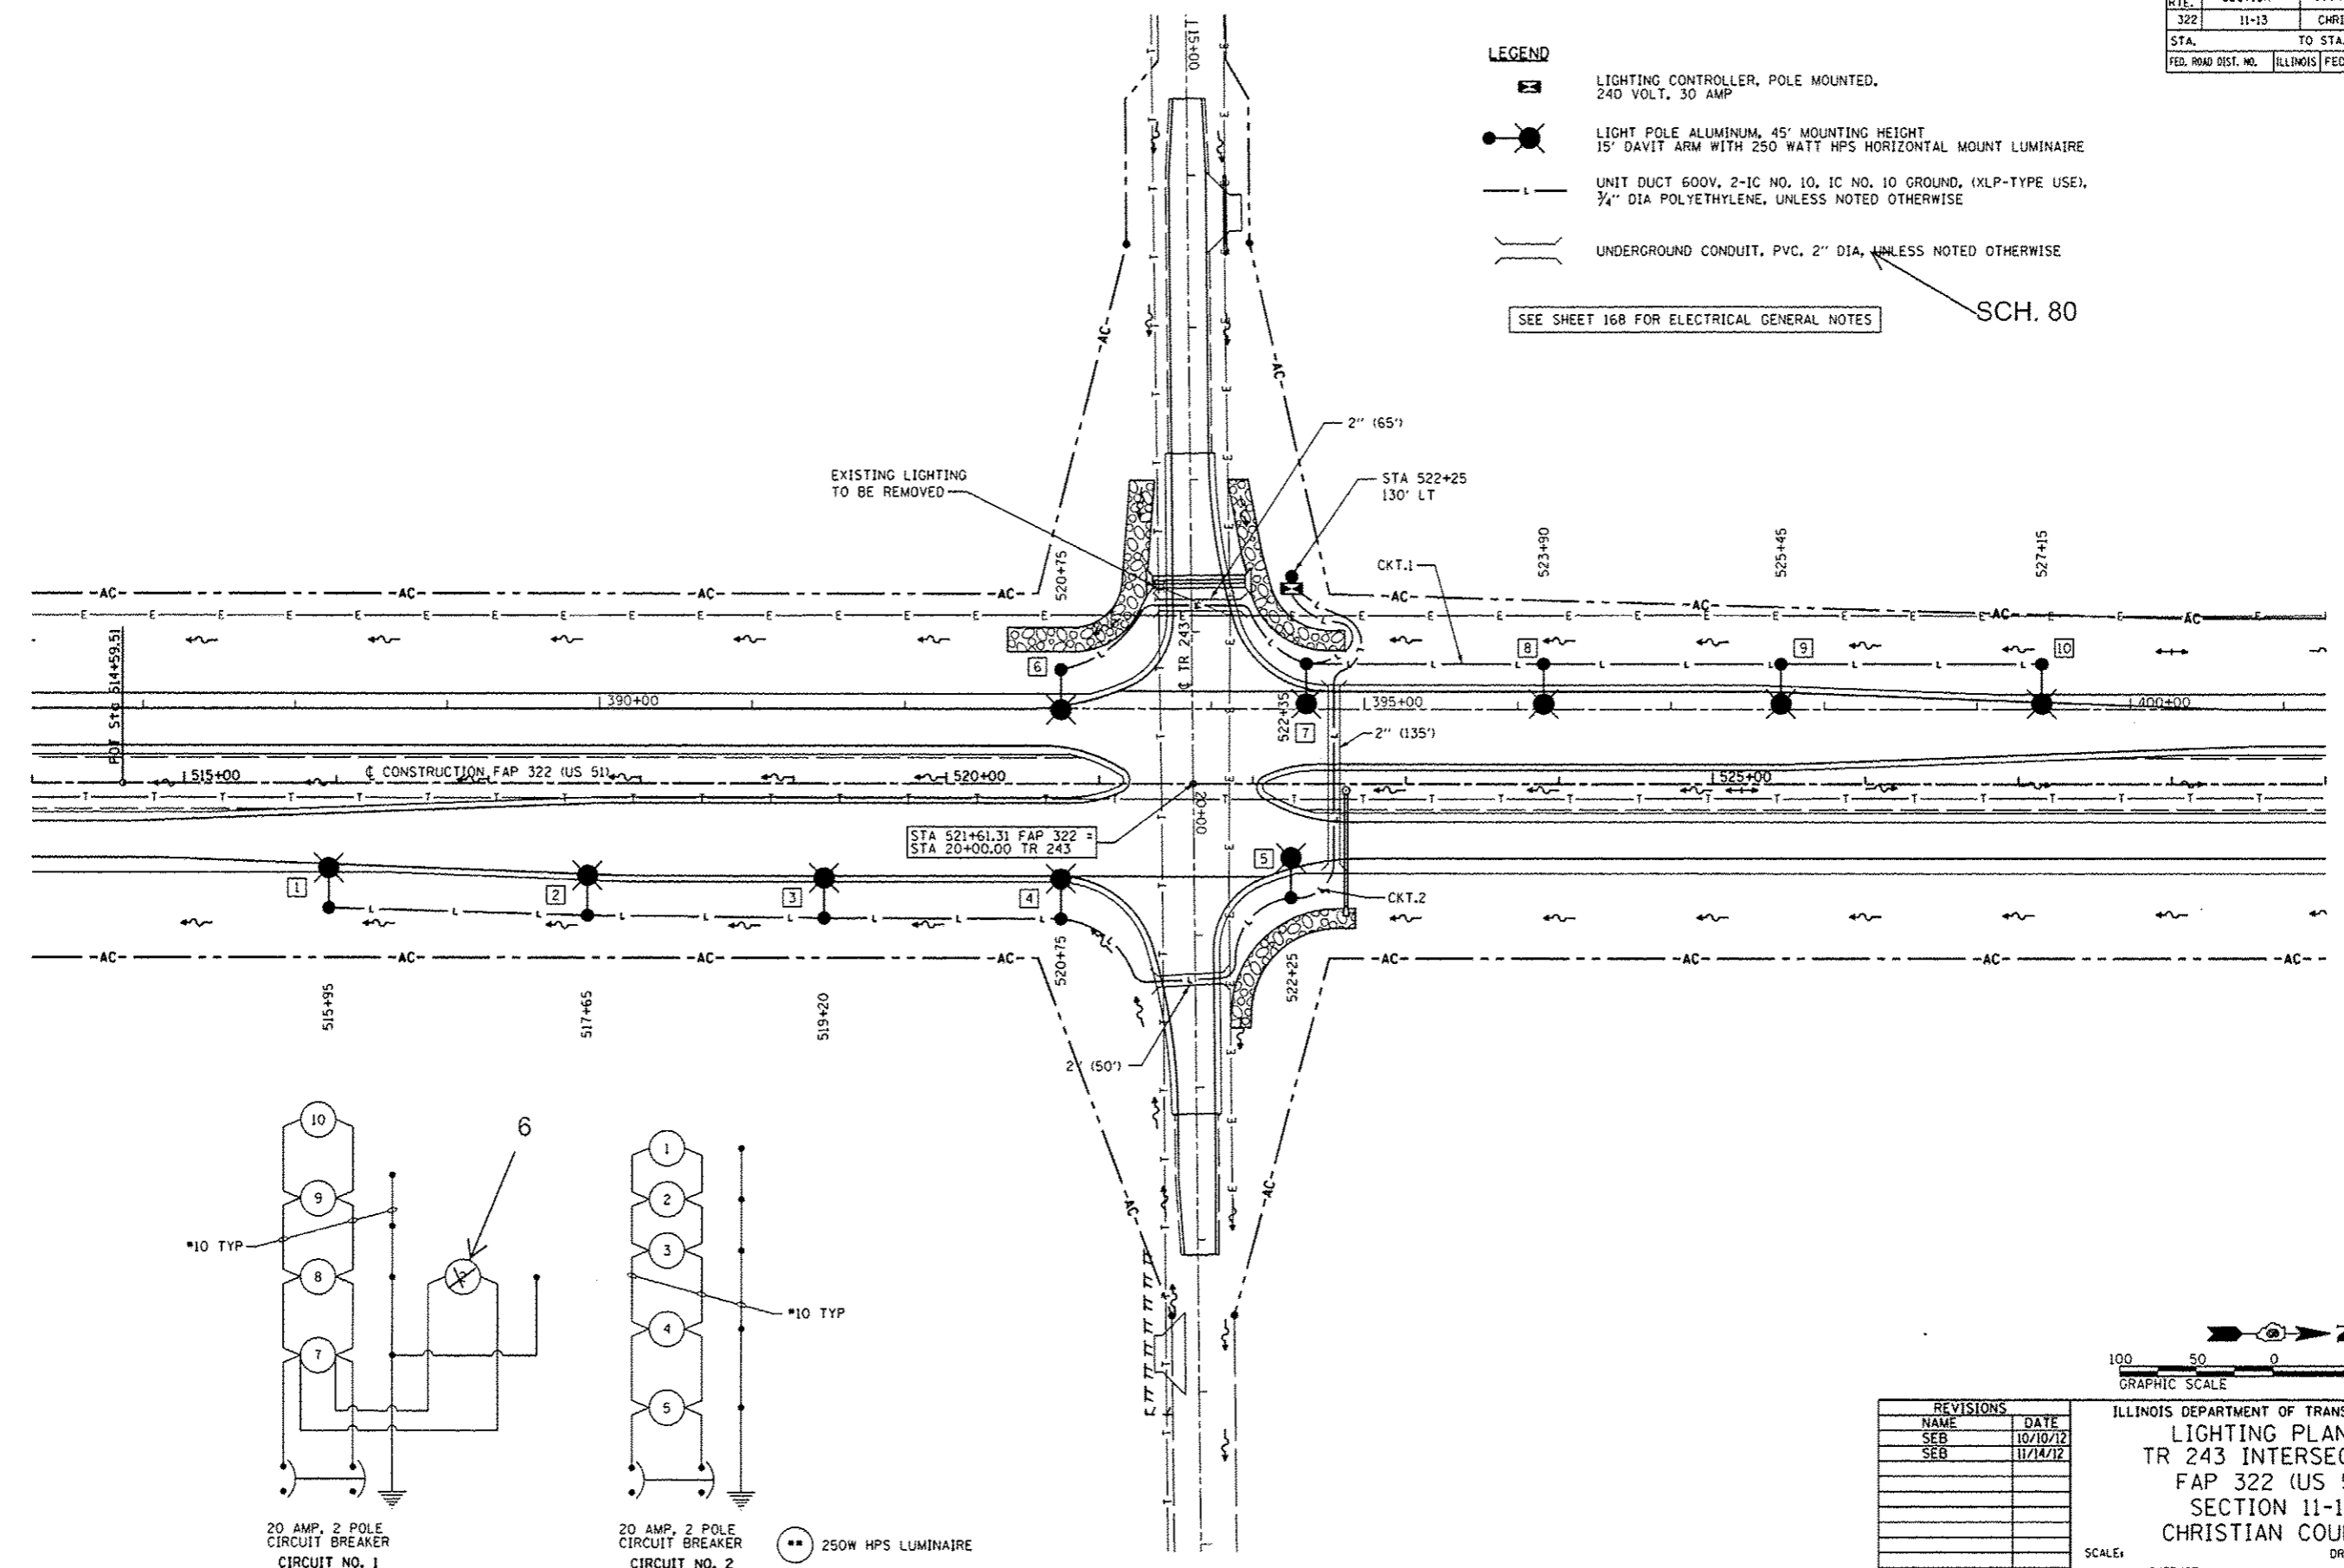

| REVISIONS | |
|-----------|----------|
| NAME | DATE |
| SEB | 10/10/12 |
| SEB | 11/14/12 |
| | |
| | |
| | |
| | |
| | |
| | |
| | |

ILLINOIS DEPARTMENT OF TRANSPORTATION
LIGHTING PLAN -
TR 243 INTERSECTION
FAP 322 (US 51)
SECTION 11-13
CHRISTIAN COUNTY

SCALE: DATE 8/27/07 DRAWN BY EBB CHECKED BY

11/14/2012
 C:\Users\jrb\Documents\Projects\11-13\11-13-12\11-13-12-176.dwg