

STATE OF ILLINOIS
DEPARTMENT OF TRANSPORTATION
DIVISION OF HIGHWAYS
**PLANS FOR PROPOSED
SAFE ROUTES
TO SCHOOL**

ROUTE NO	SECTION	COUNTY	SHEET NO.	TOTAL SHEETS
F.A.U. 9372	10-00023-00-SW	ST CLAIR	1	17
FEDERAL AID PROJECT				
CONTRACT NO. 97503				

INDEX OF SHEETS

SHEET NO.	DESCRIPTION
1.	COVER SHEET
2.	GENERAL NOTES AND LEGEND
3.	SUMMARY OF QUANTITIES
4.-5.	TYPICAL SECTIONS
6.-11.	SIDEWALK AND STORM SEWER PLAN AND PROFILE SHEETS
12.-13.	TRAFFIC SIGNAL MODIFICATION DETAILS
14.	DETAIL SHEET
15.-17.	CROSS SECTIONS

STANDARDS

000001-06	701901-02
280001-06	720001-01
424001-07	780001-03
424031-01	814001-02
542401-01	873001-02
602	878001-09
604021-02	880006-01
604036-02	
606301-04	
701501-06	
701801-05	

UTILITIES

SANITARY SEWER
VILLAGE OF FREEBURG
14 SOUTHGATE CENTER
FREEBURG, IL 62243

ELECTRIC
VILLAGE OF FREEBURG
14 SOUTHGATE CENTER
FREEBURG, IL 62243

PHONE/CABLE
AT&T
203 GOETHE
COLLINSVILLE, IL 62234



WATER
VILLAGE OF FREEBURG
14 SOUTHGATE CENTER
FREEBURG, IL 62243

GAS
AMEREN IP
1050 WEST BOULEVARD
P.O. BOX 428
BELLEVILLE, IL 62223

PHONE/CABLE
VERIZON
111 EAST STATE STREET
MASCOUTAH, IL 62258


F.A.U. ROUTE 9372
VILLAGE OF FREEBURG
ST CLAIR COUNTY
SECTION 10-00023-00-SW
PROJECT NO. SRTS-4009(111)
JOB NO. C-40-103-09

PLAN 1"=10'
PROFILE HORIZ 1"=10'
PROFILE VERT. 1"=5'
CROSS SECTIONS 1"=10' HORIZ.
1"=5' VERT.

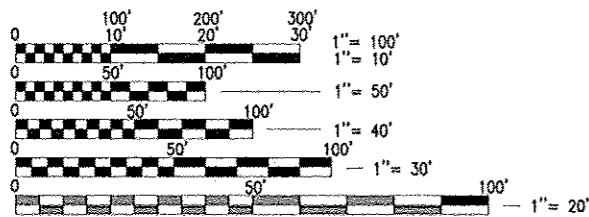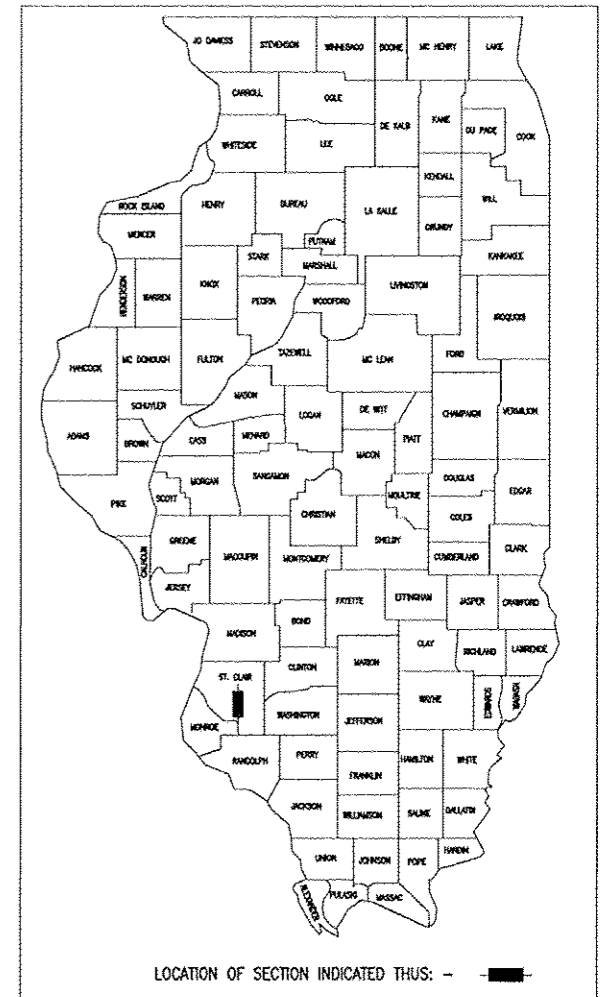

FULL SIZE PLANS HAVE BEEN PREPARED USING STANDARD ENGINEERING SCALES, REDUCED SIZED PLANS WILL NOT CONFORM TO STANDARD SCALES, IN MAKING MEASUREMENTS ON REDUCED PLANS, THE ABOVE SCALES MAY BE USED.

F.A.U. ROUTE 9372 DESIGN DESIGNATION
ROADWAY CLASSIFICATION = URBAN COLLECTOR
CURRENT TRAFFIC (ADT) = 3,150

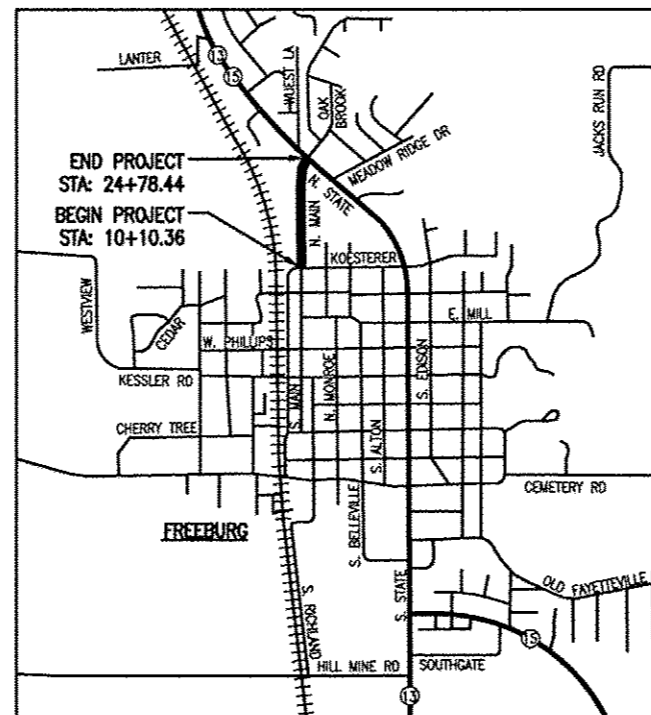

LOCATION MAP
N.T.S.

NET LENGTH PROJECT = 1468.08' (0.28 MILES)



APPROVED 8/14 20 12
[Signature]
LOCAL AGENCY OFFICIAL

PASSED NOV. 16 20 12
[Signature]
DISTRICT EIGHT ENGINEER OF LOCAL ROADS & STREETS

Released For Bid Based on Limited Review
NOV. 16 20 12
[Signature]
DEPUTY DIRECTOR OF HIGHWAYS, REGION FIVE ENGINEER

STATE OF ILLINOIS
DEPARTMENT OF TRANSPORTATION

[Signature] 8/16/12
MARSHA J. MALLER, P.E. NO. 62-51334 DATE
EXPIRES: NOVEMBER 30, 2013



THOUVENOT, WADE & MOERCHEN, INC.

PRINTED BY THE AUTHORITY OF THE STATE OF ILLINOIS

J.U.L.I.E.
JOINT UTILITY LOCATION INFORMATION FOR EXCAVATION
1-800-892-0123

CONTRACT NO. 97503