
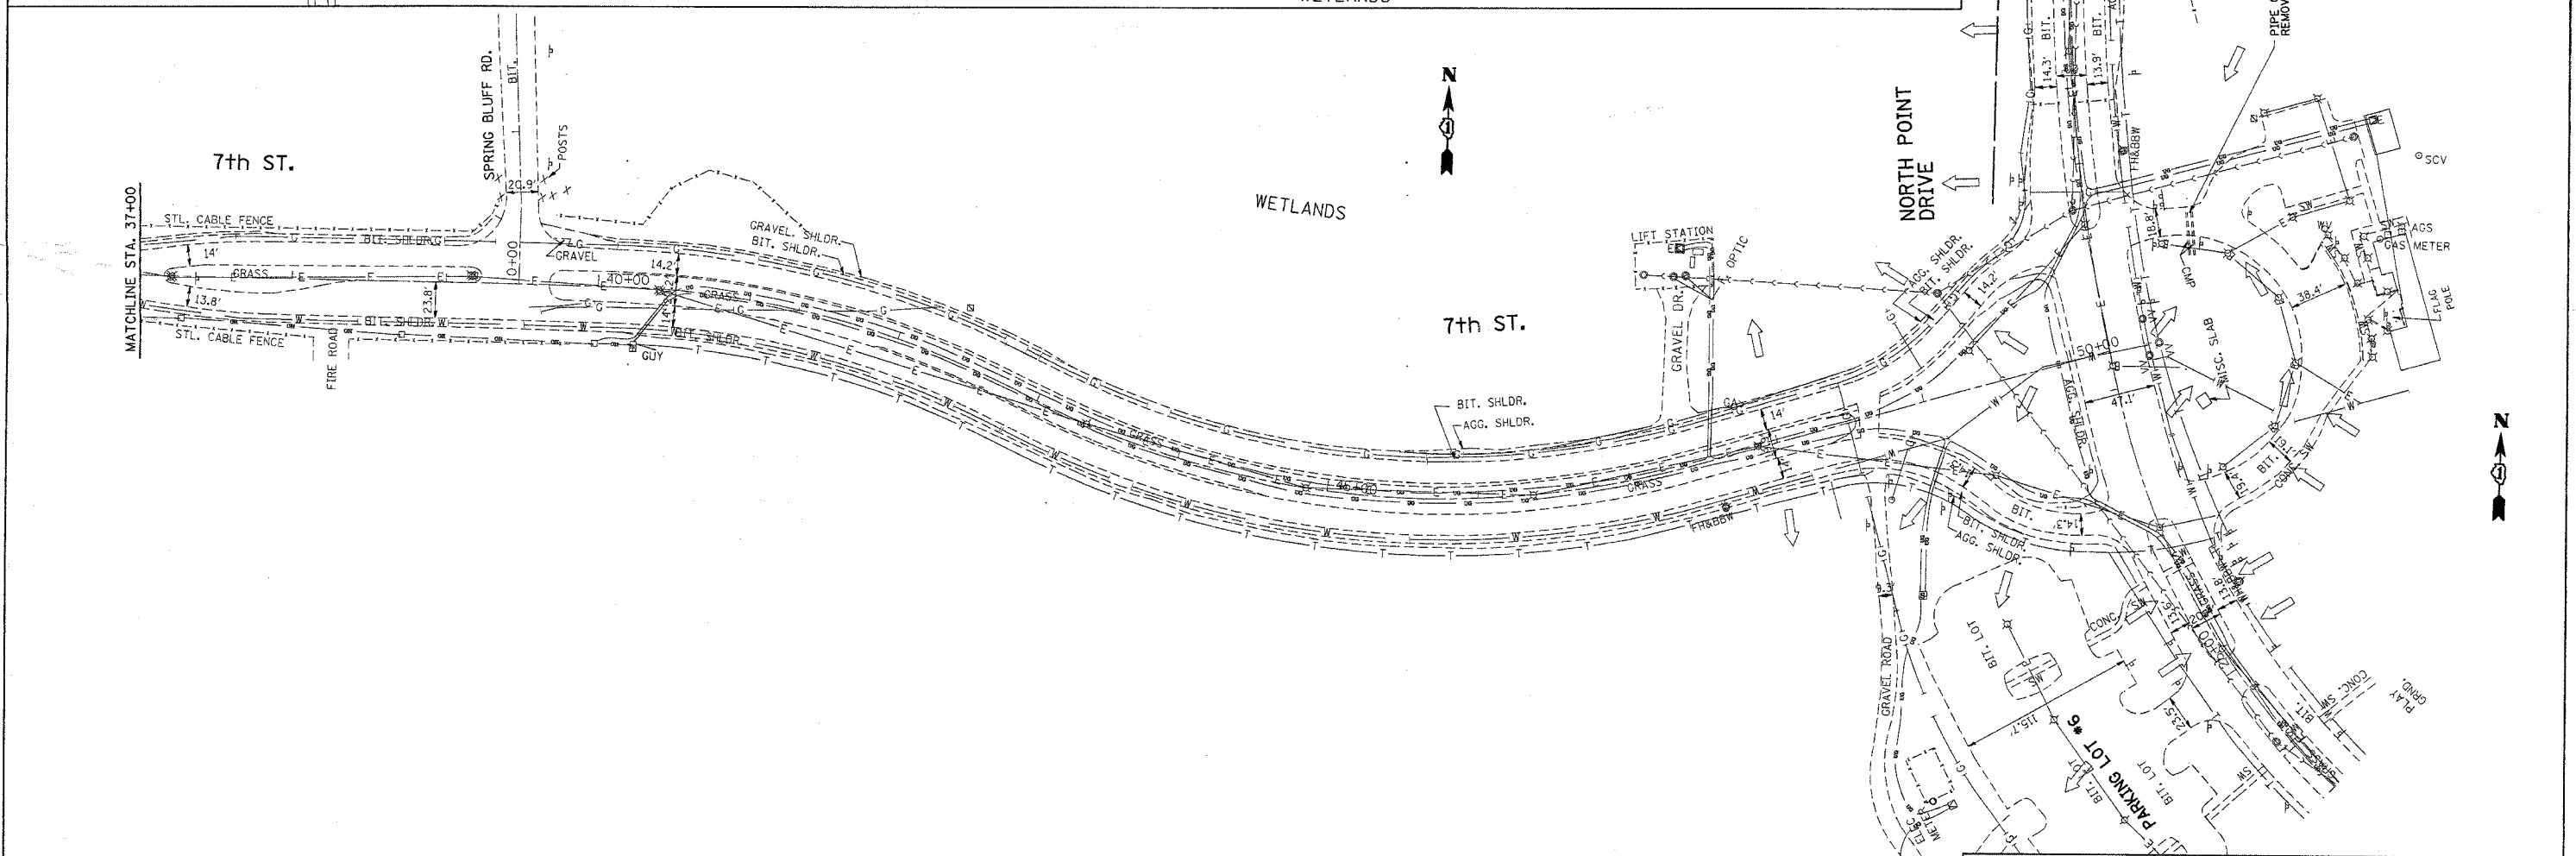


F.A. RTE.	SECTION	COUNTY	TOTAL SHEETS	SHEET NO.
* 2004-025-RS	LAKE	ILLINOIS	116	50
STA.	TO STA.			
FED. ROAD DIST. NO.	ILLINOIS FED. AID PROJECT			
* PARK ROADS		CONTRACT NO. 62745		
IDNR FILE NO. 2-03-025A				

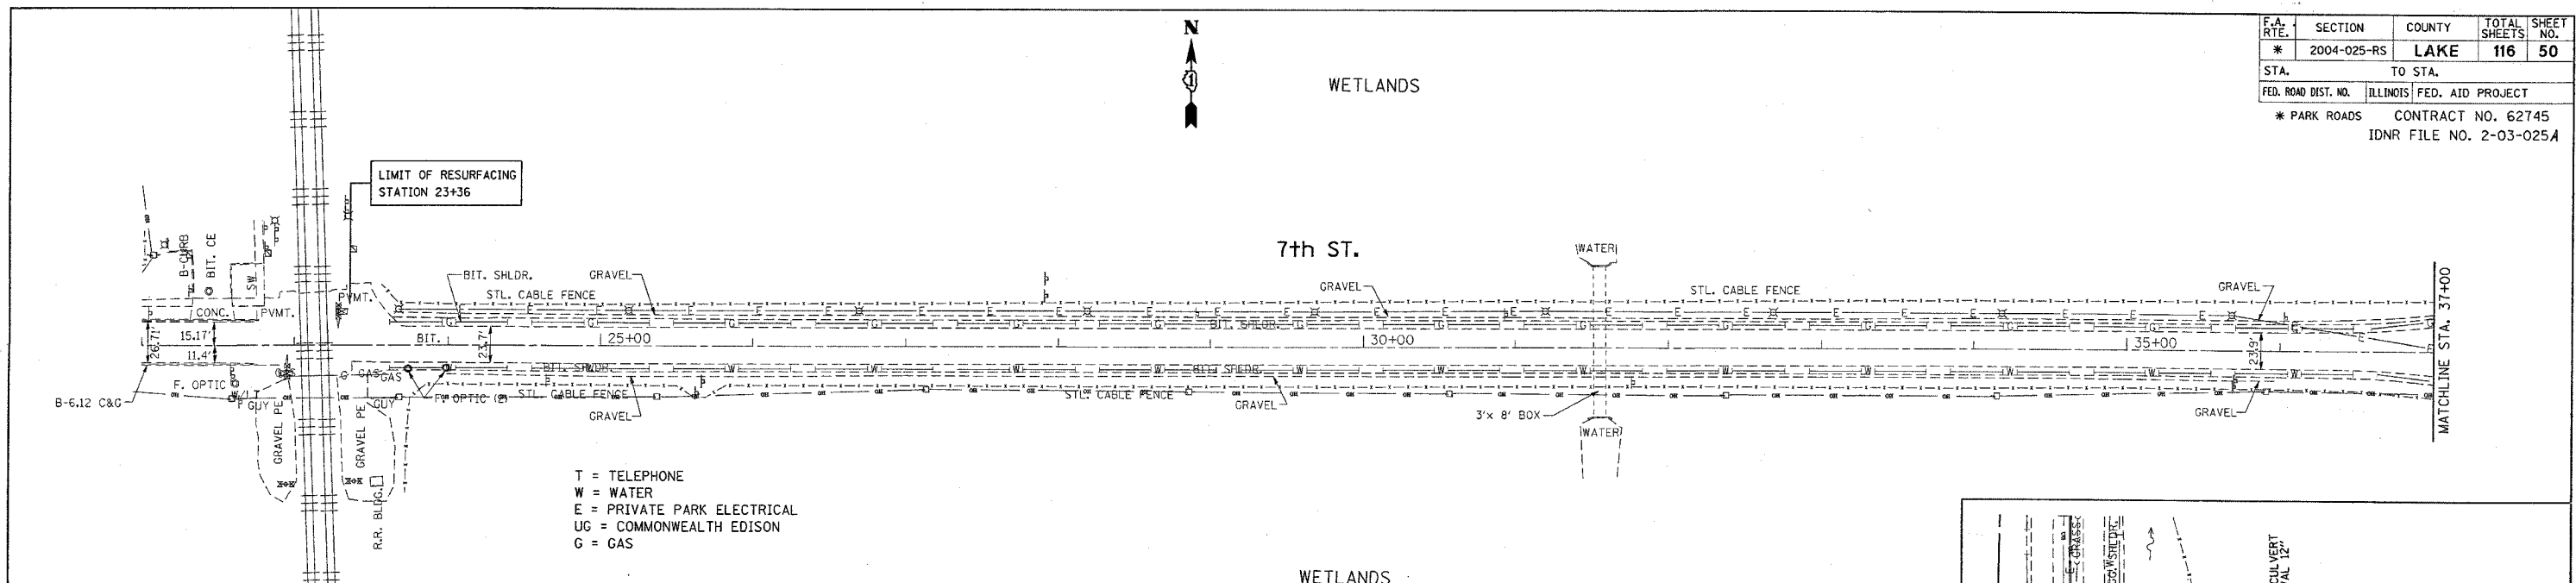

- T = TELEPHONE
- W = WATER
- E = PRIVATE PARK ELECTRICAL
- UG = COMMONWEALTH EDISON
- G = GAS

REVISIONS	
NAME	DATE

ILLINOIS DEPARTMENT OF TRANSPORTATION

**NORTH POINT MARINA
7TH STREET
EXISTING UTILITY & DRAINAGE PLAN**

SCALE: VERT. 1"=50'
DATE: 3/6/2006

DRAWN BY
CHECKED BY

PLOT DATE = 3/6/2006
FILE NAME = c:\np\2006\10134482\sh_d.mxd
PLOT SCALE = 1/8"=1'-0"
USER NAME = jmahk