


CONTRACT NO. 62745

F.A. RTE.	SECTION	COUNTY	TOTAL SHEETS	SHEET NO.
*	2004-025-RS	LAKE	116	60
STA.	TO STA.			
FED. ROAD DIST. NO.	ILLINOIS	FED. AID PROJECT		

\* PARK ROADS

IDNR FILE NO. 2-03-025A

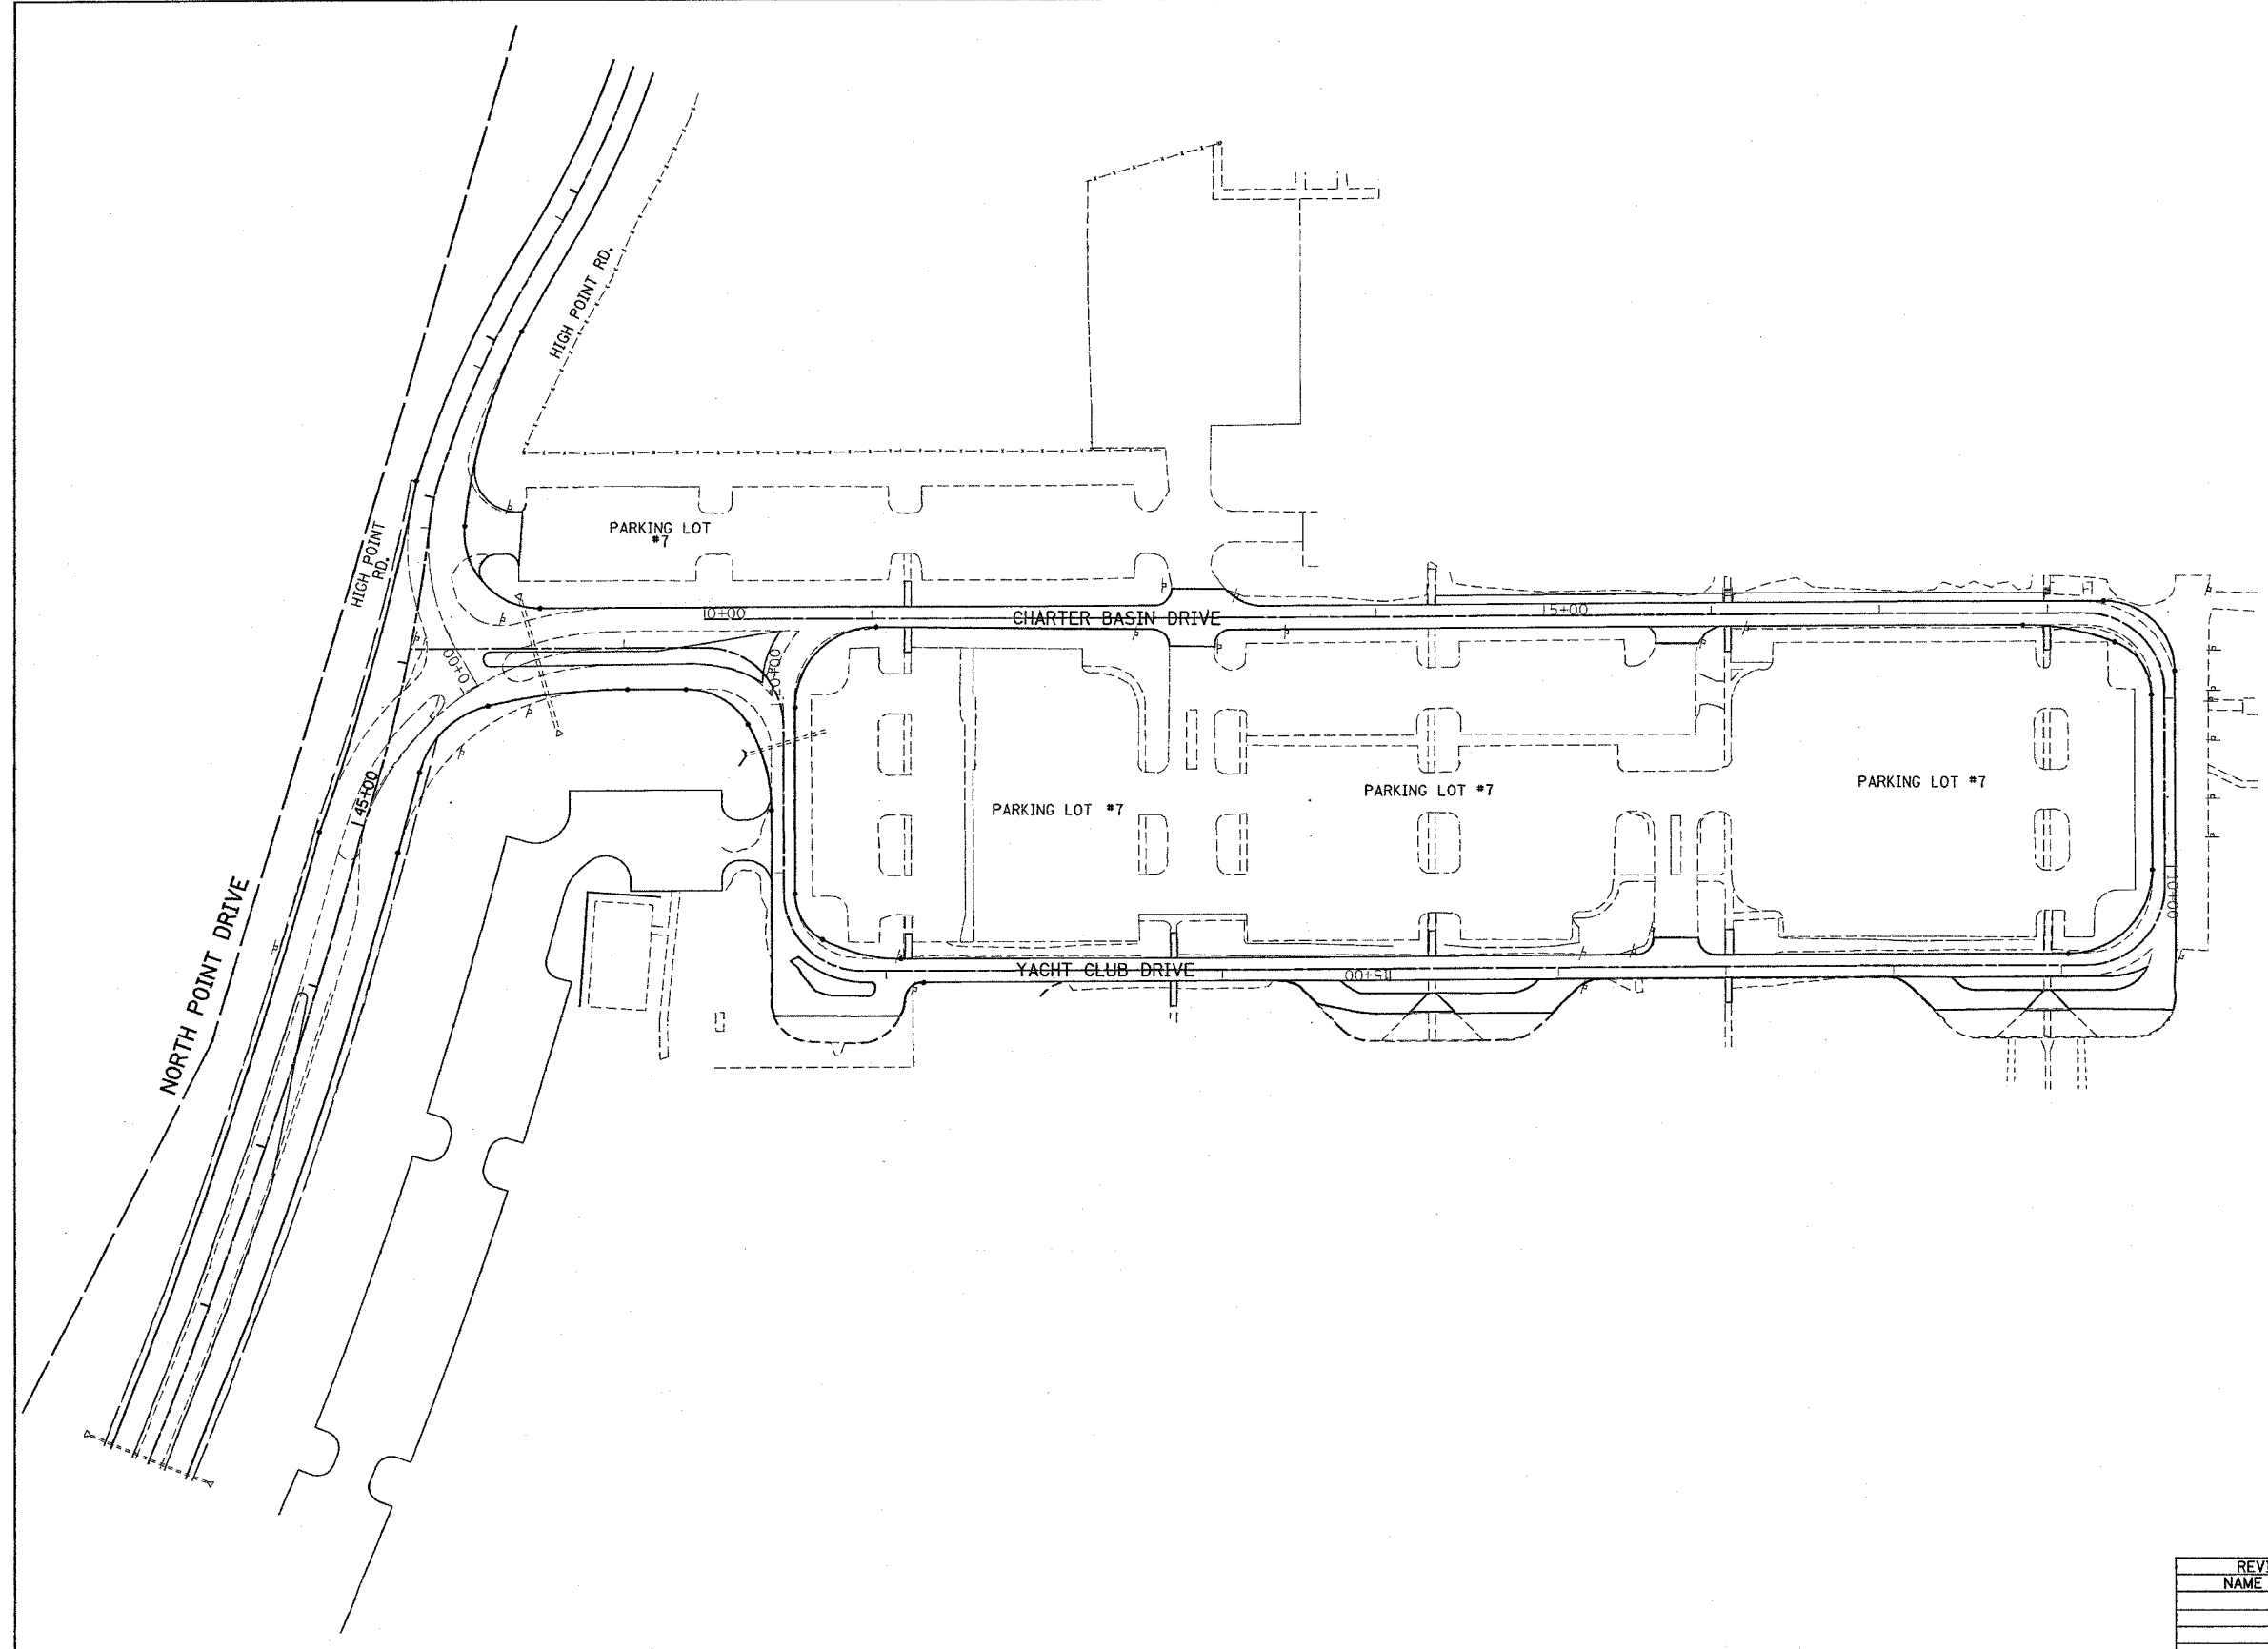

PLOT DATE = 1/6/2006  
 FILE NAME = c:\p\proj\p134482\sh\_dran.dgn  
 PLOT SCALE = 50.000000 / IN.  
 USER NAME = drvakosgn

REVISIONS	
NAME	DATE

ILLINOIS DEPARTMENT OF TRANSPORTATION

**NORTH POINT MARINA  
 YACHT CLUB DRIVE  
 PROPOSED DRAINAGE PLAN**

SCALE: VERT. 1"=50'  
 HORIZ. 1"=50'  
 DATE: 1/6/2006

DRAWN BY  
 CHECKED BY