
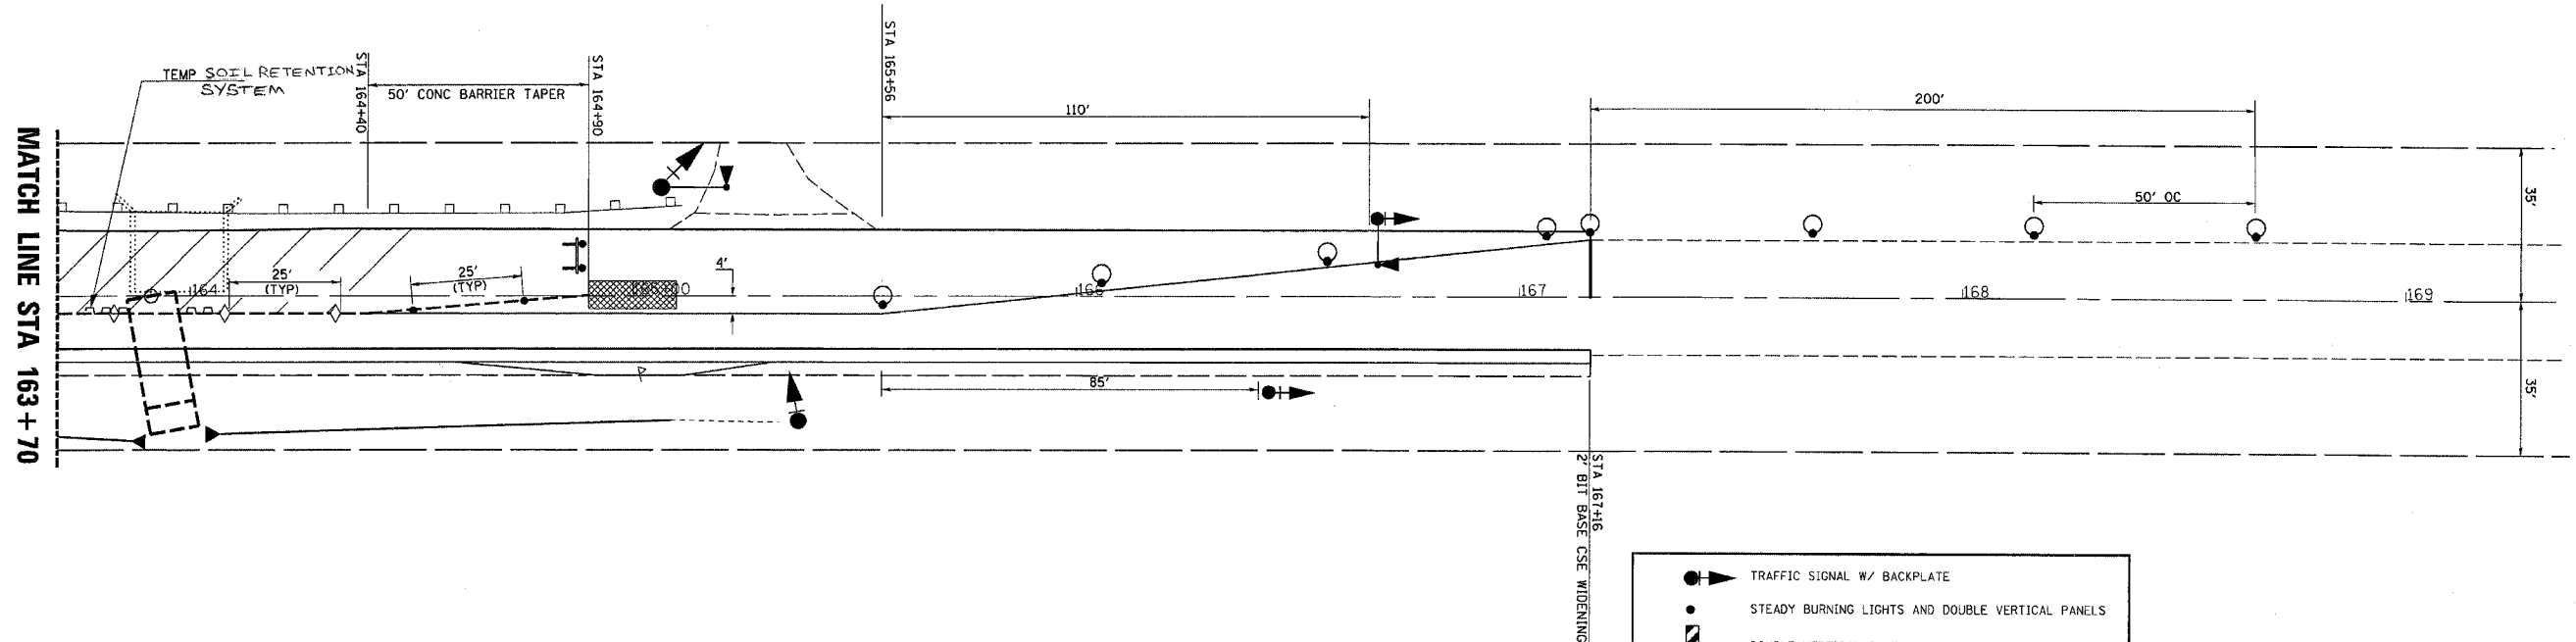


F.A.P. RTE.	SECTION	COUNTY	TOTAL SHEETS	SHEET NO.
635	(105)BR-2	KANKAKEE	25	13
STA. _____ TO STA. _____		FED. ROAD DIST. NO. ILLINOIS FED. AID PROJECT		

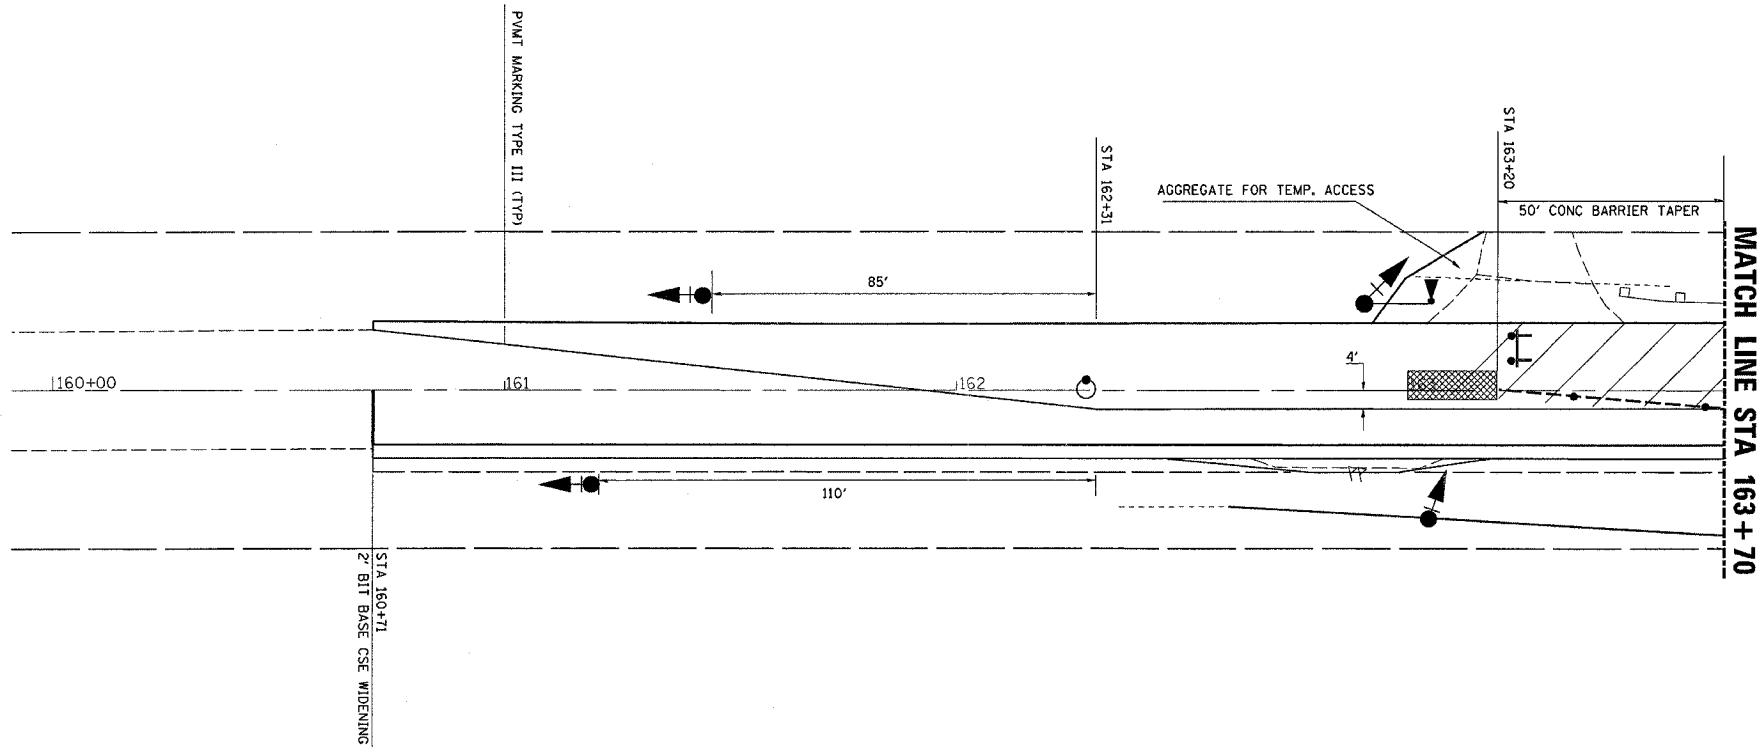

**STAGE I
SEQUENCE OF OPERATIONS**

1. INSTALL TEMPORARY TRAFFIC SIGNALS, ATTENUATORS, TEMPORARY CONCRETE BARRIERS, DRUMS, ALL OTHER ITEMS AS PER THESE DETAILS AND AS PER LANE CLOSURE 2L, 2W, BRIDGE REPAIR WITH BARRIER STANDARD 701321, BEGIN OPERATING UNDER STAGE I TRAFFIC CONDITIONS.
2. REMOVE EXISTING PAVEMENT, AGGREGATE SHOULDERS, GUARDRAIL & TRAFFIC BARRIER TERMINALS, EXCAVATE, AND REMOVE PORTION OF EXISTING STRUCTURE.
3. CONSTRUCT NEW PORTION OF PROPOSED BOX CULVERT, BACKFILL, COMPACT, PAVEMENT, BITUMINOUS BASE COURSE, AND ROUGH GRADING OF DITCHES.

- NOTES:**
1. SEE STANDARD 701321 FOR SIGNAGE AND FOR OTHER DETAILS NOT SHOWN
 2. STAGE I TRAFFIC SHALL OPERATE WITH THE EXISTING GUARDRAIL (LT) REMAINING IN PLACE.

	TRAFFIC SIGNAL W/ BACKPLATE
	STEADY BURNING LIGHTS AND DOUBLE VERTICAL PANELS
	DOUBLE VERTICAL PANEL
	TYPE C BIDIRECTIONAL REFLECTOR
	IMPACT ATTENUATOR
	DRUM WITH STEADY BURNING LIGHT
	WORK AREA
	TEMPORARY CONCRETE BARRIER
	MICROWAVE DETECTOR
	BITUMINOUS BASE COURSE WIDENING (PRE STAGE I)
	TYPE III BARRICADE

ILLINOIS DEPARTMENT OF TRANSPORTATION
**TRAFFIC CONTROL
PROTECTION, STAGE II**

8/31/2006 12:50:58 PM c:\pr\proj\66456\0003\000111.s.dgn