



F.A.P. RTE.	SECTION	COUNTY	TOTAL SHEETS	SHEET NO.
315	(34-6,55-1)	HANCOCK/MCDONOUGH	433	137
STA. 695+00.00 TO STA. 705+00.00		FED. AID PROJECT		
FED. ROAD DIST. NO.		ILLINOIS		
STATE CONTRACT NO. 68206				

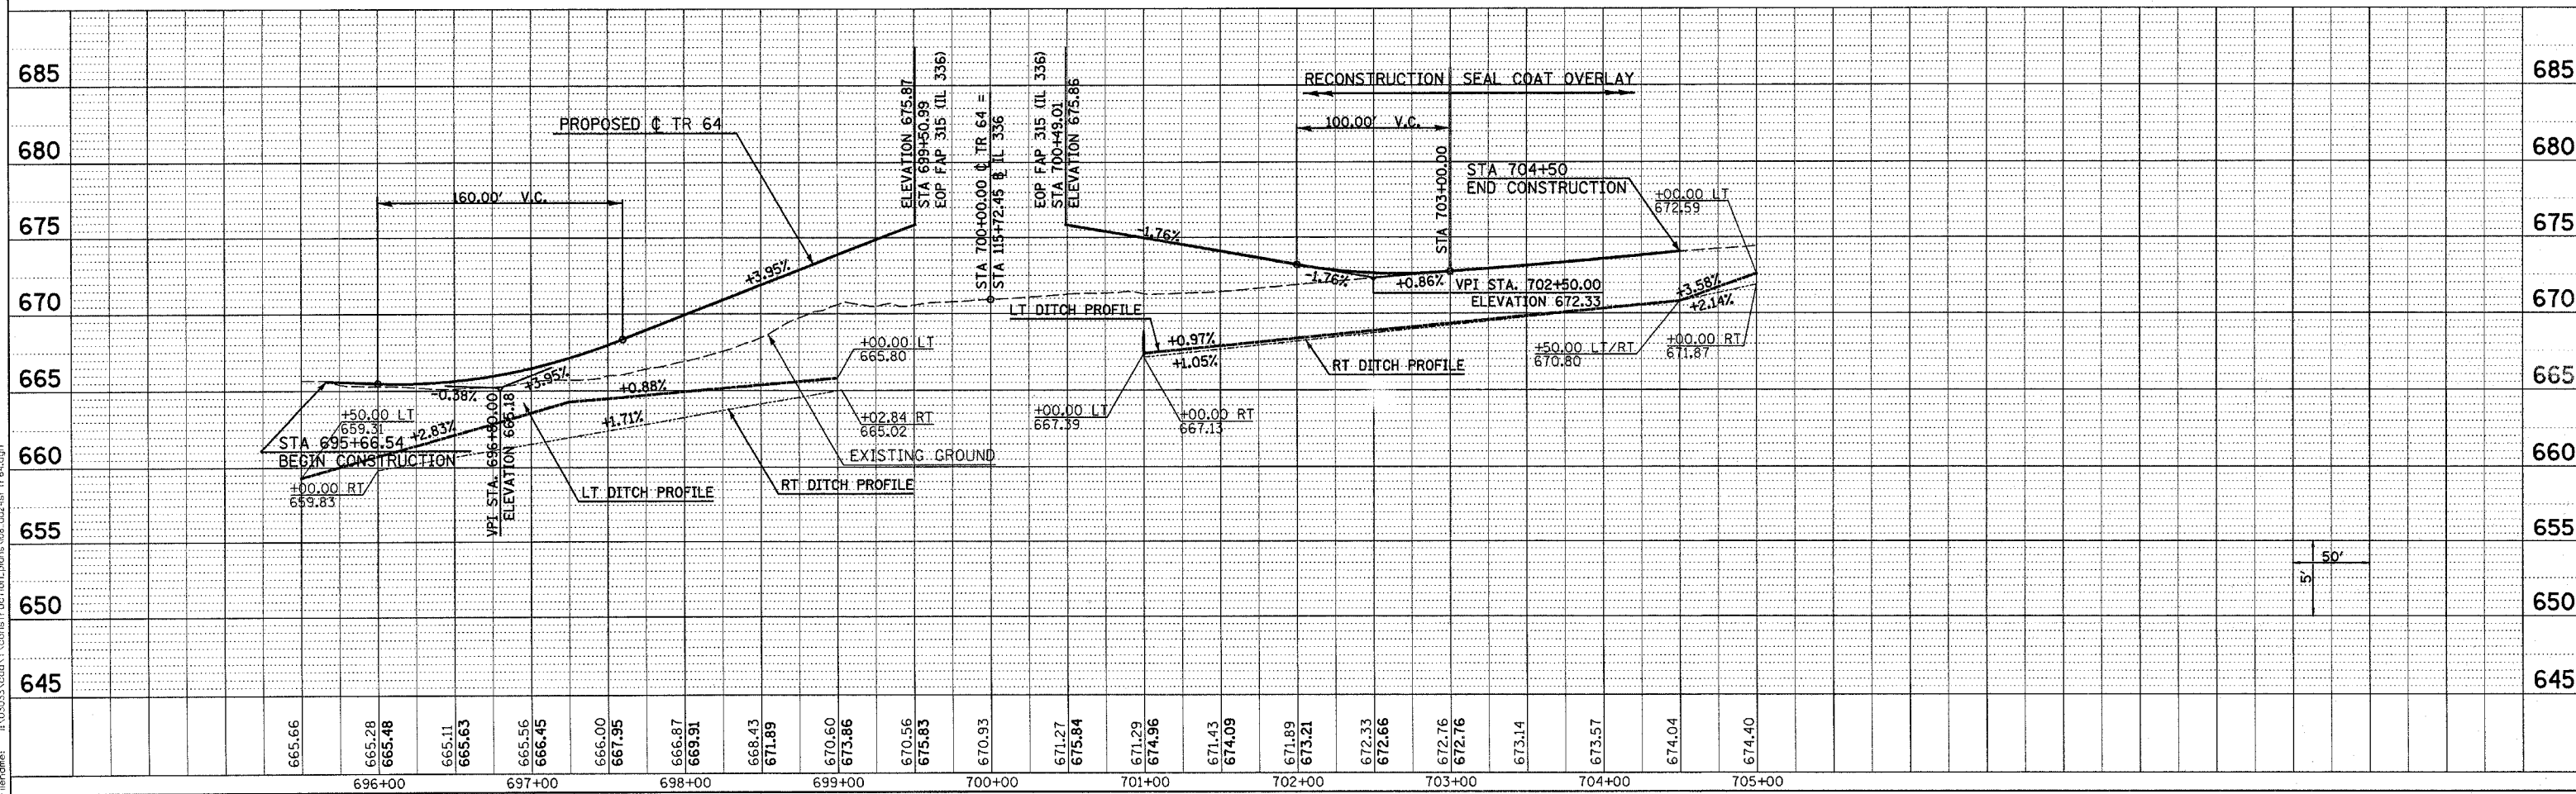

DATE	BY
DATE	BY
DATE	BY

DATE	BY
DATE	BY
DATE	BY

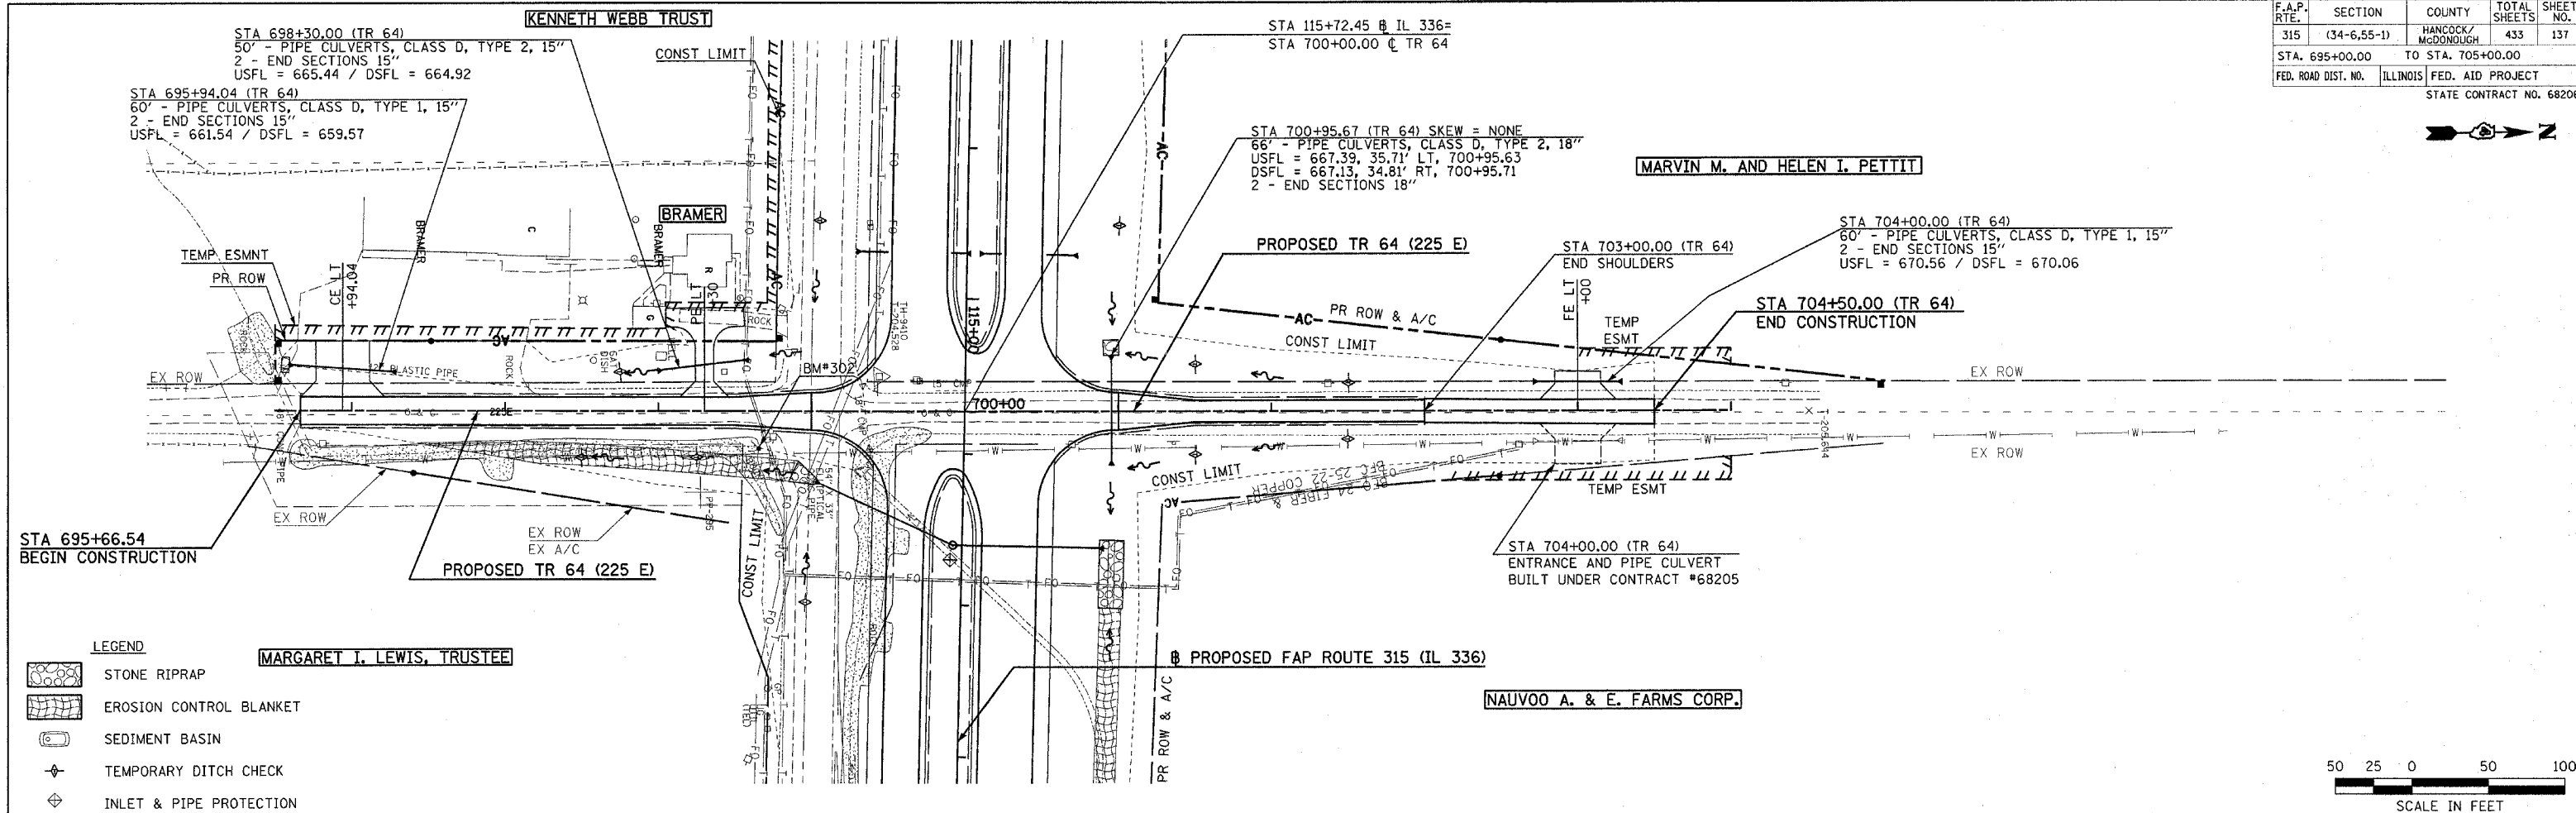

Plot Date: 7/18/2006
 Plot Time: 3:28:04 PM
 Plotted By: dschmidt
 File Name: I:\02033\cd\1\constr\utility\plan\p06s\08.dwg

DRAINAGE AND UTILITY PLAN & PROFILE - TR 64