

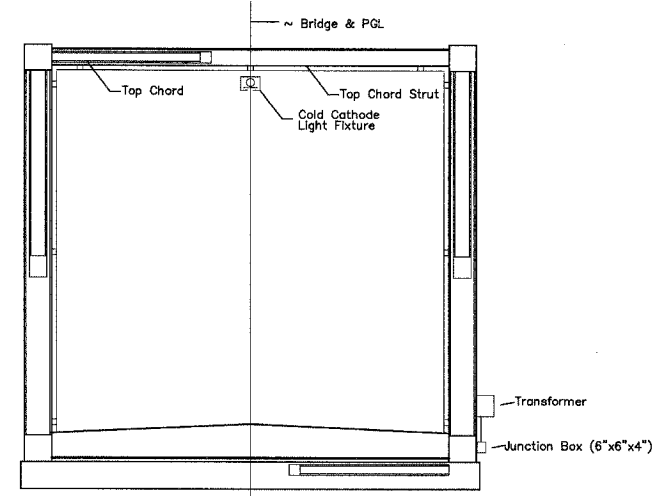


F.A. - RTE.	SECTION	COUNTY	TOTAL SHEETS	SHEET NO.
94-P4031-00-BR	DUPAGE		54	53B


CONTRACT NO. 83560

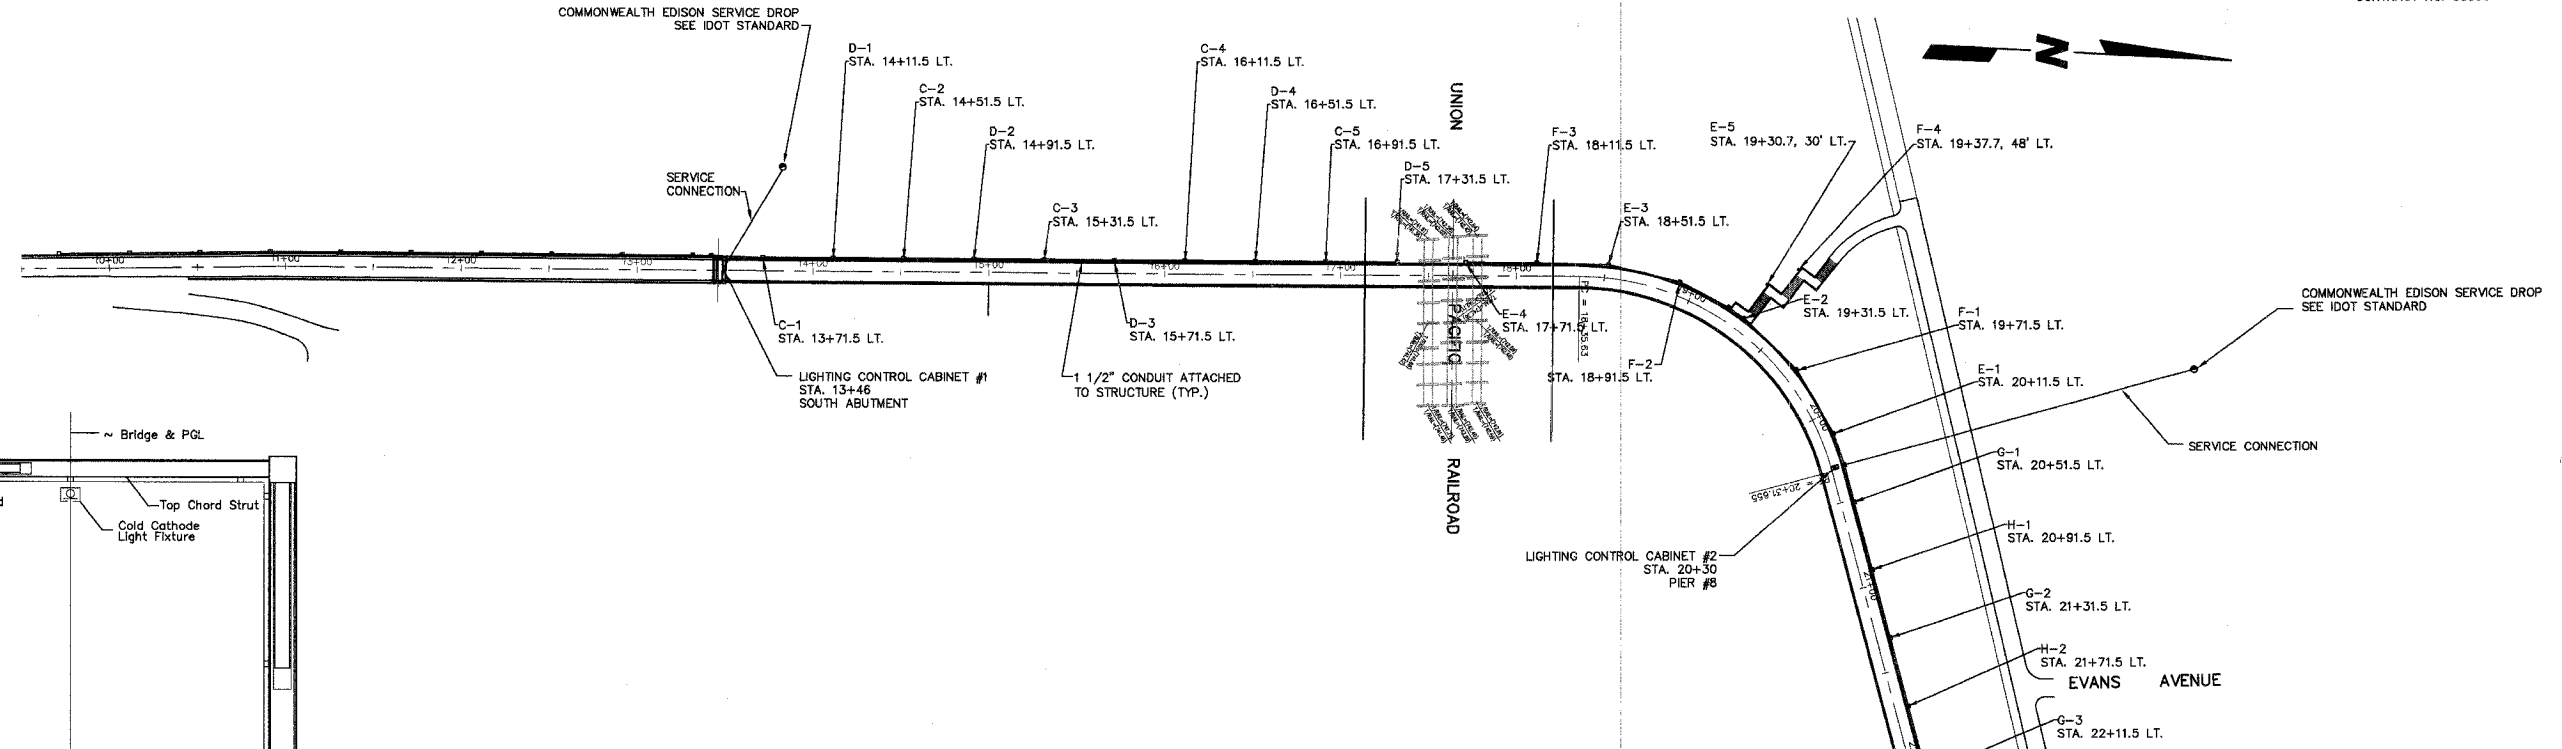


BRIDGE CROSS SECTION

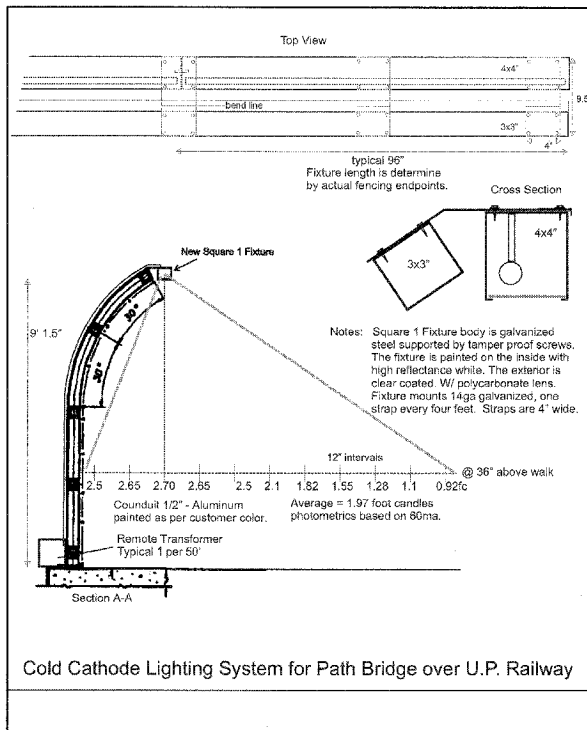

Cold Cathode Lighting System for Path Bridge over U.P. Railway

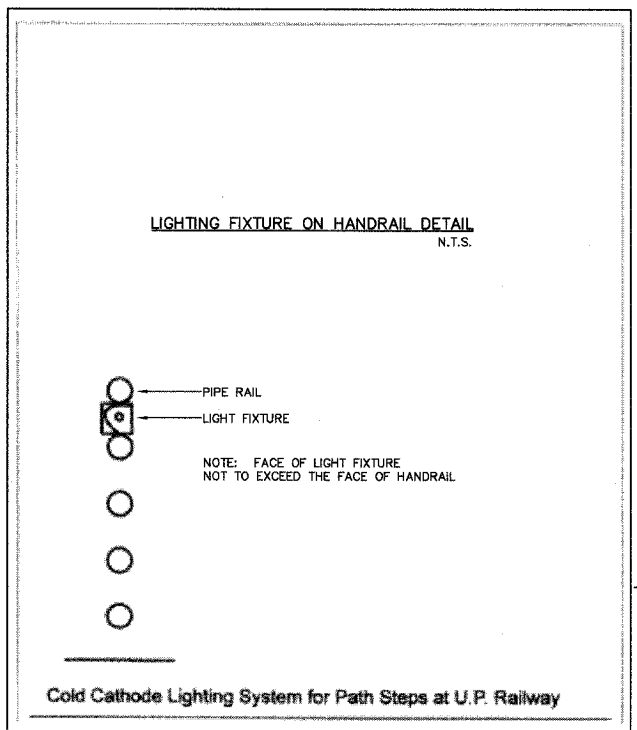

Cold Cathode Lighting System for Path Steps at U.P. Railway

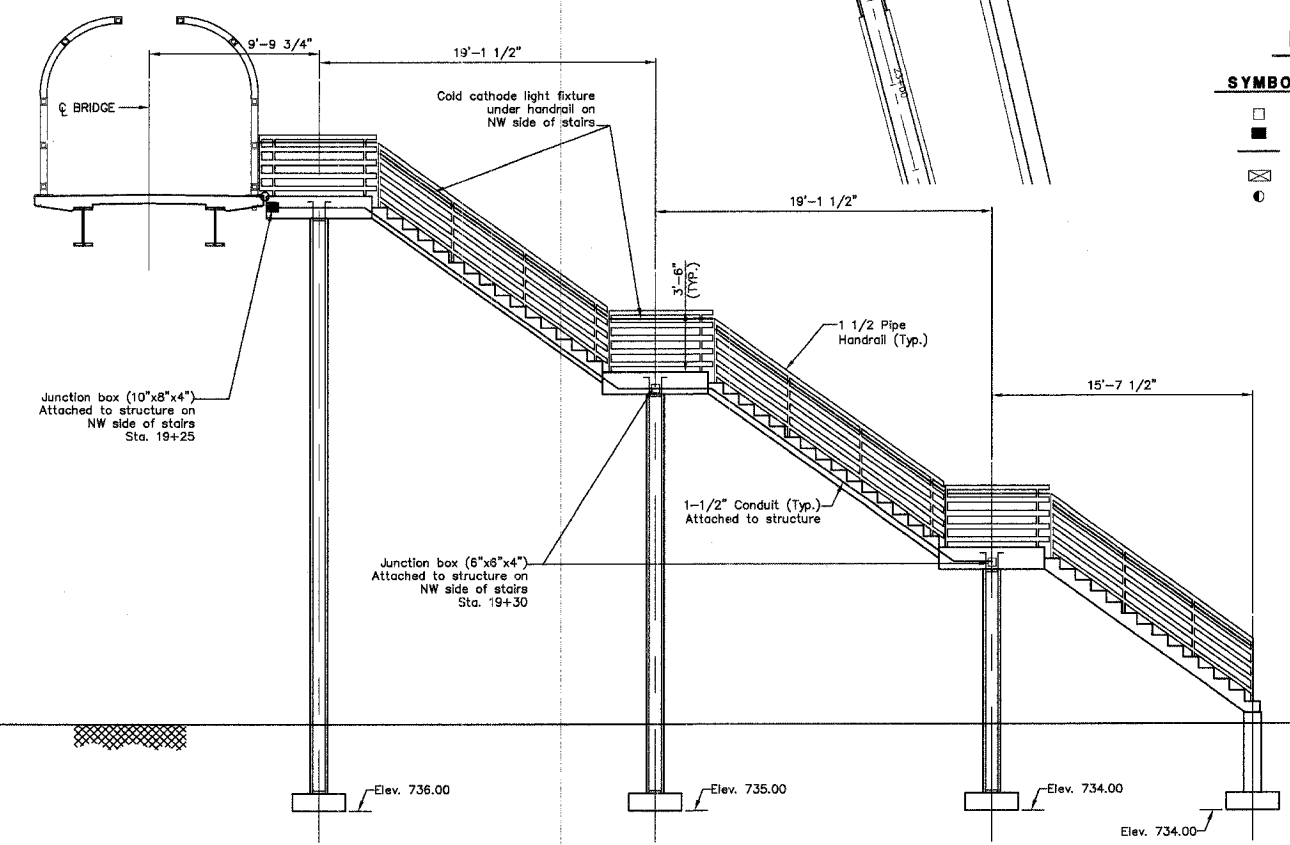

ELEVATION

LEGEND

SYMBOL	DESCRIPTION
□	JUNCTION BOX 6"X6"X4"
■	JUNCTION BOX 10"X8"X4"
—	1-1/2" CONDUIT
⊞	LIGHTING CONTROL CABINET
○	COMMONWEALTH EDISON SERVICE DROP

PREPARED FOR:
WHEATON PARK DISTRICT
 666 S. MAIN STREET
 WHEATON, ILLINOIS 60187



PREPARED BY:
CEMCON, Ltd.
 Consulting Engineers, Land Surveyors & Planners
 2280 White Oak Circle, Suite 100
 Aurora, Illinois 60504-9675
 Ph: 630.862.2100 Fax: 630.862.2199
 E-Mail: codd@cemcon.com Website: www.cemcon.com

REVISIONS					
NO.	DATE	DESCRIPTION	NO.	DATE	DESCRIPTION

LIGHTING LAYOUT PLAN - BICYCLE PATH BRIDGE			
PEDESTRIAN/BICYCLE PATH BRIDGE OVER UNION PACIFIC RAILROAD			
FILE NAME: OVR LIGHT	DSGN. BY: MMH	JOB NO.: 551.007	FLD. BK./PG.: -----
DISC. NUMBER: 551007	DRN. BY: DRA	DATE: 04-26-04	SCALE: 1" = 50'
SHEET NO.			53B of 54

TAB: OVR LIGHT
 XREF: OVER_50.DWG
 Copyright © 2003 Cemcon, Ltd. All rights reserved.