

F.A.P. NO.	SECTION	COUNTY	TOTAL SHEETS	SHEET NO.
344	00-00074-00-LT	COOK	12	1
STA.		TO STA.		
FED. ROAD DIST. NO.	ILLINOIS	FED. AID PROJECT		

STATE OF ILLINOIS
DEPARTMENT OF TRANSPORTATION
DIVISION OF HIGHWAYS

PLANS FOR PROPOSED
FEDERAL AID HIGHWAY

INDEX OF SHEETS

- 1. COVER SHEET
- 2. SUMMARY OF QUANTITIES
- 3-6. PLAN SHEETS
- 7. SINGLE LINE DIAGRAM
- 8-12. CONSTRUCTION DETAILS



STATE STANDARDS

- 000001-04 Standard Symbols, Abbreviations and Patterns
- 701501-03 Lane Closure, 2L 2W, Day Or Night Operations, For Speeds < 45 MPH
- 701606-04 Lane Closure, Multilane, 2W, With Mountable Median, For Speeds < 45 MPH
- 701701-04 Lane Closure, Multilane, Intersection, For Speeds < 45 MPH
- 701801-03 Lane Closure, Multilane, 1W Or 2W, Crosswalk or Sidewalk Closure, For Speeds < 45 MPH
- 702001-05 TRAFFIC CONTROL DEVICES


SCALES PLAN - 1"=50'
CONSTRUCTION DETAILS - 1"=1'

F.A.P. ROUTE 344 (127TH STREET)
IL ROUTE 83 TO HOMAN AVENUE
STREET LIGHTING
PROJECT NO.: F-0344 (030)
M.F.T. SECTION NO.: 00-00074-00-LT
STATE SECTION NO.: 3034 L
VILLAGE OF ALSIP
COOK COUNTY
JOB NO.: C-91-043-03

LOCATED IN THE CITY OF:
ALSIP, ILLINOIS

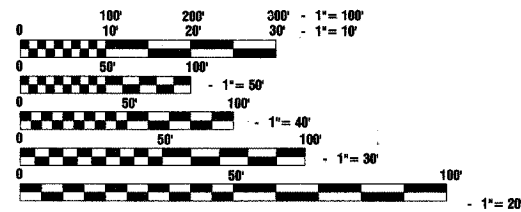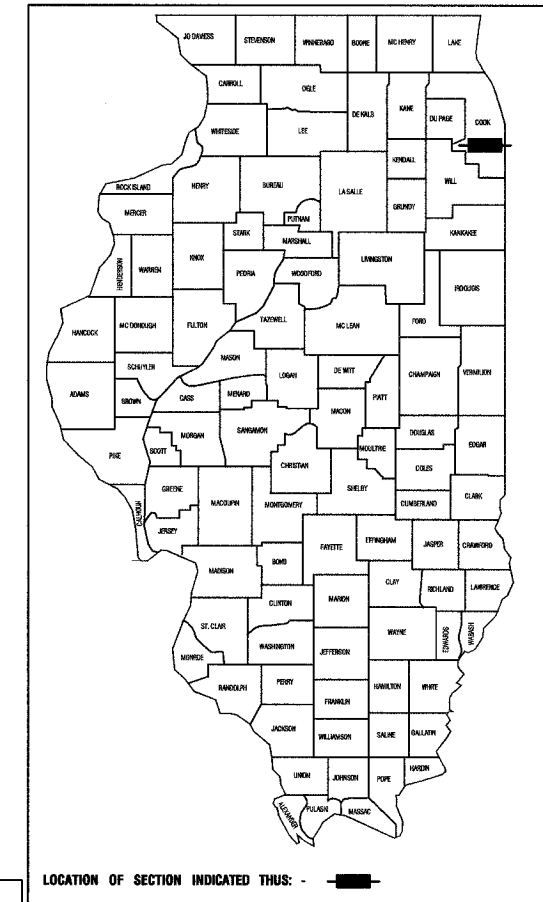

FULL SIZE PLANS HAVE BEEN PREPARED USING STANDARD ENGINEERING SCALES, REDUCED SIZED PLANS WILL NOT CONFORM TO STANDARD SCALES, IN MAKING MEASUREMENTS ON REDUCED PLANS, THE ABOVE SCALES MAY BE USED.

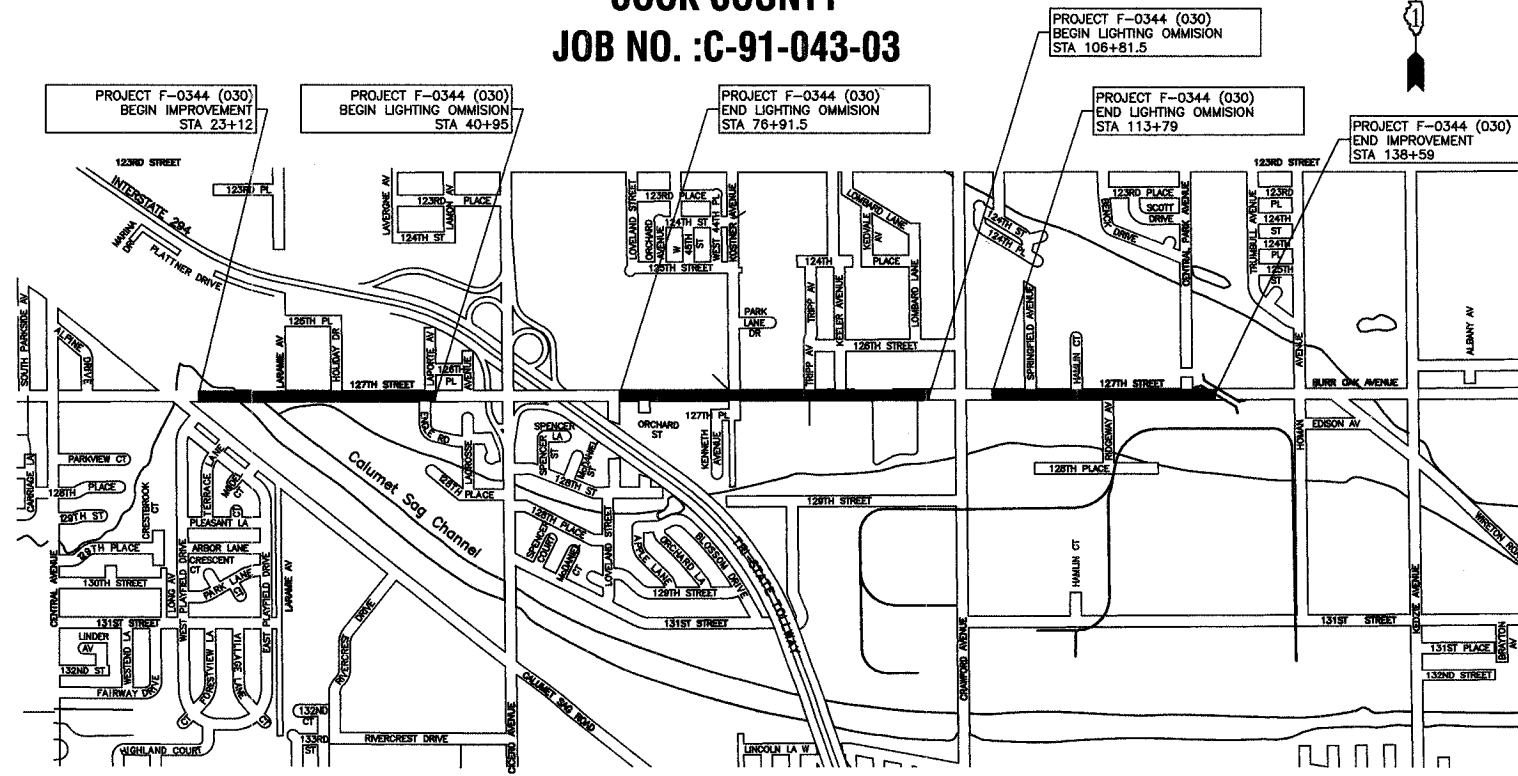


LOCATION MAP

SECTIONS 26-29, 32-35, TOWNSHIP 37, RANGE 13

GROSS LENGTH=13,679 FEET=2.59 MILES
NET LENGTH=8,482 FEET=1.61 MILES

PREPARED BY OR UNDER THE DIRECT SUPERVISION OF:

Thomas R. Lang
11/8/05

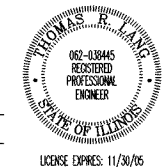

CALL JULIE TOLL FREE
1-800-892-0193

JOINT UTILITY LOCATING INFORMATION FOR EXCAVATORS

48 hours before you dig (EXCLUDING SAT., SUN. & HOL.)

Call

STATE OF ILLINOIS
DEPARTMENT OF TRANSPORTATION

APPROVED 11/8 2005
George E. Kitchin LOCAL AGENCY OFFICIAL

PASSED November 9 2005
[Signature] BUREAU CHIEF OF LOCAL ROADS & STREETS

PASSED Nov. 10 2005
Diane M. O'Keefe DEPUTY DIRECTOR OF HIGHWAYS, REGION ENGINEER

CONTRACT 83769

847-705-4189

I.D.O.T. FEDERAL AID COORDINATOR: PHIL MARCYN