
 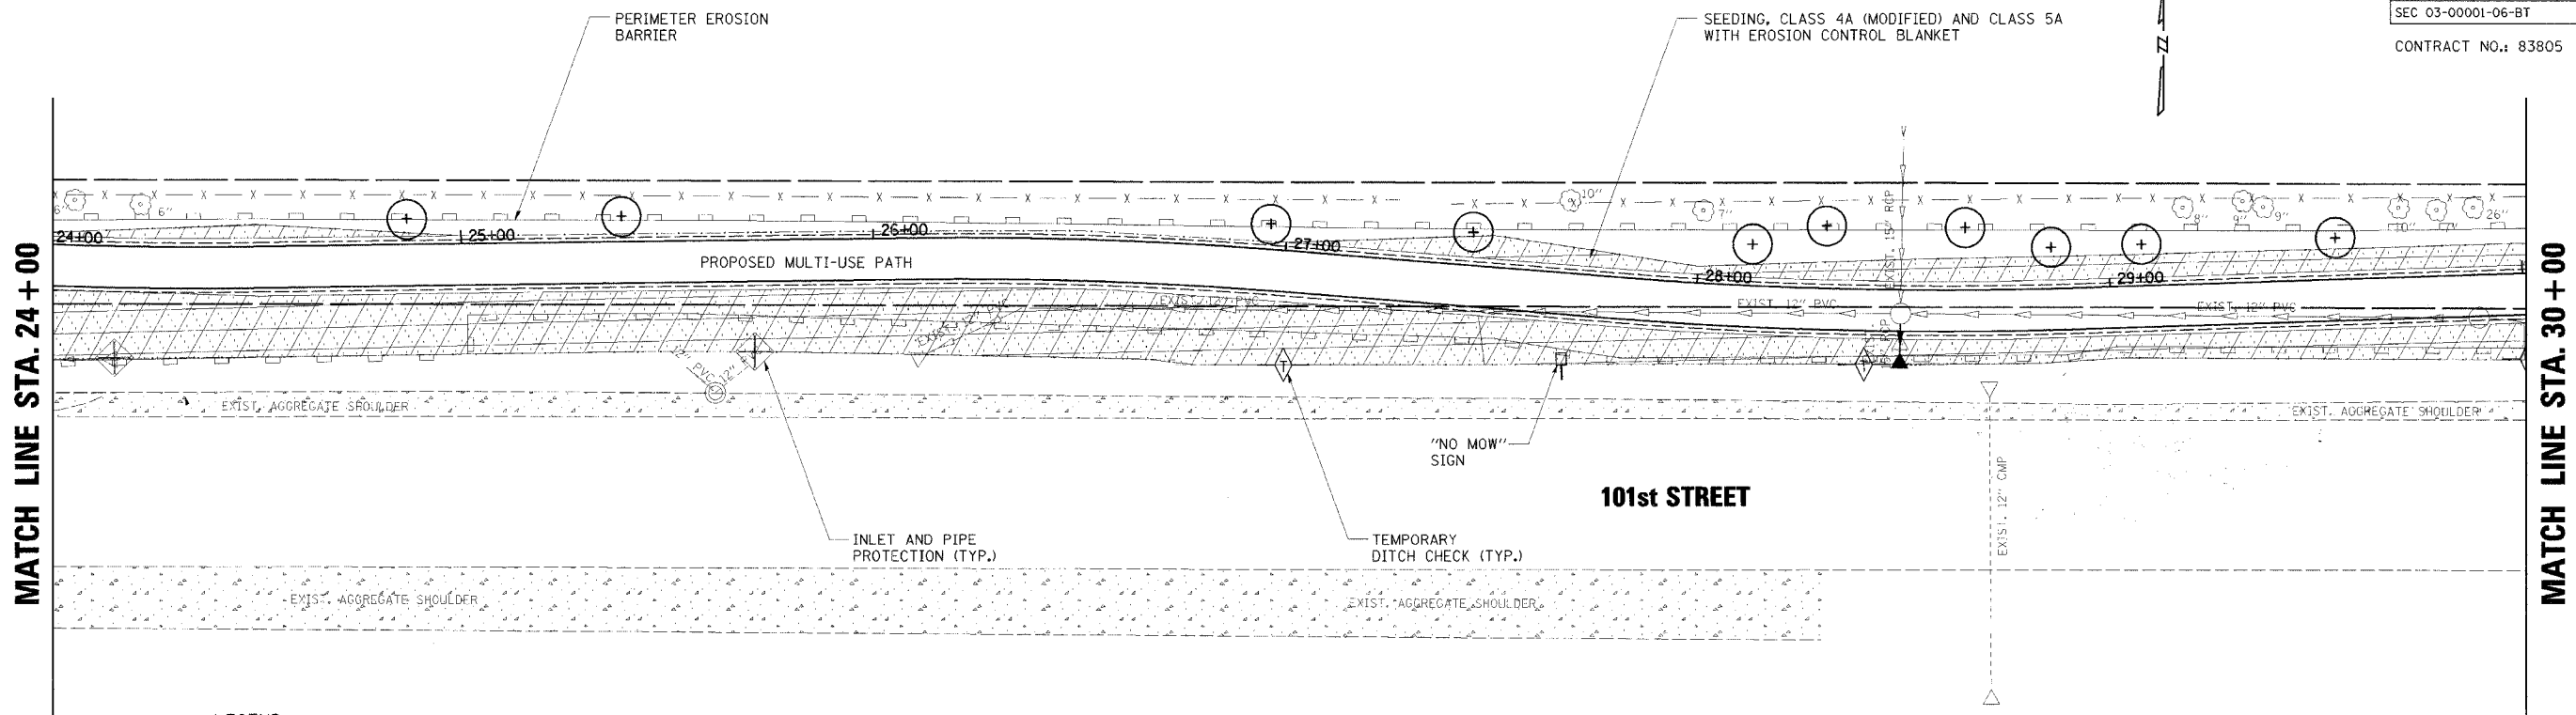



COUNTY HIGHWAY	FISCAL YEAR	TOTAL SHEETS	SHEET NO.
	2005	30	14
SEC 03-00001-06-BT		DUPAGE COUNTY	

CONTRACT NO.: 83805



**LEGEND**

	SEEDING, IDOT CLASS 2
	SEEDING, IDOT CLASS 4A (MODIFIED) AND CLASS 5A

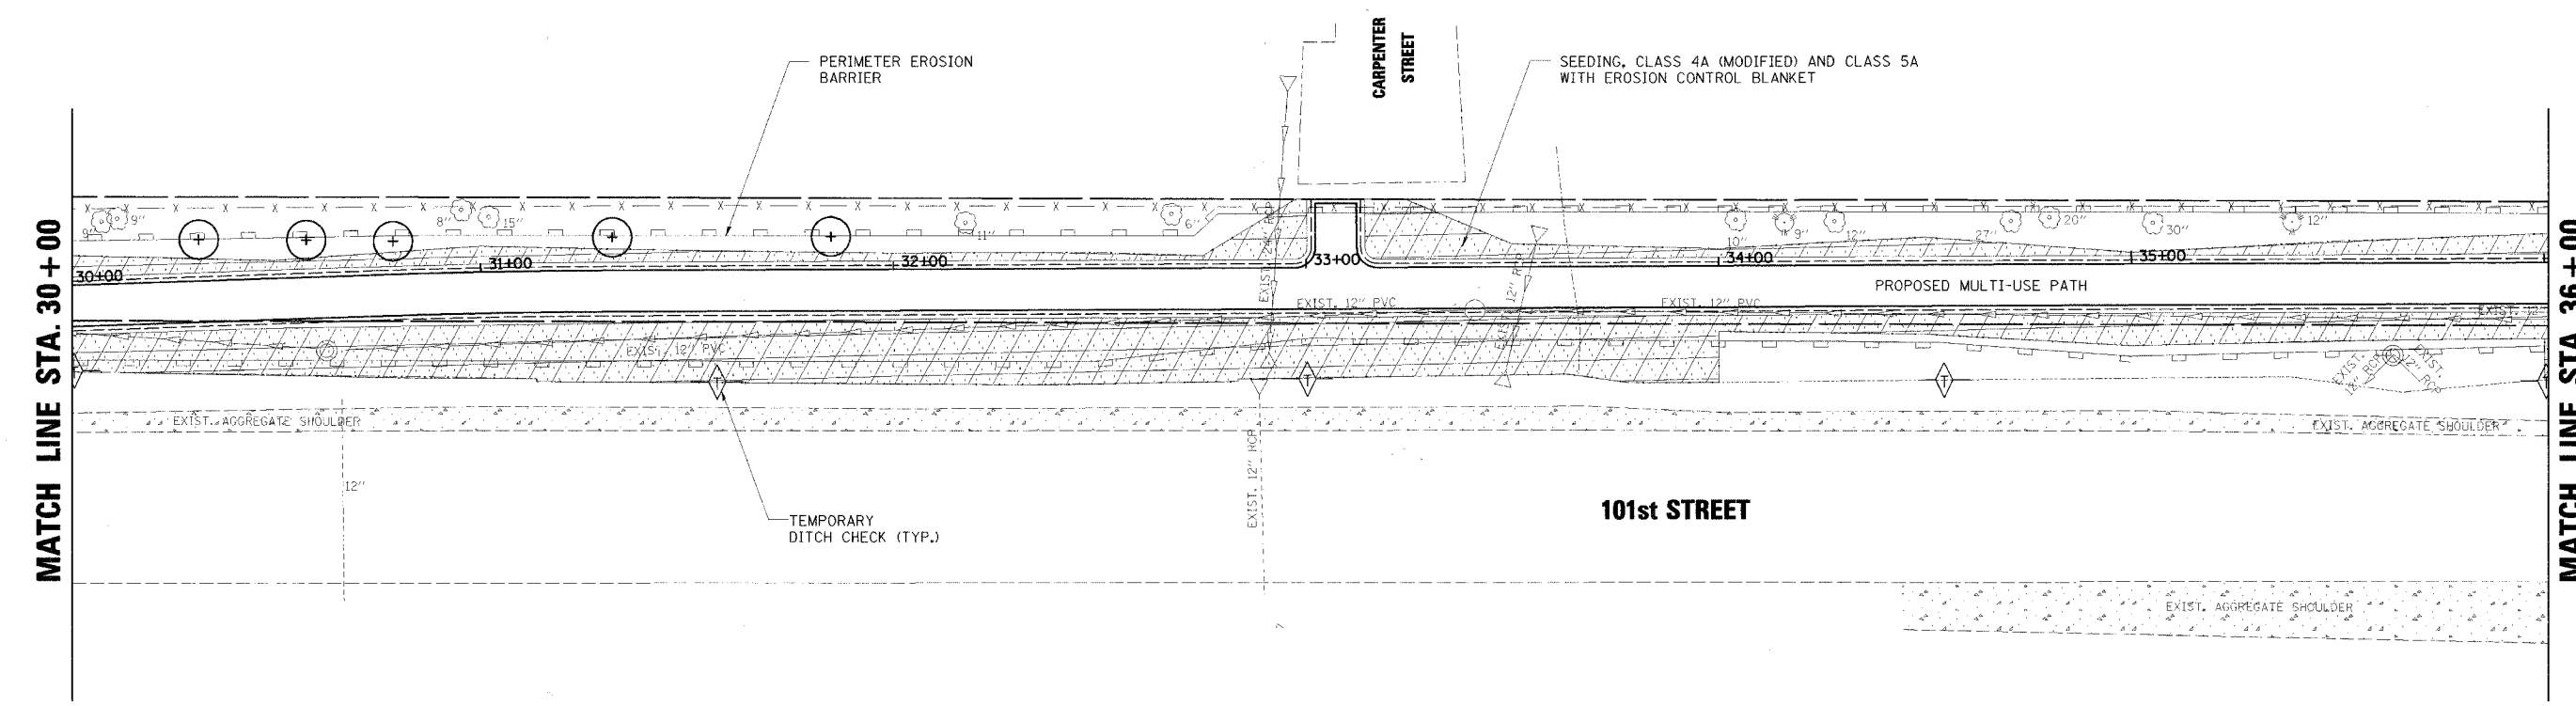

8/10/2005 12:24:46 PM I:\1180000\cadd\Des\gn\1901\_ER03.dgn

NO.	DATE	BY	REVISION

SCALE	1" = 20'
DRAWN BY	JMC DATE
CHECKED BY	MRH DATE
APPROVED BY	DWB DATE



**RJN GROUP, INC.**  
CONSULTING ENGINEERS

PROJECT  
**Southern DuPage County Regional Trail  
101st Street Connector – Waterfall Glen Spur**

TITLE  
**LANDSCAPING AND  
EROSION CONTROL PLAN**

DATE:	JUNE 9, 2005
PROJECT No.:	11-1900-01
SHEET:	