
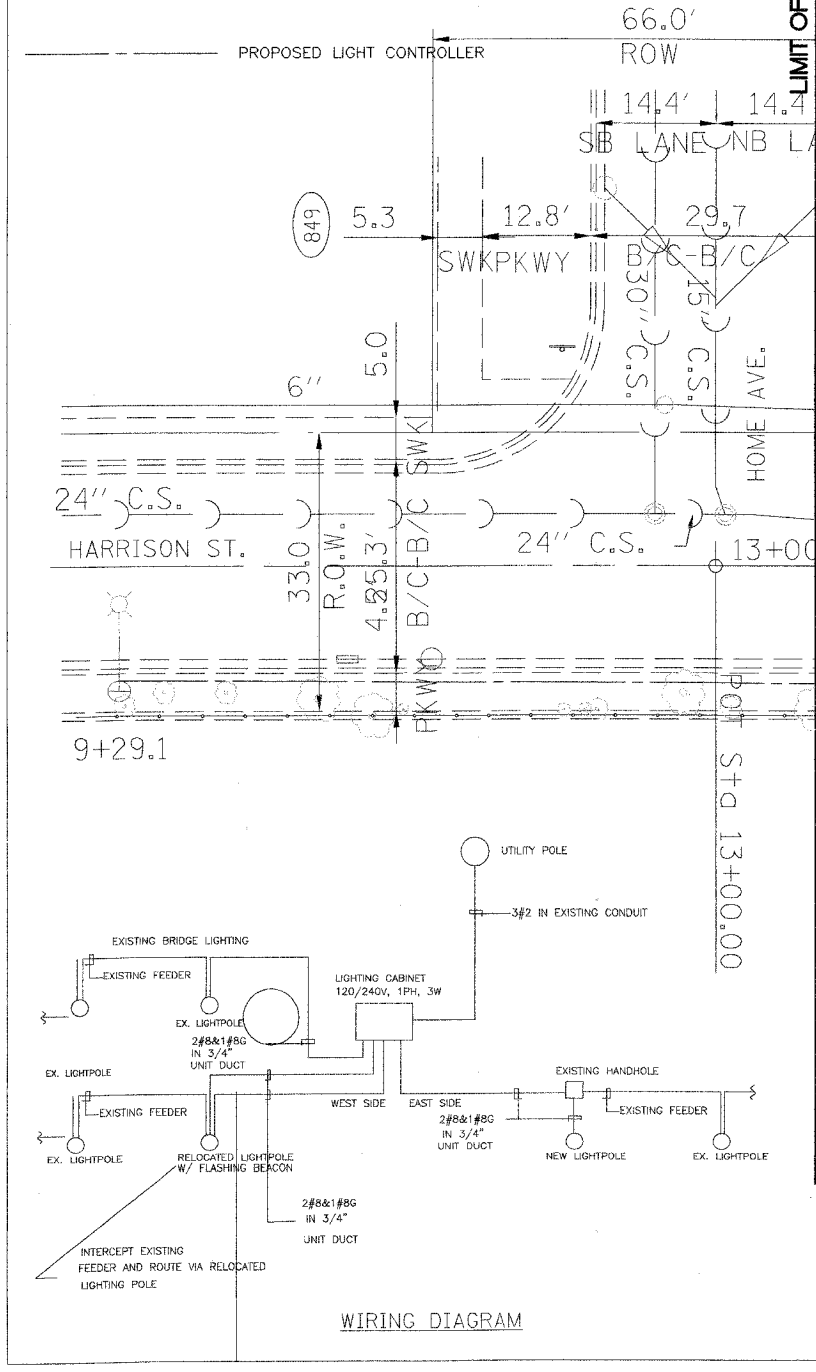
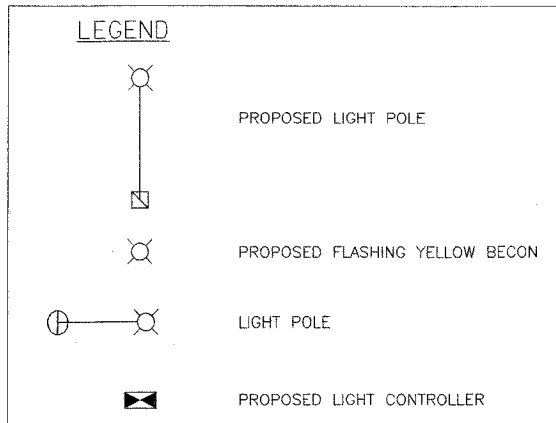
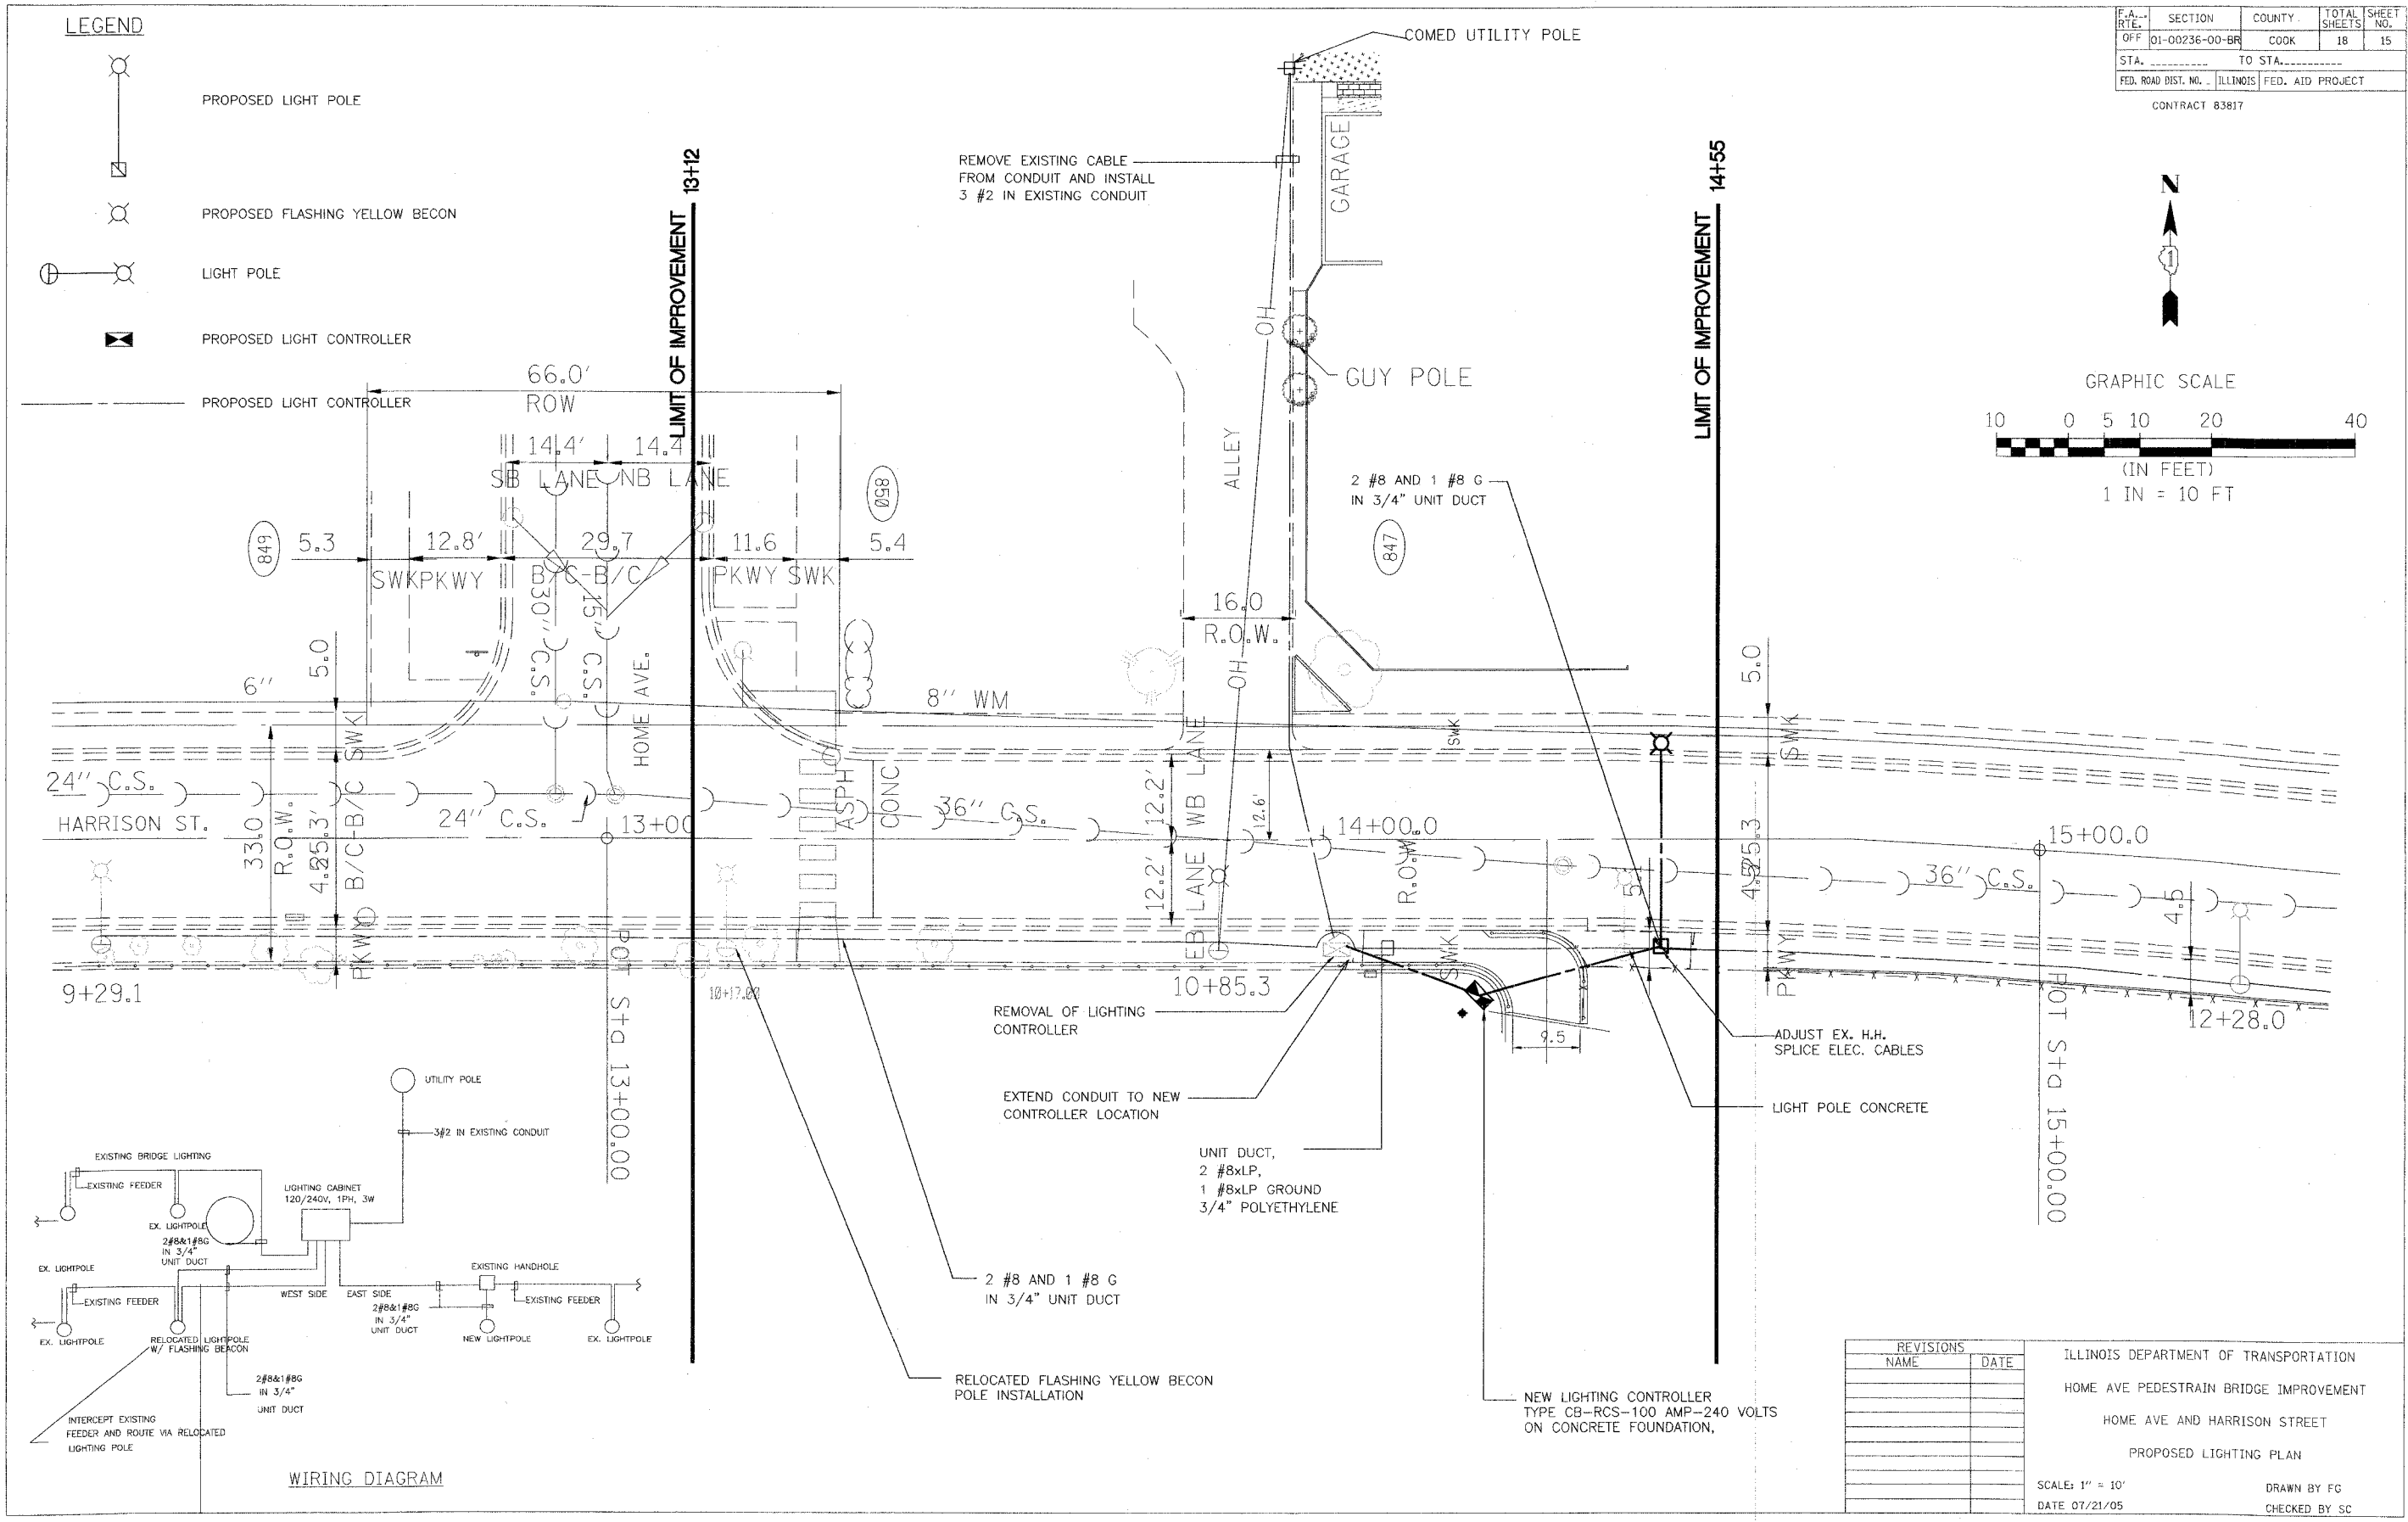
 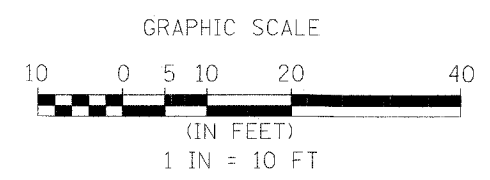


F.A. RTE.	SECTION	COUNTY	TOTAL SHEETS	SHEET NO.
01-00236-00-BR	COOK	18	15	
STA. TO STA.				
FED. ROAD DIST. NO.		ILLINOIS FED. AID PROJECT		

CONTRACT 83817



REVISIONS	
NAME	DATE

ILLINOIS DEPARTMENT OF TRANSPORTATION
 HOME AVE PEDESTRAIN BRIDGE IMPROVEMENT
 HOME AVE AND HARRISON STREET
 PROPOSED LIGHTING PLAN

SCALE: 1" = 10'
 DATE 07/21/05

DRAWN BY FG
 CHECKED BY SC