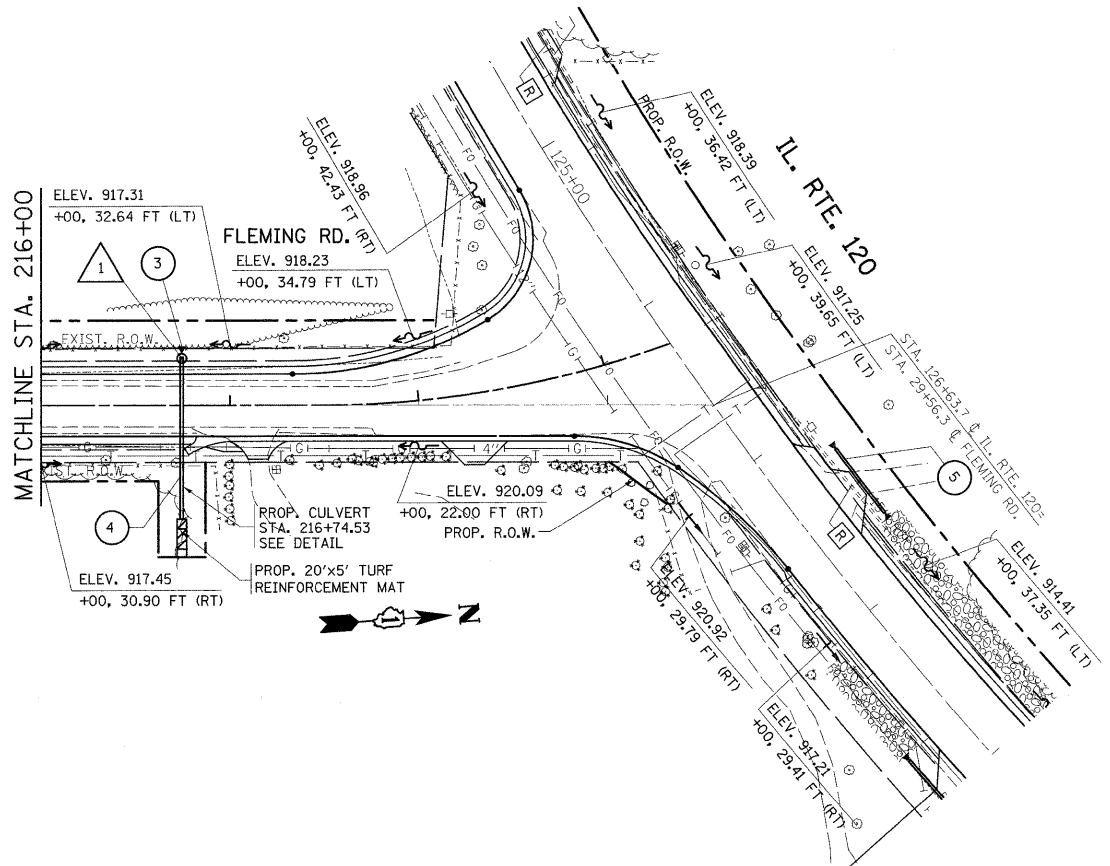


PLAN	REVISIONS	DATE
NO.	BY	
NO.	BY	
FILE	REVISIONS	DATE
NO.	BY	
NO.	BY	
- 3 PRCF END SECTION, 15"
STA. 216+74.50, 32.86 FT. (LT)
INV. = 916.97 (W)
- 4 18" DIA. PIPE CULVERT
CLASS A, T-1, 82.78 FT.
W/1 PRCF END SECTION, 18"
INV. = 914.61
TBF = 10.64 CU. YD.

FLAT SLAB 1
MH, T-A, 4 FT. DIA., TIF CL
STA. 216+74+50, 24.86 FT. (LT)
T.G. = 919.38
INV. = 916.95 (W)
INV. = 914.82 (E)

SYMBOL LEGEND	
	REFERENCE LINE / CENTERLINE AND STATIONING
	RIGHT OF WAY LINE
	DRAINAGE DIVDE (HYDROLOGIC ATLAS)
	INTERPRETED DRAINAGE AREA TO OUTLET/SUB-DIVIDE
	DITCH
	OUTLET
	OVERFLOW
	CULVERT SIZE-TYPE
	SUMMIT
	SWALE

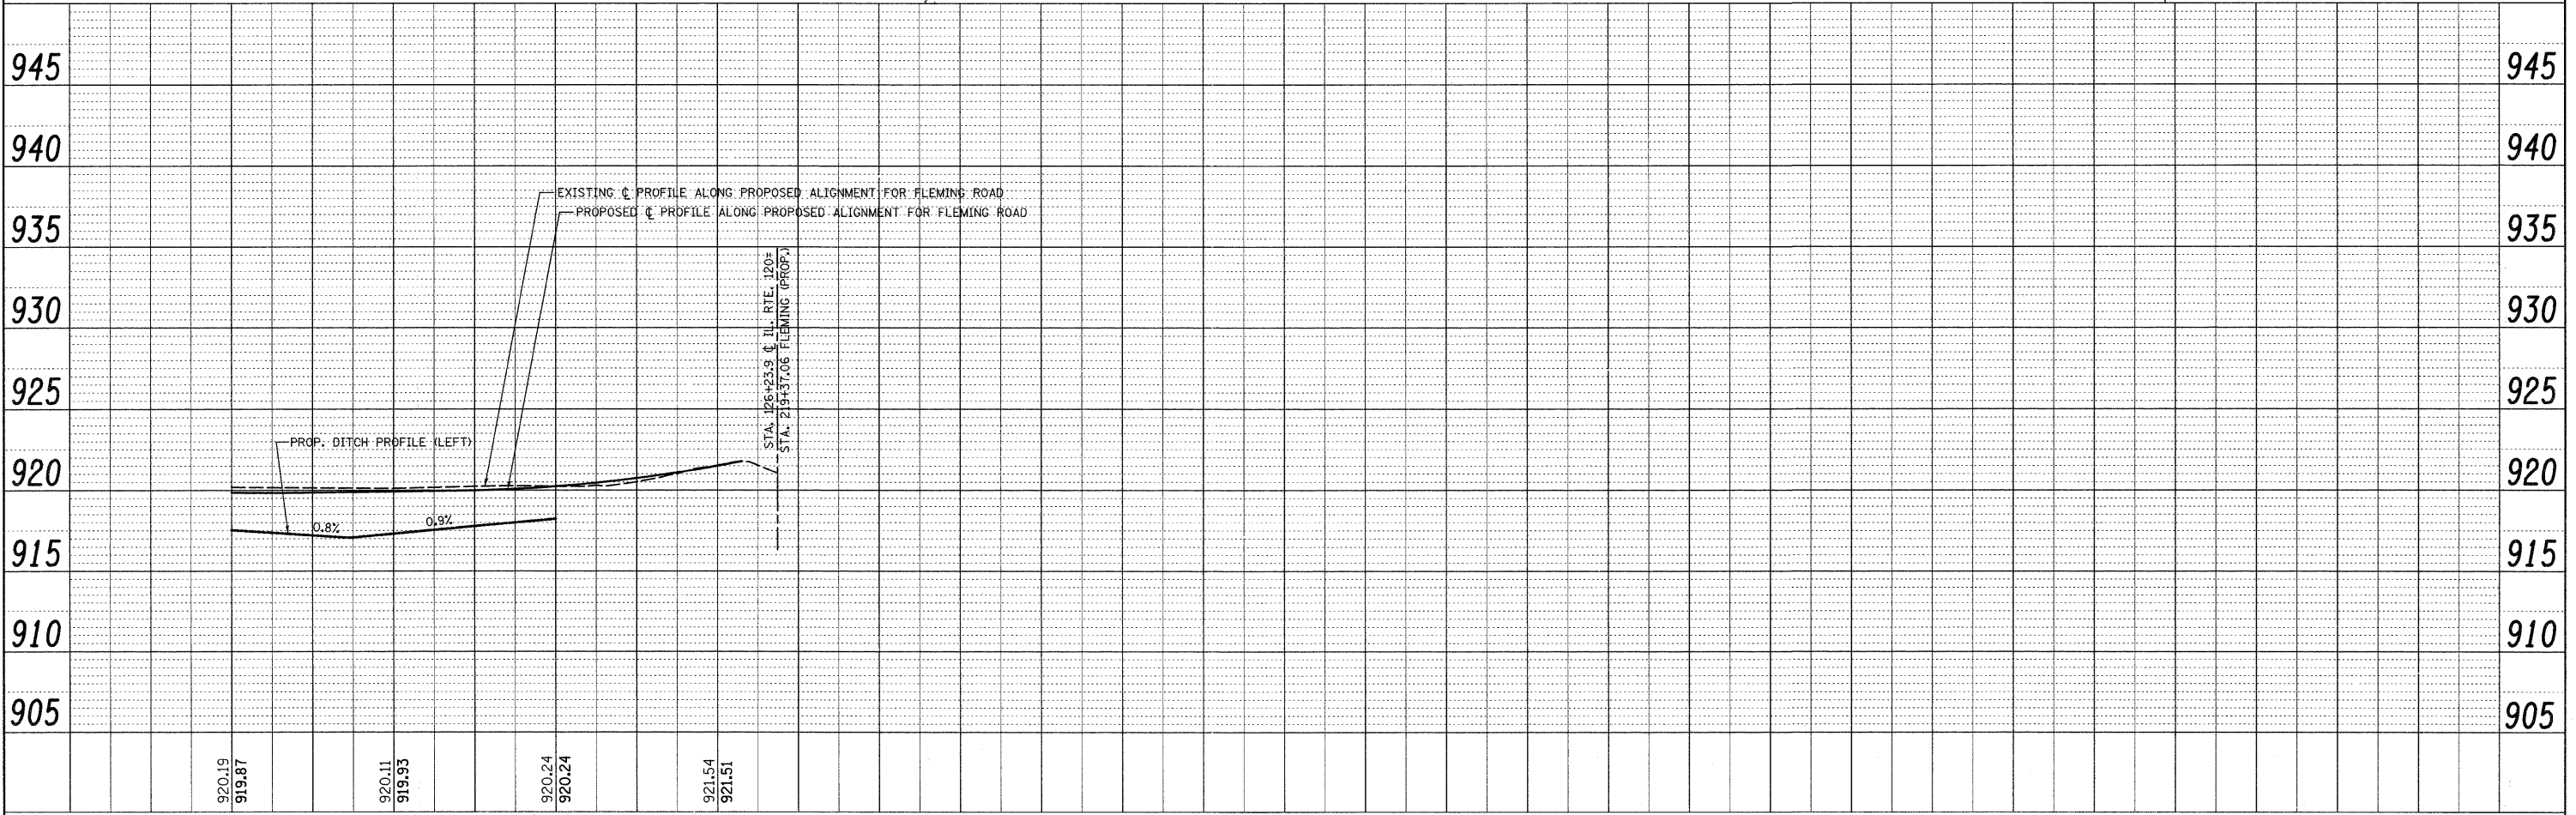

FILE NAME = P113707-sht-drain.dgn	USER NAME = beaverd	DESIGNED -	REVISED -	STATE OF ILLINOIS DEPARTMENT OF TRANSPORTATION	EXISTING AND PROPOSED DRAINAGE PLAN FLEMING RD IL. ROUTE 120			F.A.P. RTE. 333	SECTION 15-N-6	COUNTY MCHENRY	TOTAL SHEETS 67	SHEET NO. 28
PLOT SCALE = 50.0000' / in.	DATE = 9/16/2011	DRAWN -	REVISED -		SCALE: 1"=50'	SHEET NO. OF SHEETS	STA. 216+00 TO STA. 219+37	CONTRACT NO. 60L27				
		CHECKED -	REVISED -		FED. ROAD DIST. NO. ILLINOIS FED. AID PROJECT							
		DATE -	REVISED -									