
 


F.A.P. RTE.	SECTION	COUNTY	TOTAL SHEETS	SHEET NO.
307	130 R-2	DUPAGE, KANE	647	421
STA.	TO STA.			
FED. ROAD DIST. NO.	ILLINOIS	FED. AID PROJECT		

62410

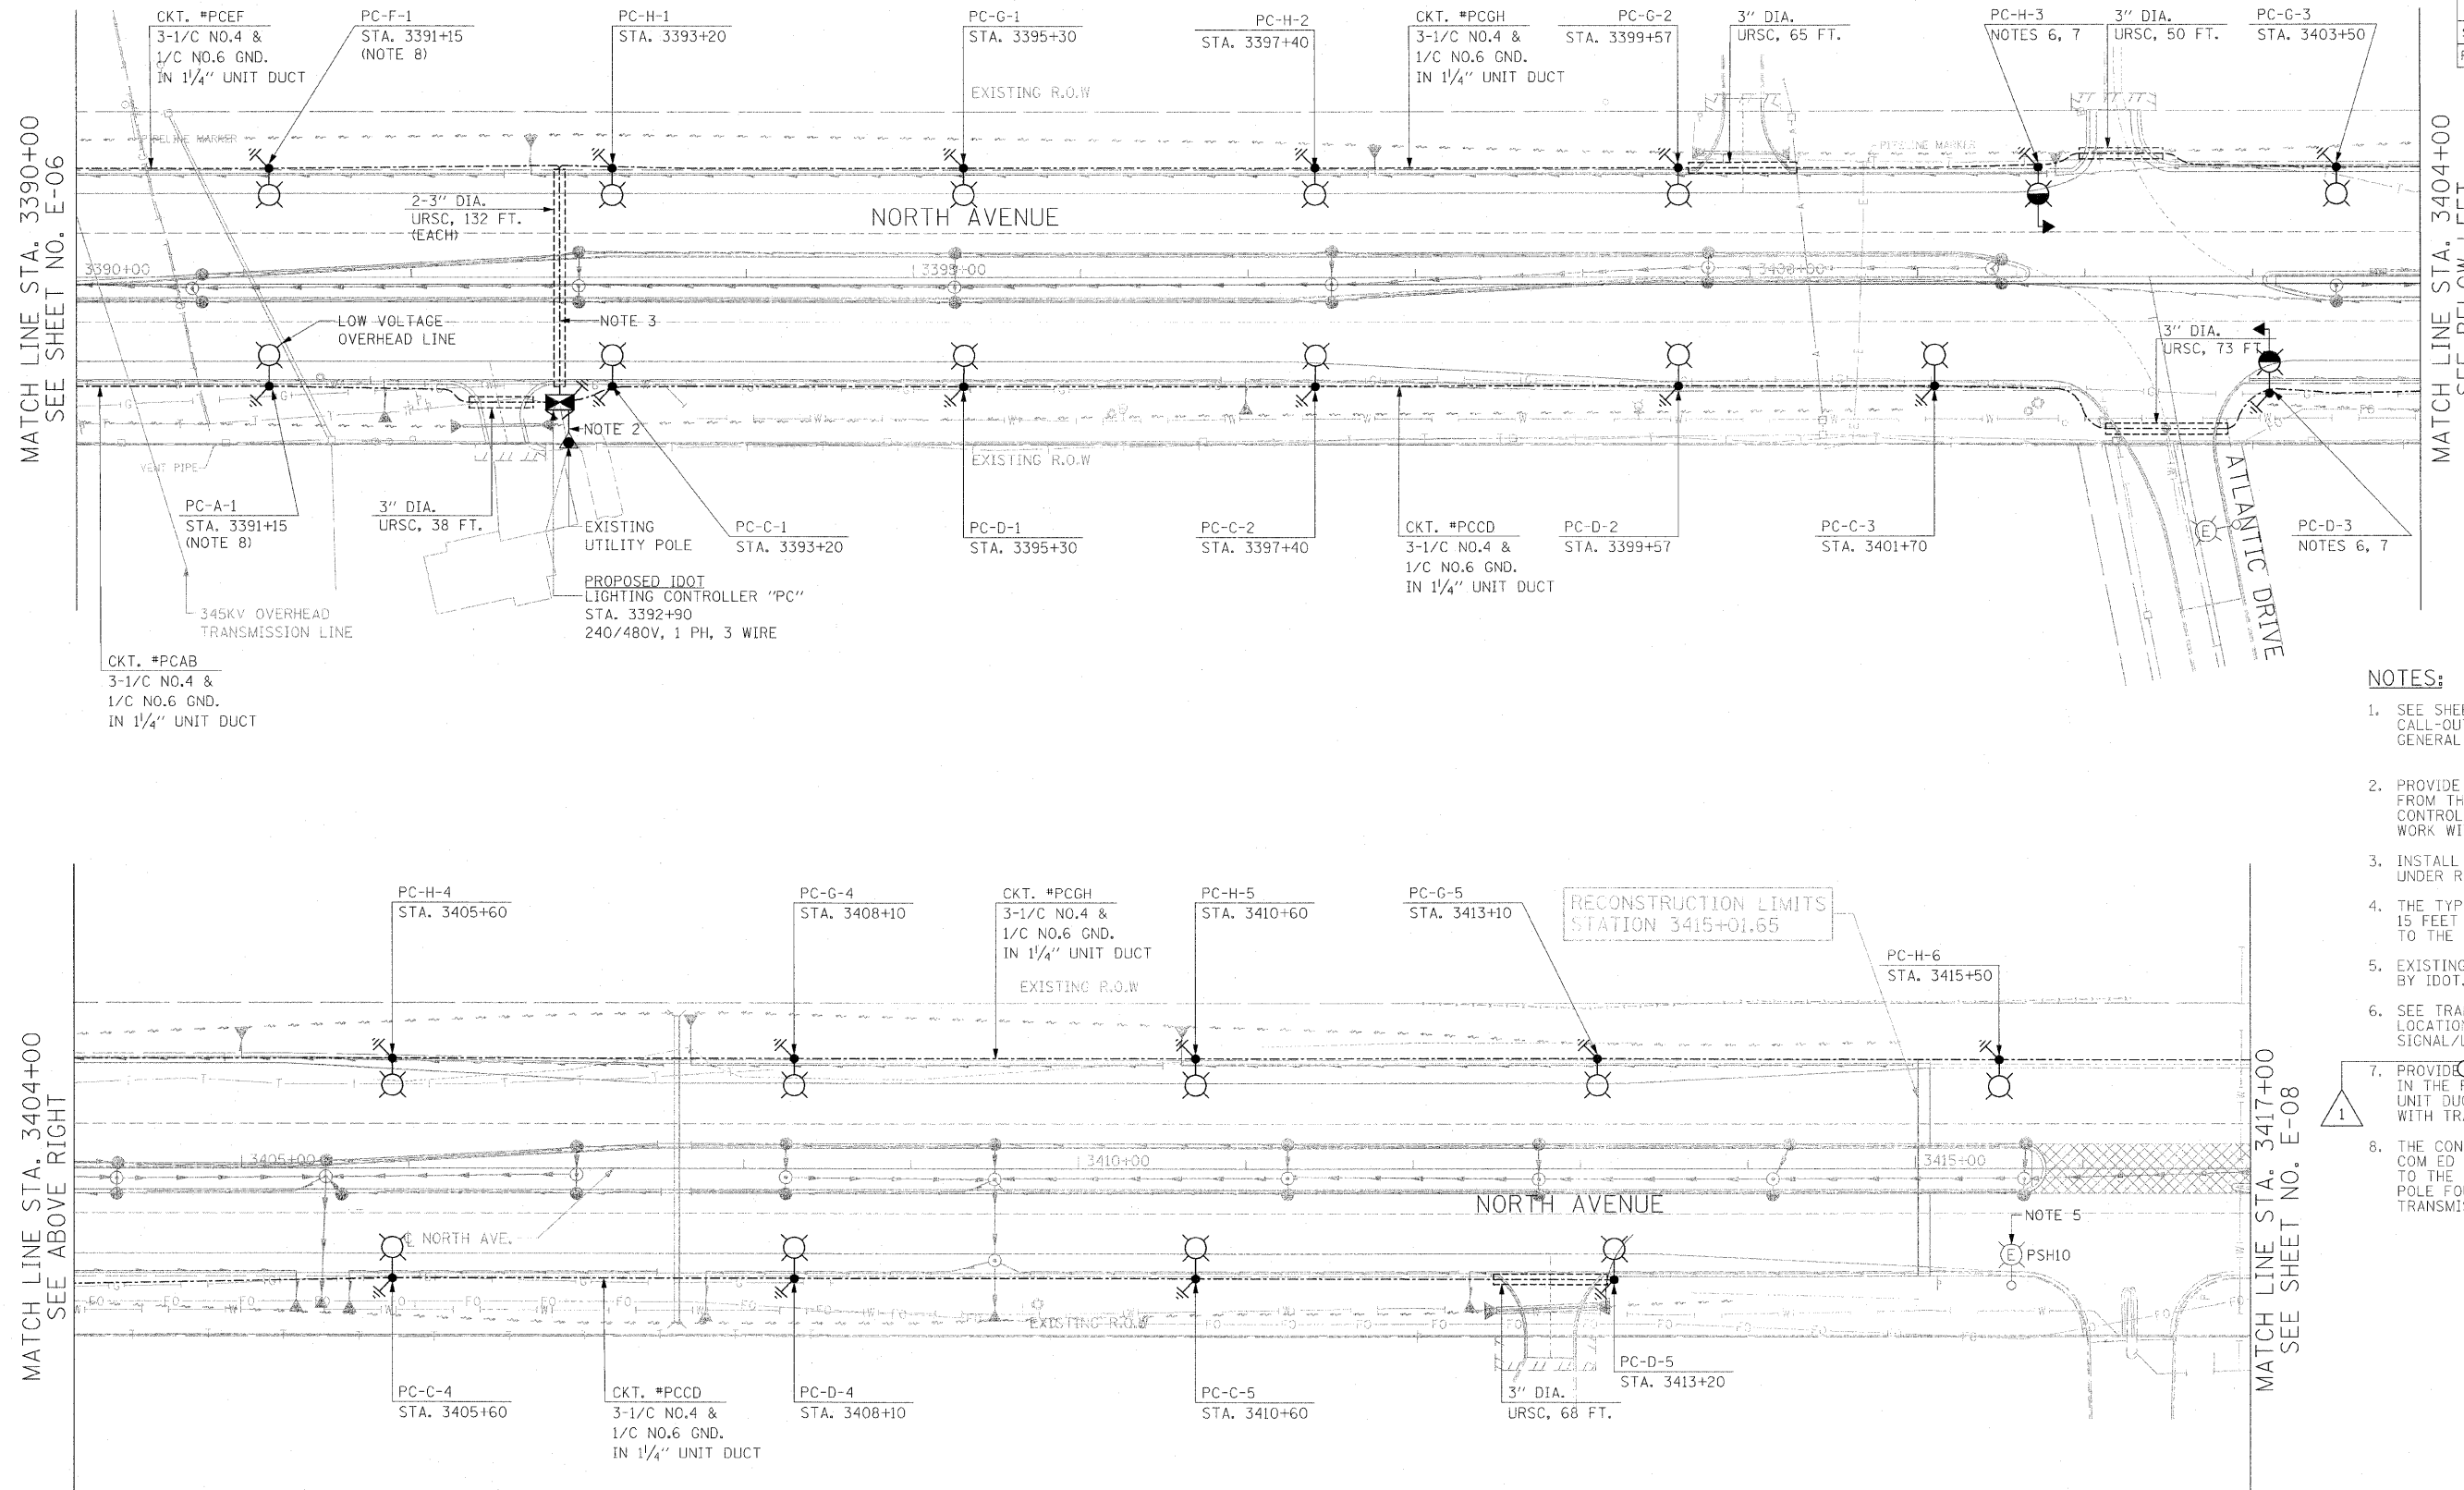

- NOTES:**
- SEE SHEET E-01 FOR ELECTRICAL SYMBOLS, CALL-OUT SAMPLES, ABBREVIATIONS AND GENERAL NOTES.
  - PROVIDE 3" 350 KCMIL TYPE USE IN 4" URSC FROM THE UTILITY POLE TO THE LIGHTING CONTROLLER CABINET. COORDINATE ALL WORK WITH COMED.
  - INSTALL ONE 1/4" UNIT DUCT PER URSC UNDER ROADWAY.
  - THE TYPICAL LIGHT POLE SETBACK SHALL BE 15 FEET FROM THE EDGE OF THE PAVEMENT TO THE FACE OF LIGHT POLE.
  - EXISTING LIGHTING UNIT OWNED AND OPERATED BY IDOT.
  - SEE TRAFFIC SIGNAL PLANS FOR THE EXACT LOCATIONS OF COMBINATION TRAFFIC SIGNAL/LIGHT POLES.
  - PROVIDE 4" PVC CONDUIT SLEEVES IN THE POLE FOUNDATION FOR LIGHTING UNIT DUCTS. COORDINATE ALL WORK WITH TRAFFIC SIGNAL INSTALLATION.
  - THE CONTRACTOR SHALL CONTACT COM ED AND OBTAIN APPROVAL PRIOR TO THE INSTALLATION OF LIGHT POLE FOUNDATIONS NEAR THE TRANSMISSION LINES.



REVISIONS	
NAME	DATE
ADDENDUM NO. 1	12/23/11

ILLINOIS DEPARTMENT OF TRANSPORTATION  
 F.A.P. ROUTE 307 (ILLINOIS ROUTE 64)

**ROADWAY LIGHTING PLAN**  
 STA. 3390+00 TO STA. 3417+00

SCALE: 1" = 50'  
 DATE: NOVEMBER 1, 2011

DRAWN BY: HR  
 CHECKED BY: JPC

E-07