


F.A.P. RTE.	SECTION	COUNTY	TOTAL SHEETS	SHEET NO.
307	130 R-2	DUPAGE, KANE	647	177
STA. 6577+00 TO STA. 6590+00				
FED. ROAD DIST. NO.	ILLINOIS	FED. AID PROJECT		

62410


NOTES:

- SEE DRAINAGE SCHEDULE FOR CULVERT, STRUCTURE, PIPE, AND UNDERDRAIN INFORMATION
- FOR POWIS ROAD INTERSECTION DRAINAGE DETAILS - SEE SHEET DRN-7

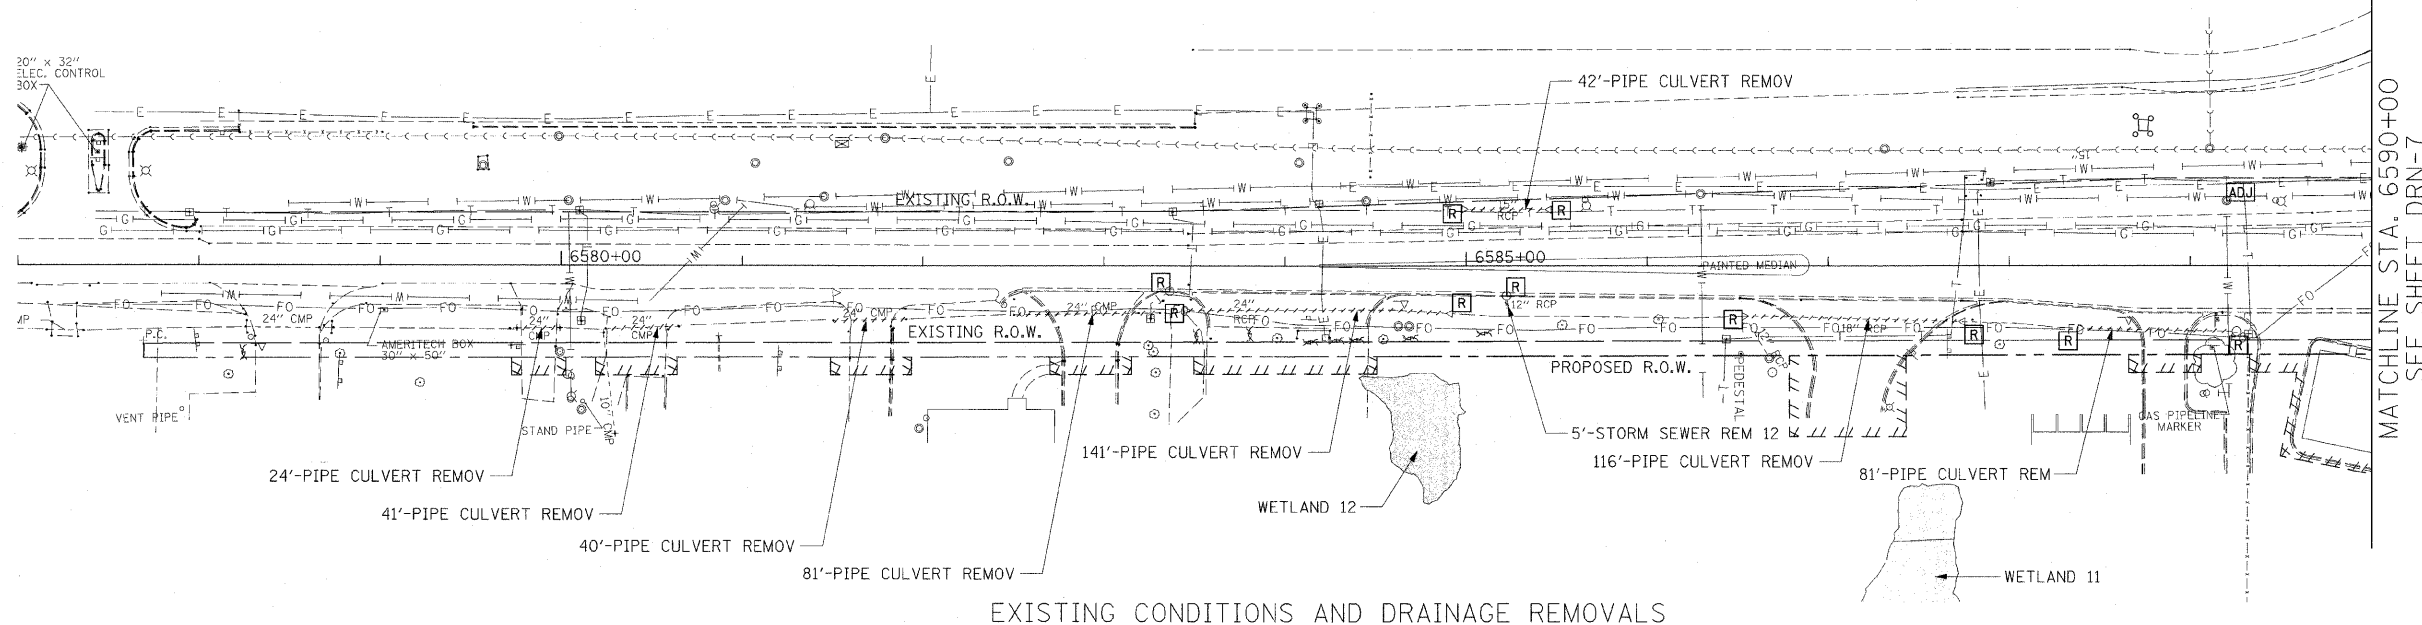

MATCHLINE STA. 6590+00
SEE SHEET DRN-7

EXISTING CONDITIONS AND DRAINAGE REMOVALS

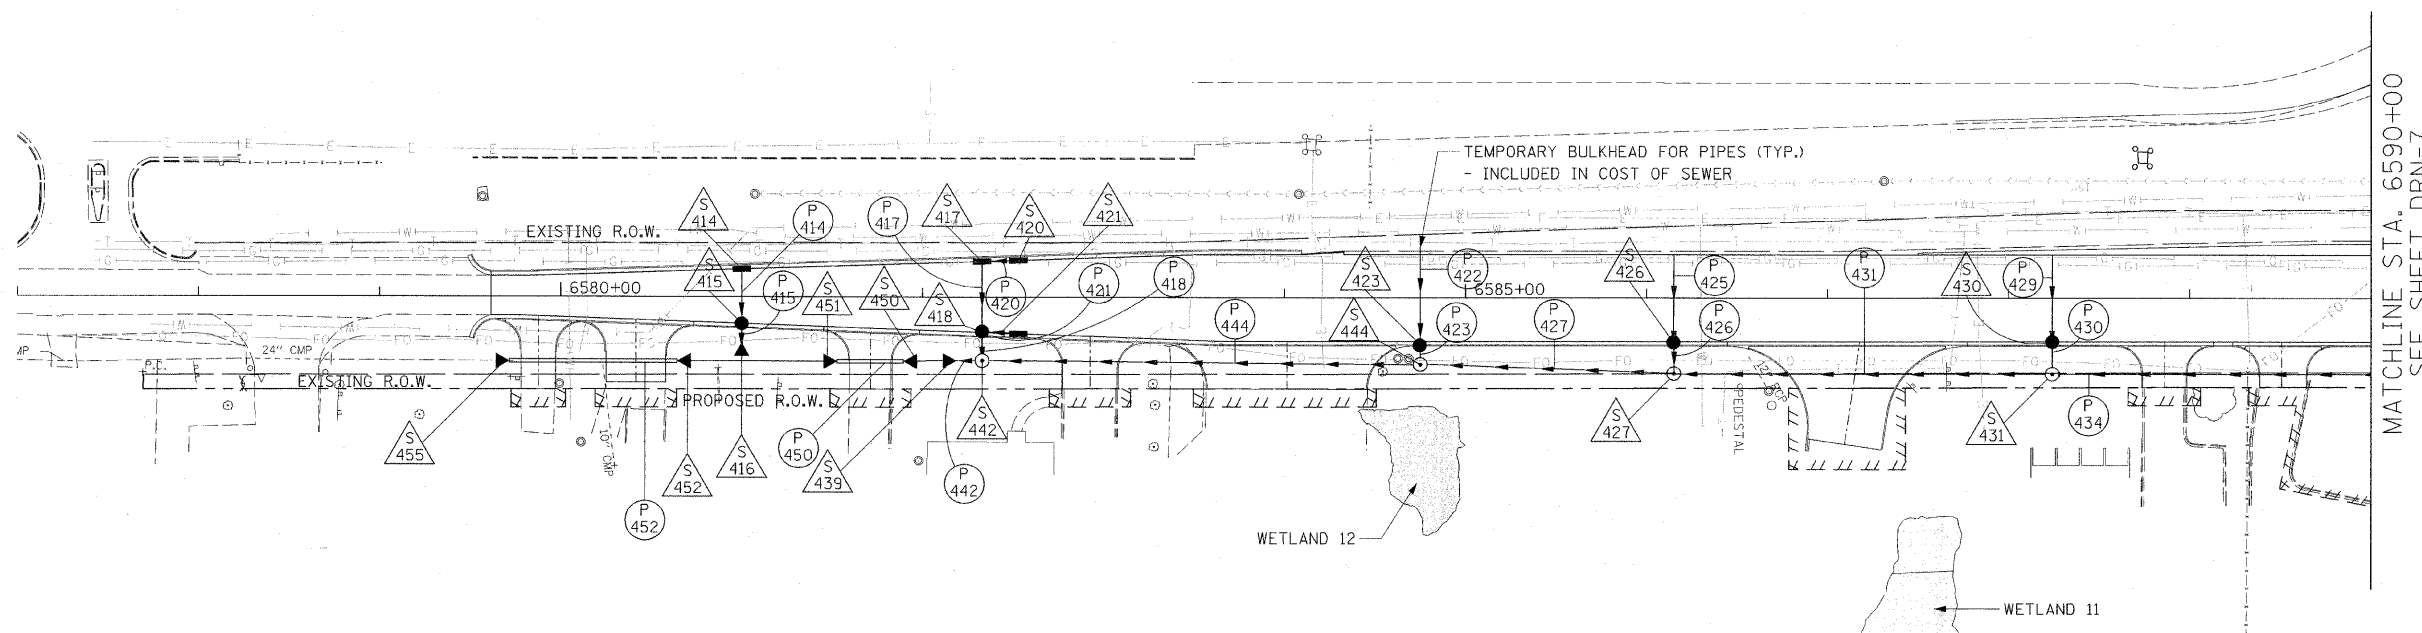

MATCHLINE STA. 6590+00
SEE SHEET DRN-7

PROPOSED DRAINAGE PLAN

50' 0 50' 100'
SCALE IN FEET

REVISIONS	
NAME	DATE

ILLINOIS DEPARTMENT OF TRANSPORTATION
 F.A.P. ROUTE 307 (ILLINOIS ROUTE 64)

DRAINAGE PLAN
 POWIS ROAD
 STA. 6577+00 TO STA. 6590+00

SCALE: VERT: NONE
 HORIZ: 1" = 50'
 DATE: DECEMBER 2, 2011
 DRAWN BY: AFC
 CHECKED BY: EEE



DRN-14