

 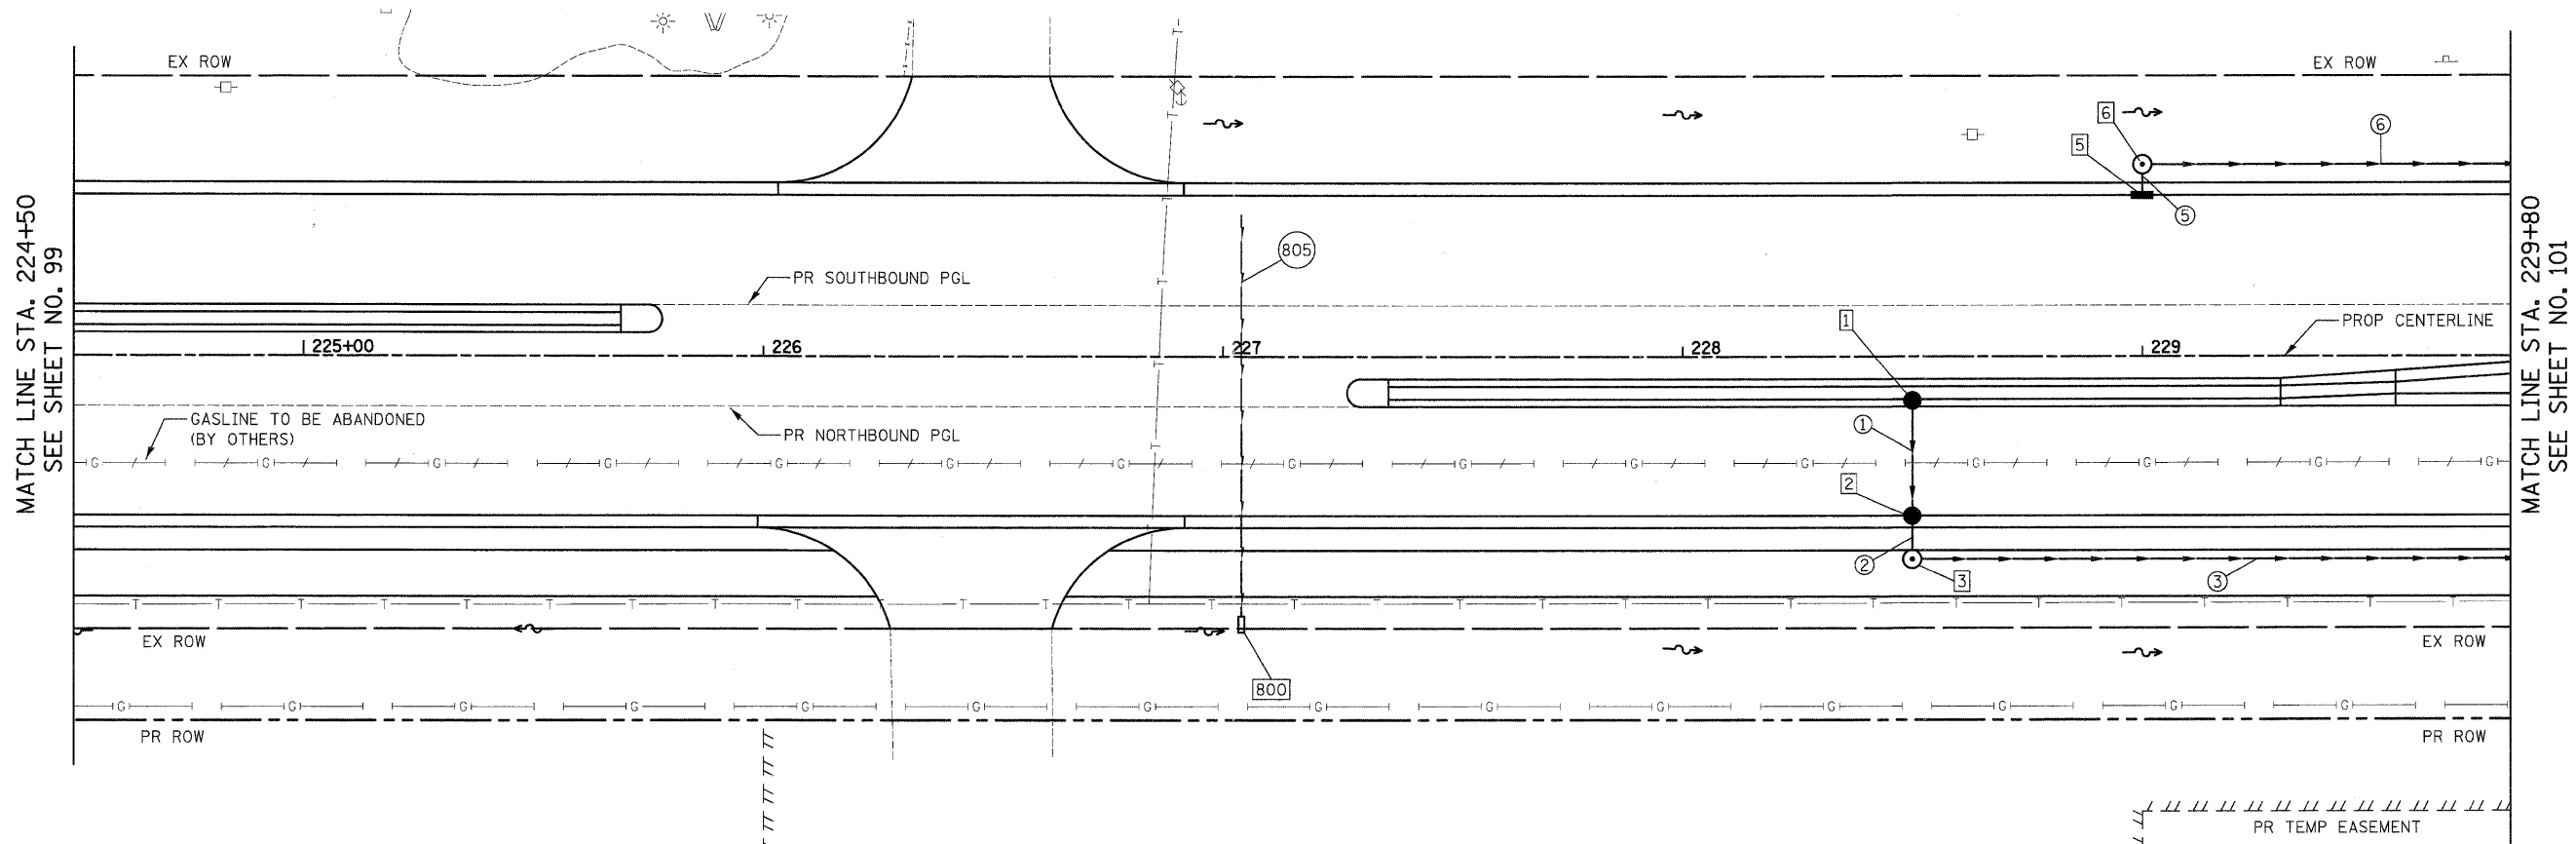


PLAN	DESIGNED	BY	DATE
NOTE BOOK	ALIGNED		
NO.	CHECKED		
	FILE NAME		

PROFILE	DESIGNED	BY	DATE
NOTE BOOK	GRADES		
NO.	CHECKED		
	FILE NAME		

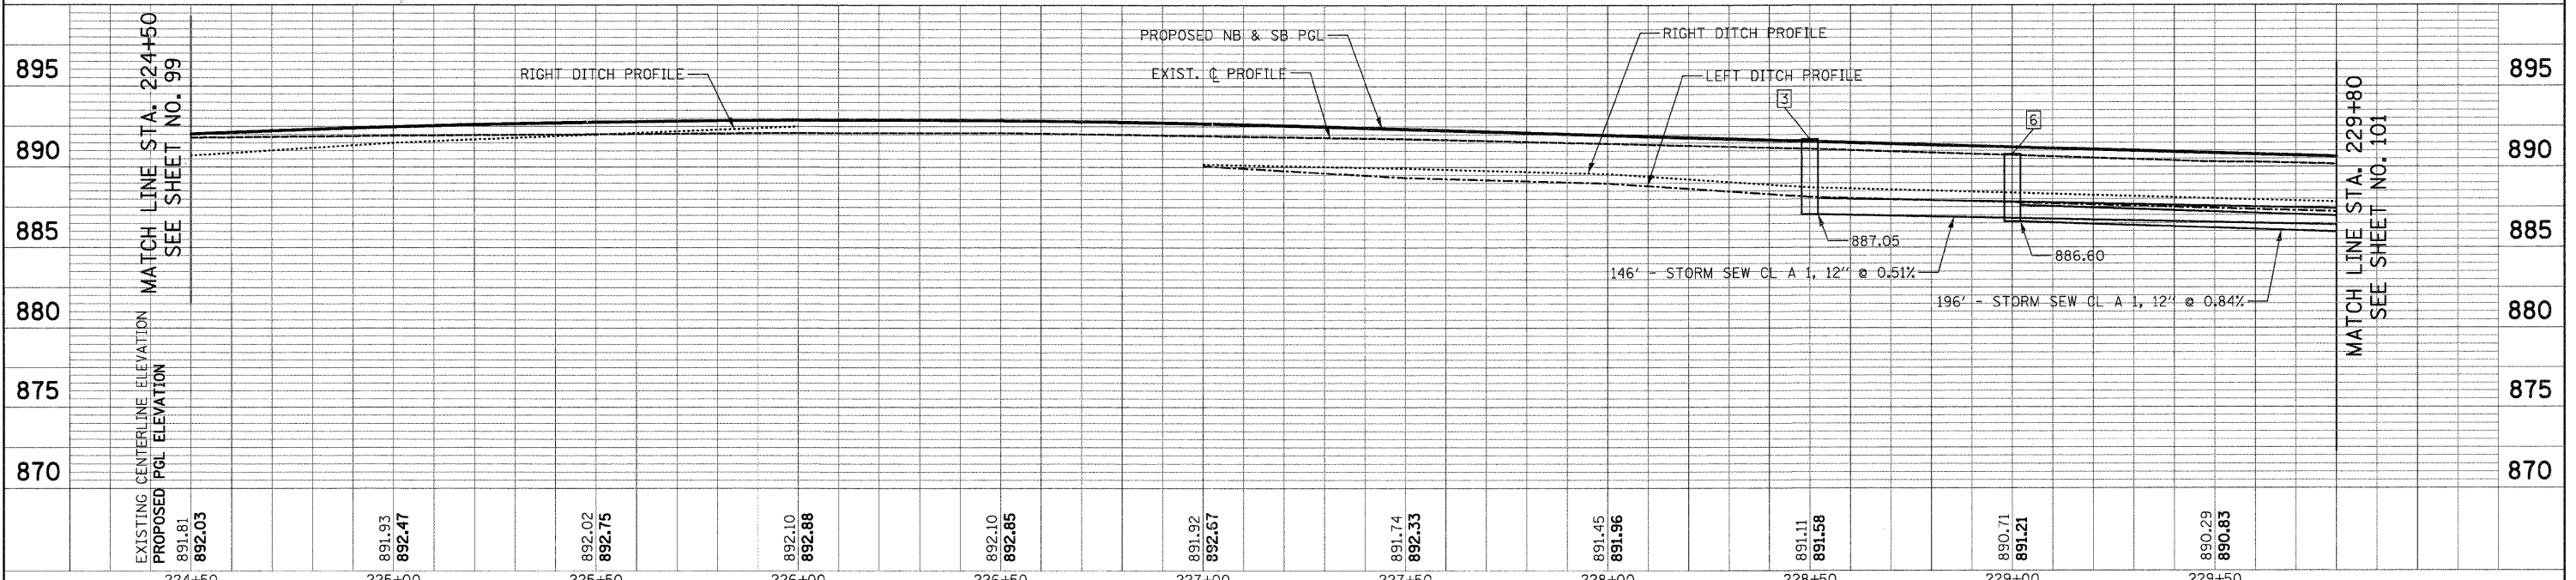

NOTES:
1. SEE SHEET NO. 116 & 117 FOR DRAINAGE CALLOFFS



FILE NAME =	USER NAME = dte	DESIGNED - KWH	REVISED -	STATE OF ILLINOIS DEPARTMENT OF TRANSPORTATION	DRAINAGE AND UTILITY PLAN	F.A.U. RTE.	SECTION	COUNTY	TOTAL SHEETS	SHEET NO.	
Y:\2278 Virginia Klassen\cad\sheet\11-DrainageAndUtilities\2278_D&U_04.dgn		DRAWN - DTE	REVISED -			3887	96-00209-01-PV	McHENRY	271	100	
		CHECKED - GAB	REVISED -			CONTRACT NO. 63553					
		DATE - 10/24/11	REVISED -			FED. ROAD DIST. NO. 1 ILLINOIS FED. AID PROJECT HPP-40640031					