



DRAINAGE STRUCTURE SCHEDULE


NO.	LOCATION		TYPE	RIM ELEV	INVERT ELEVATION		
	STATION	OFFSET			(IN)	(IN)	(OUT)
49	62+00	0.0	DR STR T4 W/2 T20F&G	775.80			771.10
50	62+00	87.0 LT	PRC FLAR END SEC 18	-			770.27
51	64+50	0.0	DR STR T4 W/2 T20F&G	775.05			770.35
52	64+50	87.0 LT	PRC FLAR END SEC 18	-			769.52
53	65+80	0.0	DR STR T4 W/2 T20F&G	774.66			770.22
54	66+44.25	0.0	DR STR T5 W/2 T22F&G	774.55	770.04		769.77
55	67+10	0.0	DR STR T4 W/2 T20F&G	774.67	769.59		769.59
56	67+10	83.3 LT	PRC FLAR END SEC 18	-			768.77
57	69+00	0.0	DR STR T4 W/2 T20F&G	775.60			769.51
58	69+00	90.8 LT	PRC FLAR END SEC 18	-			768.20
59	71+00	0.0	DR STR T4 W/2 T20F&G	776.60			769.03
60	71+00	98.8 LT	PRC FLAR END SEC 18	-			767.60
61	74+50	0.0	DR STR T4 W/2 T20F&G	778.35			766.45
62	74+50	109.1 LT	PRC FLAR END SEC 18	-			764.87

LEGEND

- DRAINAGE STRUCTURES
- STORM SEWERS

UNDERDRAIN CONNECTION NOTE:

CONTRACTOR SHALL CONNECT THE PROPOSED PIPE UNDERDRAIN (OF DIAMETER SPECIFIED) TO THE PROPOSED INLET AT AN ELEVATION OF 2.50' BELOW THE RIM ELEVATION OF THE INLET BEING CONNECTED TO. THIS WORK SHALL BE IN ACCORDANCE WITH SECTION 601 OF THE STATE STANDARDS AND STATE STANDARD 601001-04 AND SHALL BE INCLUDED IN THE PAY ITEM PIPE UNDERDRAINS OF THE DIAMETER SPECIFIED OR THE KIND OF MATERIAL AND DIAMETER SPECIFIED.

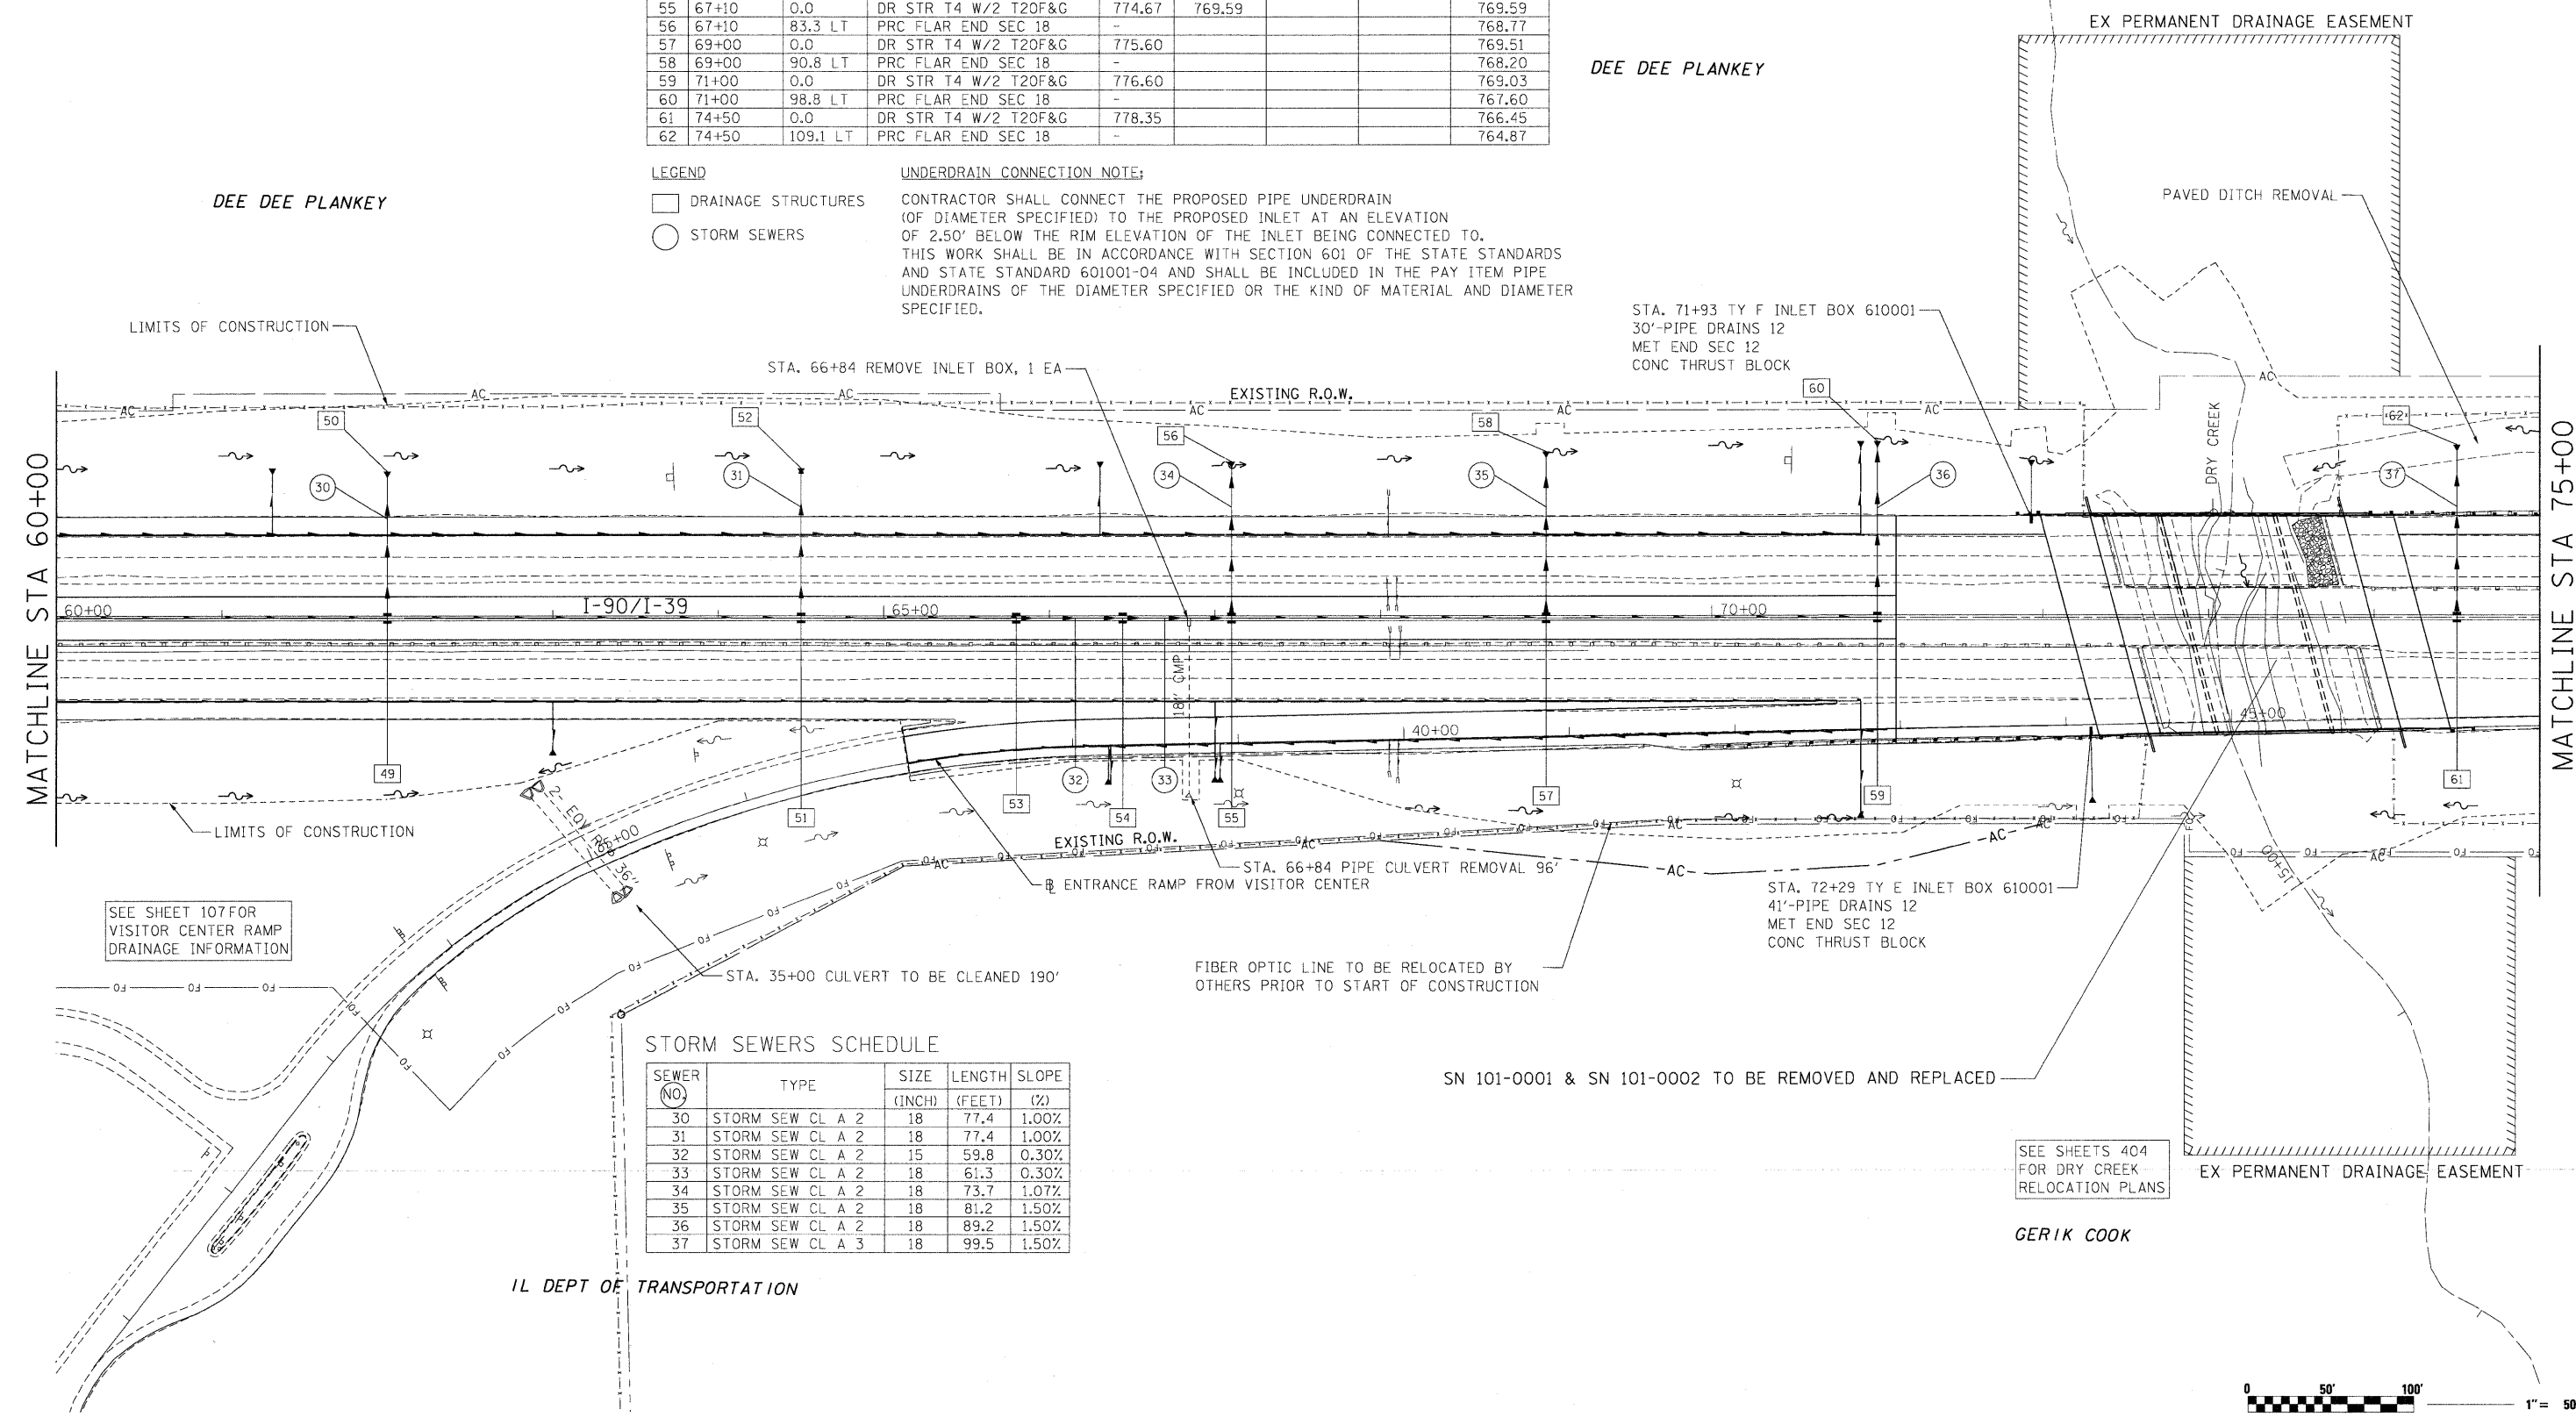

STORM SEWERS SCHEDULE

SEWER NO.	TYPE	SIZE (INCH)	LENGTH (FEET)	SLOPE (%)
31	STORM SEW CL A 2	18	77.4	1.00%
32	STORM SEW CL A 2	15	59.8	0.30%
33	STORM SEW CL A 2	18	61.3	0.30%
34	STORM SEW CL A 2	18	73.7	1.07%
35	STORM SEW CL A 2	18	81.2	1.50%
36	STORM SEW CL A 2	18	89.2	1.50%
37	STORM SEW CL A 3	18	99.5	1.50%

IL DEPT OF TRANSPORTATION

SEE SHEET 107 FOR VISITOR CENTER RAMP DRAINAGE INFORMATION

SEE SHEETS 404 FOR DRY CREEK RELOCATION PLANS

GERIK COOK



USER NAME = USERNAME	DESIGNED - DA	REVISED -
PLLOT SCALE = 50.0000' / IN.	DRAWN - DA	REVISED -
PLLOT DATE = 10/19/2011	CHECKED - AM	REVISED -
	DATE - 10/14/2011	REVISED -

STATE OF ILLINOIS
DEPARTMENT OF TRANSPORTATION

I-90 DRAINAGE PLANS

SCALE: SHEET NO. OF SHEETS STA. 60+00 TO STA. 75+00

F.A.I. RTE.	SECTION	COUNTY	TOTAL SHEETS	SHEET NO.
90	(X2-1)R	WINNEBAGO	510	235
CONTRACT NO. 64C29			ILLINOIS FED. AID PROJECT	