



DRAINAGE STRUCTURE SCHEDULE

NO.	LOCATION		TYPE	RIM ELEV	INVERT ELEVATION			
	STATION	OFFSET			(IN)	(IN)	(IN)	(OUT)
63	77+00	0.0	DR STR T4 W/2 T20F&G	779.60				773.68
64	77+00	89.9 LT	PRC FLAR END SEC 18	-				772.38
65	85+00	0.0	DR STR T4 W/2 T20F&G	779.91				775.20
66	85+00	84.9 LT	PRC FLAR END SEC 18	-				774.71
67	87+00	0.0	DR STR T4 W/2 T20F&G	779.27				775.85
68	88+81.50	0.0	DR STR T4 SPL W/2 T20F&G	778.68	775.00			775.00
68-A	88+88.50	0.0	DR STR T4 SPL W/2 T20F&G	778.68				775.00
99	88+81.50	88.1 RT	PRC FL END S EQ RS 18	-				774.60
100	88+88.50	88.1 RT	PRC FL END S EQ RS 18	-				774.60
101	88+81.5	76.5 LT	PRC FL END S EQ RS 18	-				775.21
102	88+88.50	76.5 LT	PRC FL END S EQ RS 18	-				775.21

STORM SEWERS SCHEDULE

SEWER NO.	TYPE	SIZE (INCH)	LENGTH (FEET)	SLOPE (%)
39	STORM SEW CL A 2	18	75.4	0.60%
40	SS CL A 1 EQRS 18	23 X14	178.0	0.48%
59	SS CL A 1 EQRS 18	23 X14	71.6	0.57%
60	SS CL A 1 EQRS 18	23 X14	71.6	0.57%
61	SS CL A 1 EQRS 18	23 X14	67.0	0.57%
62	SS CL A 1 EQRS 18	23 X14	67.0	0.57%
63	SS CL A 1 EQRS 18	23 X14	3.0	0.00%


LEGEND

- DRAINAGE STRUCTURES
- STORM SEWERS

UNDERDRAIN CONNECTION NOTE:

CONTRACTOR SHALL CONNECT THE PROPOSED PIPE UNDERDRAIN (OF DIAMETER SPECIFIED) TO THE PROPOSED INLET AT AN ELEVATION OF 2.50' BELOW THE RIM ELEVATION OF THE INLET BEING CONNECTED TO. THIS WORK SHALL BE IN ACCORDANCE WITH SECTION 601 OF THE STATE STANDARDS AND STATE STANDARD 601001-04 AND SHALL BE INCLUDED IN THE PAY ITEM PIPE UNDERDRAINS OF THE DIAMETER SPECIFIED OR THE KIND OF MATERIAL AND DIAMETER SPECIFIED.

DEE DEE PLANKEY

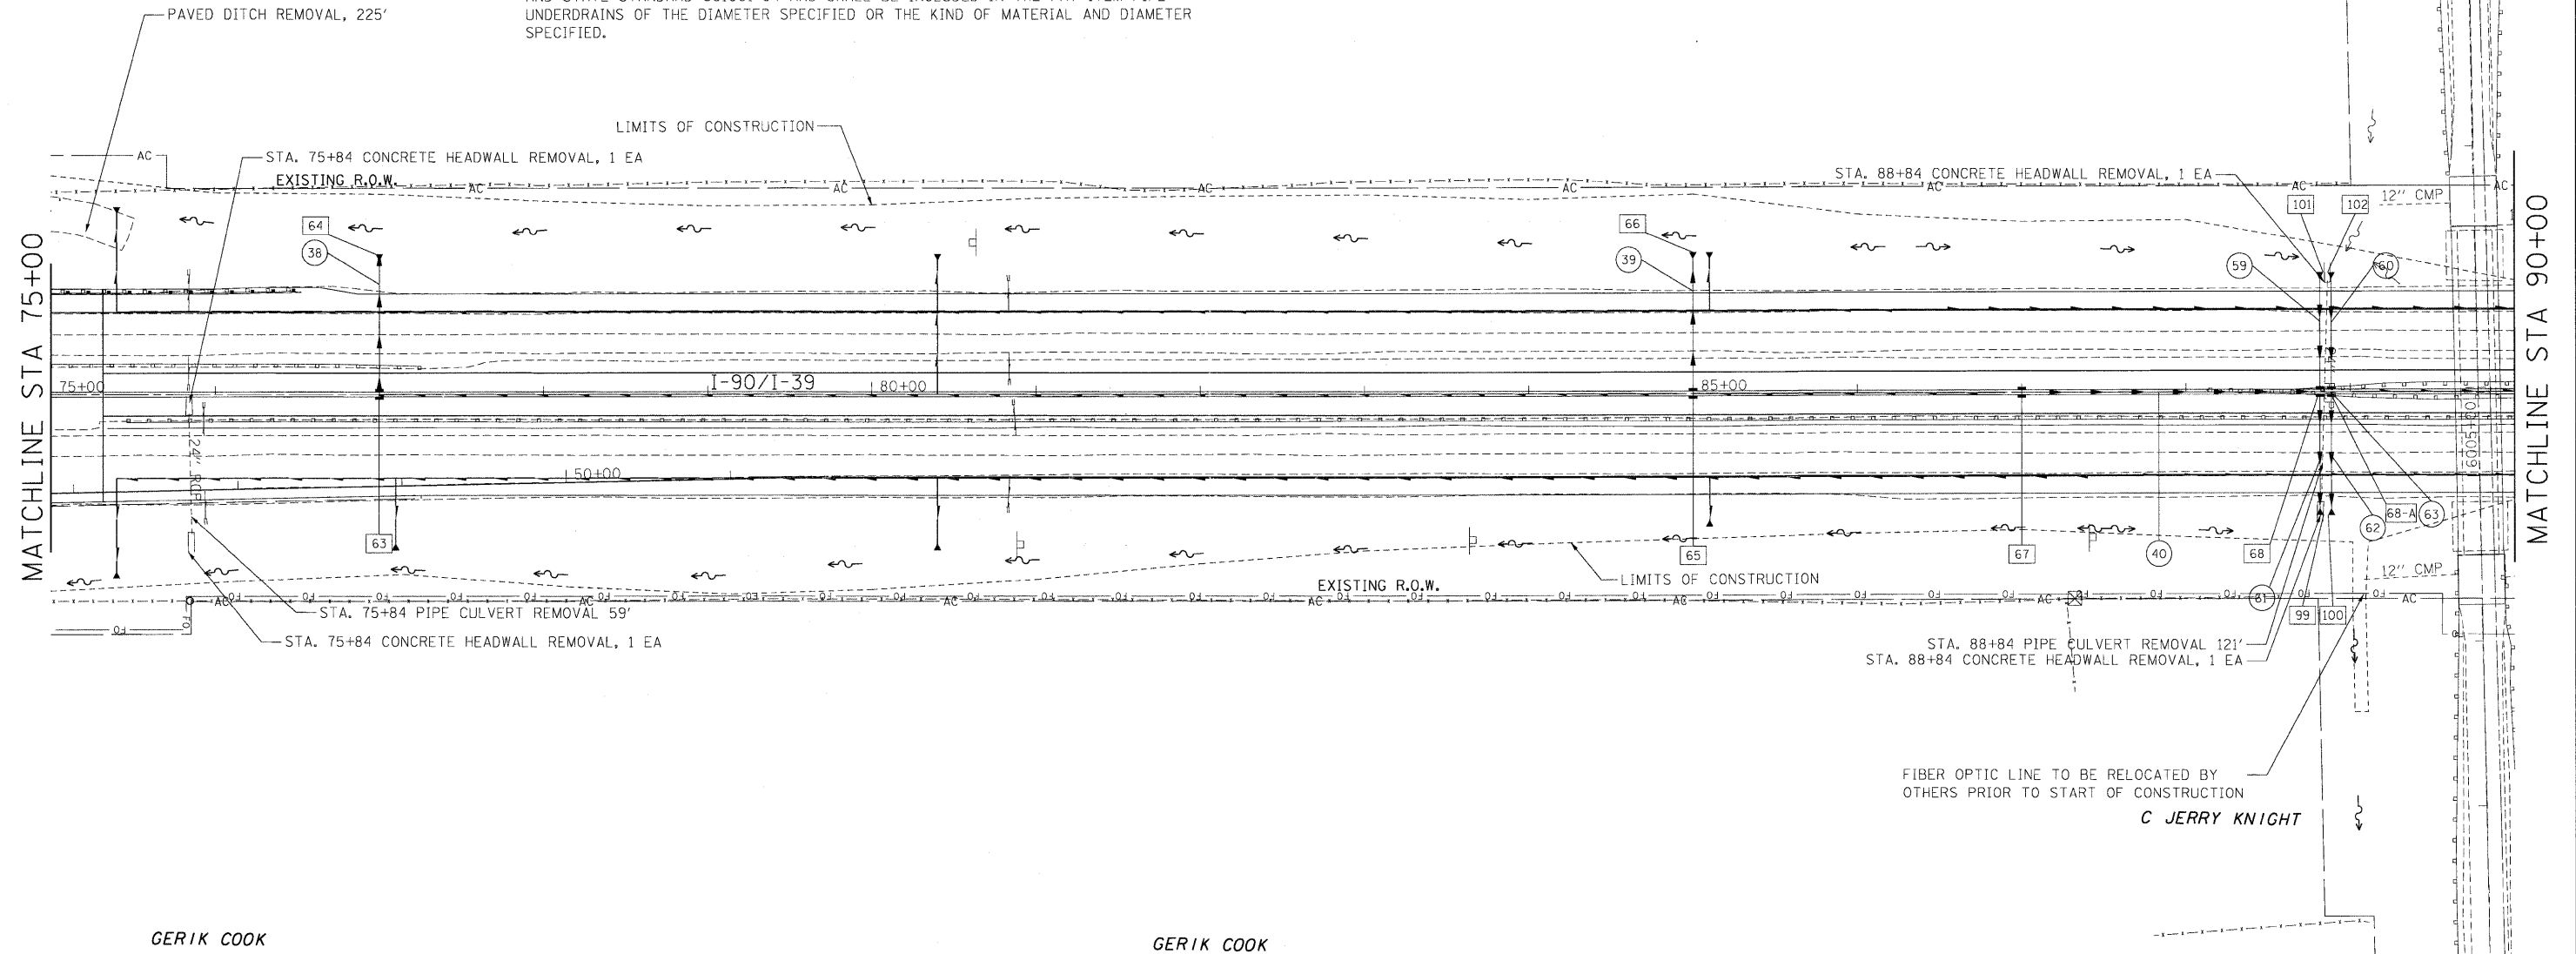

GERIK COOK

GERIK COOK

FIBER OPTIC LINE TO BE RELOCATED BY OTHERS PRIOR TO START OF CONSTRUCTION
C JERRY KNIGHT



USER NAME = .USERNAME.	DESIGNED - DA	REVISED -
PLOT SCALE = 50.0000' / IN.	DRAWN - DA	REVISED -
PLOT DATE = 10/19/2011	CHECKED - AM	REVISED -
	DATE - 10/14/2011	REVISED -

STATE OF ILLINOIS
DEPARTMENT OF TRANSPORTATION

I-90 DRAINAGE PLANS

SCALE: SHEET NO. OF SHEETS STA. 75+00 TO STA. 90+00

F.A.I. RTE.	SECTION	COUNTY	TOTAL SHEETS	SHEET NO.
90	(X2-1R)	WINNEBAGO	510	236
CONTRACT NO. 64C29			ILLINOIS FED. AID PROJECT	