



DRAINAGE STRUCTURE SCHEDULE

NO.	LOCATION		TYPE	RIM ELEV	INVERT ELEVATION		
	STATION	OFFSET			(IN)	(IN)	(OUT)
69	90+35	0.0	DR STR T4 W/2 T2OF&G	778.20			773.76
70	91+86	0.0	DR STR T4 W/2 T2OF&G	777.71	773.27		773.27
71	92+51	0.0	DR STR T5 W/2 T2F&G	777.60	773.06		772.79
72	93+16	0.0	DR STR T4 W/2 T2OF&G	777.71	773.01		773.01
73	93+16	78.3 LT	PRC FLAR END SEC 18	-			772.71
74	95+25	0.0	DR STR T4 W/2 T2OF&G	778.36			773.31
75	95+25	84.7 LT	PRC FLAR END SEC 18	-			772.17
76	96+90	0.0	DR STR T4 W/2 T2OF&G	780.70			774.35
77	96+90	99.1 LT	PRC FLAR END SEC 18	-			773.16
78	98+86	0.0	DR STR T4 W/2 T2OF&G	779.48			774.82
79	98+86	82.8 LT	PRC FLAR END SEC 18	-			774.59
80	101+23	0.0	DR STR T4 W/2 T2OF&G	780.21			775.54
81	101+23	82.8 LT	PRC FLAR END SEC 18	-			775.31
82	103+60	0.0	DR STR T4 W/2 T2OF&G	780.95			776.26
83	103+60	83.0 LT	PRC FLAR END SEC 18	-			776.03

STORM SEWERS SCHEDULE

SEWER NO.	TYPE	SIZE	LENGTH	SLOPE
		(INCH)	(FEET)	(%)
41	STORM SEW CL A 2	15	148.0	0.30%
42	STORM SEW CL A 2	15	61.0	0.30%
43	STORM SEW CL A 2	18	61.1	0.31%
44	STORM SEW CL A 2	18	68.7	0.40%
45	STORM SEW CL A 2	18	75.1	1.40%
46	STORM SEW CL A 2	18	89.5	1.25%
47	STORM SEW CL A 2	18	73.2	0.30%
48	STORM SEW CL A 2	18	73.3	0.30%
49	STORM SEW CL A 2	18	73.4	0.30%


JIM HEIDENREICH

LEGEND

- DRAINAGE STRUCTURES
- STORM SEWERS

UNDERDRAIN CONNECTION NOTE:

CONTRACTOR SHALL CONNECT THE PROPOSED PIPE UNDERDRAIN (OF DIAMETER SPECIFIED) TO THE PROPOSED INLET AT AN ELEVATION OF 2.50' BELOW THE RIM ELEVATION OF THE INLET BEING CONNECTED TO. THIS WORK SHALL BE IN ACCORDANCE WITH SECTION 601 OF THE STATE STANDARDS AND STATE STANDARD 601001-04 AND SHALL BE INCLUDED IN THE PAY ITEM PIPE UNDERDRAINS OF THE DIAMETER SPECIFIED OR THE KIND OF MATERIAL AND DIAMETER SPECIFIED.

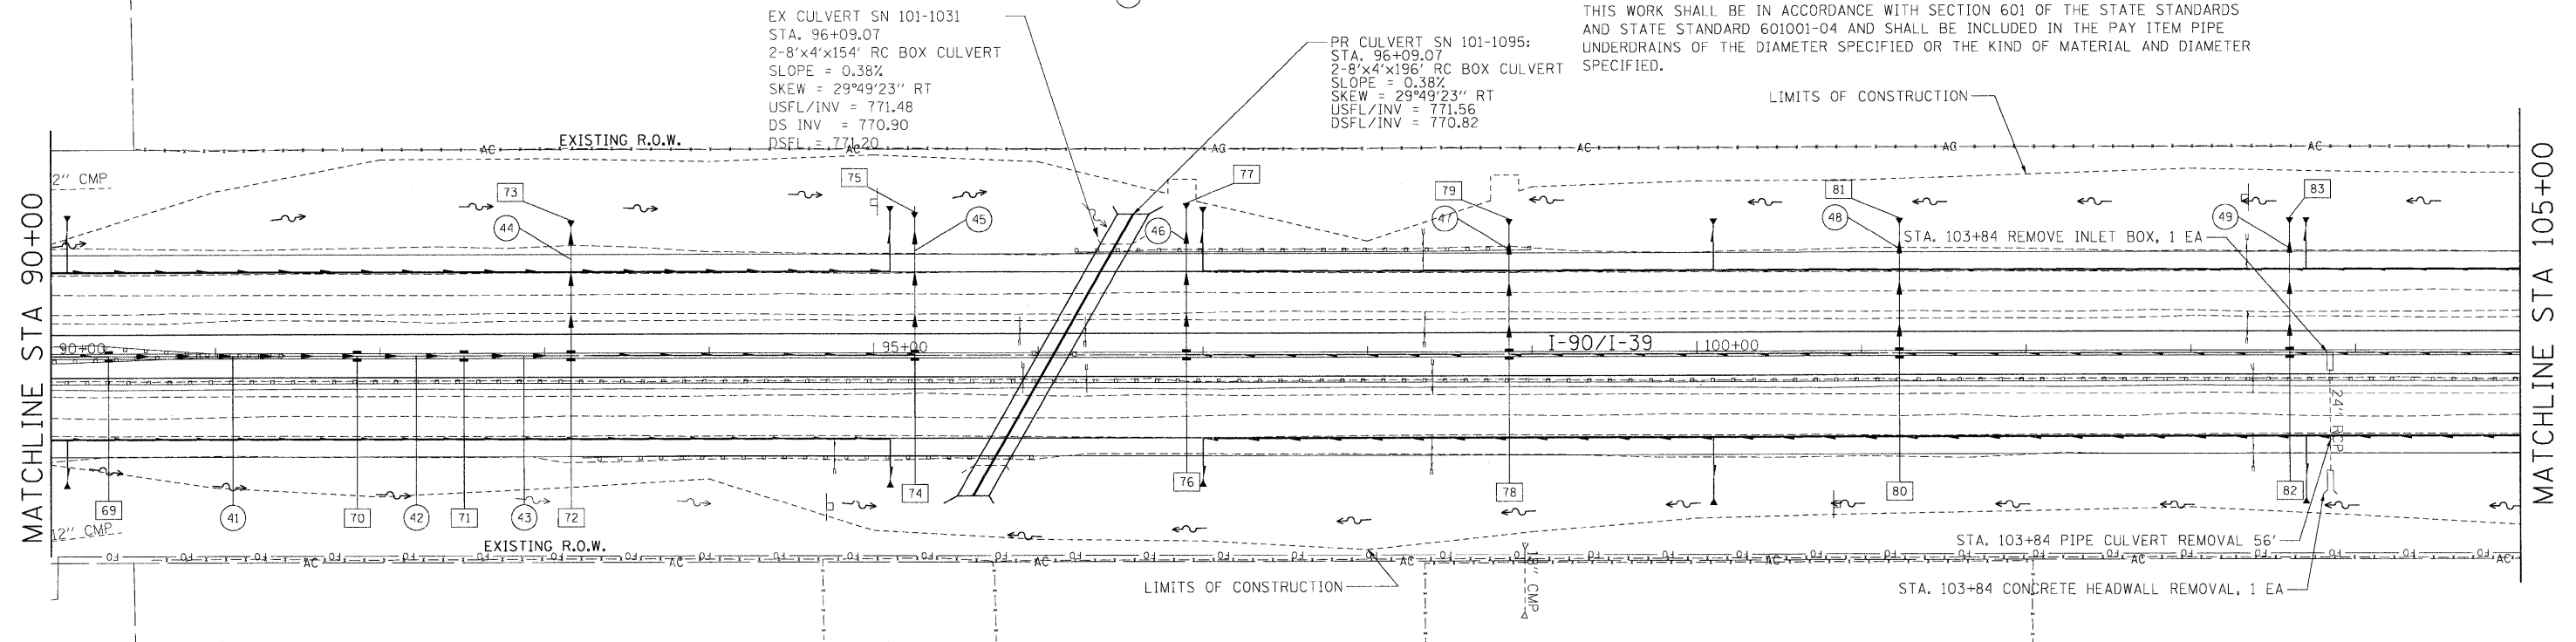

SUNIL ILLINOIS LLC

EDWARD KRULL

TONY H & SALLY Y KWOK

EDWARD KRULL

NYMAN PROPERTIES LLC

NYMAN PROPERTIES LLC



 	USER NAME = .USERNAME. PLOT SCALE = 50.0000' / IN. PLOT DATE = 12/19/2011	DESIGNED - DA DRAWN - DA CHECKED - AM DATE - 10/14/2011	REVISED - REVISED - REVISED - REVISED -	STATE OF ILLINOIS DEPARTMENT OF TRANSPORTATION	I-90 DRAINAGE PLANS	SCALE:	SHEET NO. OF SHEETS	STA. 90+00 TO STA. 105+00	F.A.I. RTE. 90	SECTION (X2-1)R	COUNTY WINNEBAGO	TOTAL SHEETS 510	SHEET NO. 237
												CONTRACT NO. 64C29 ILLINOIS FED. AID PROJECT	