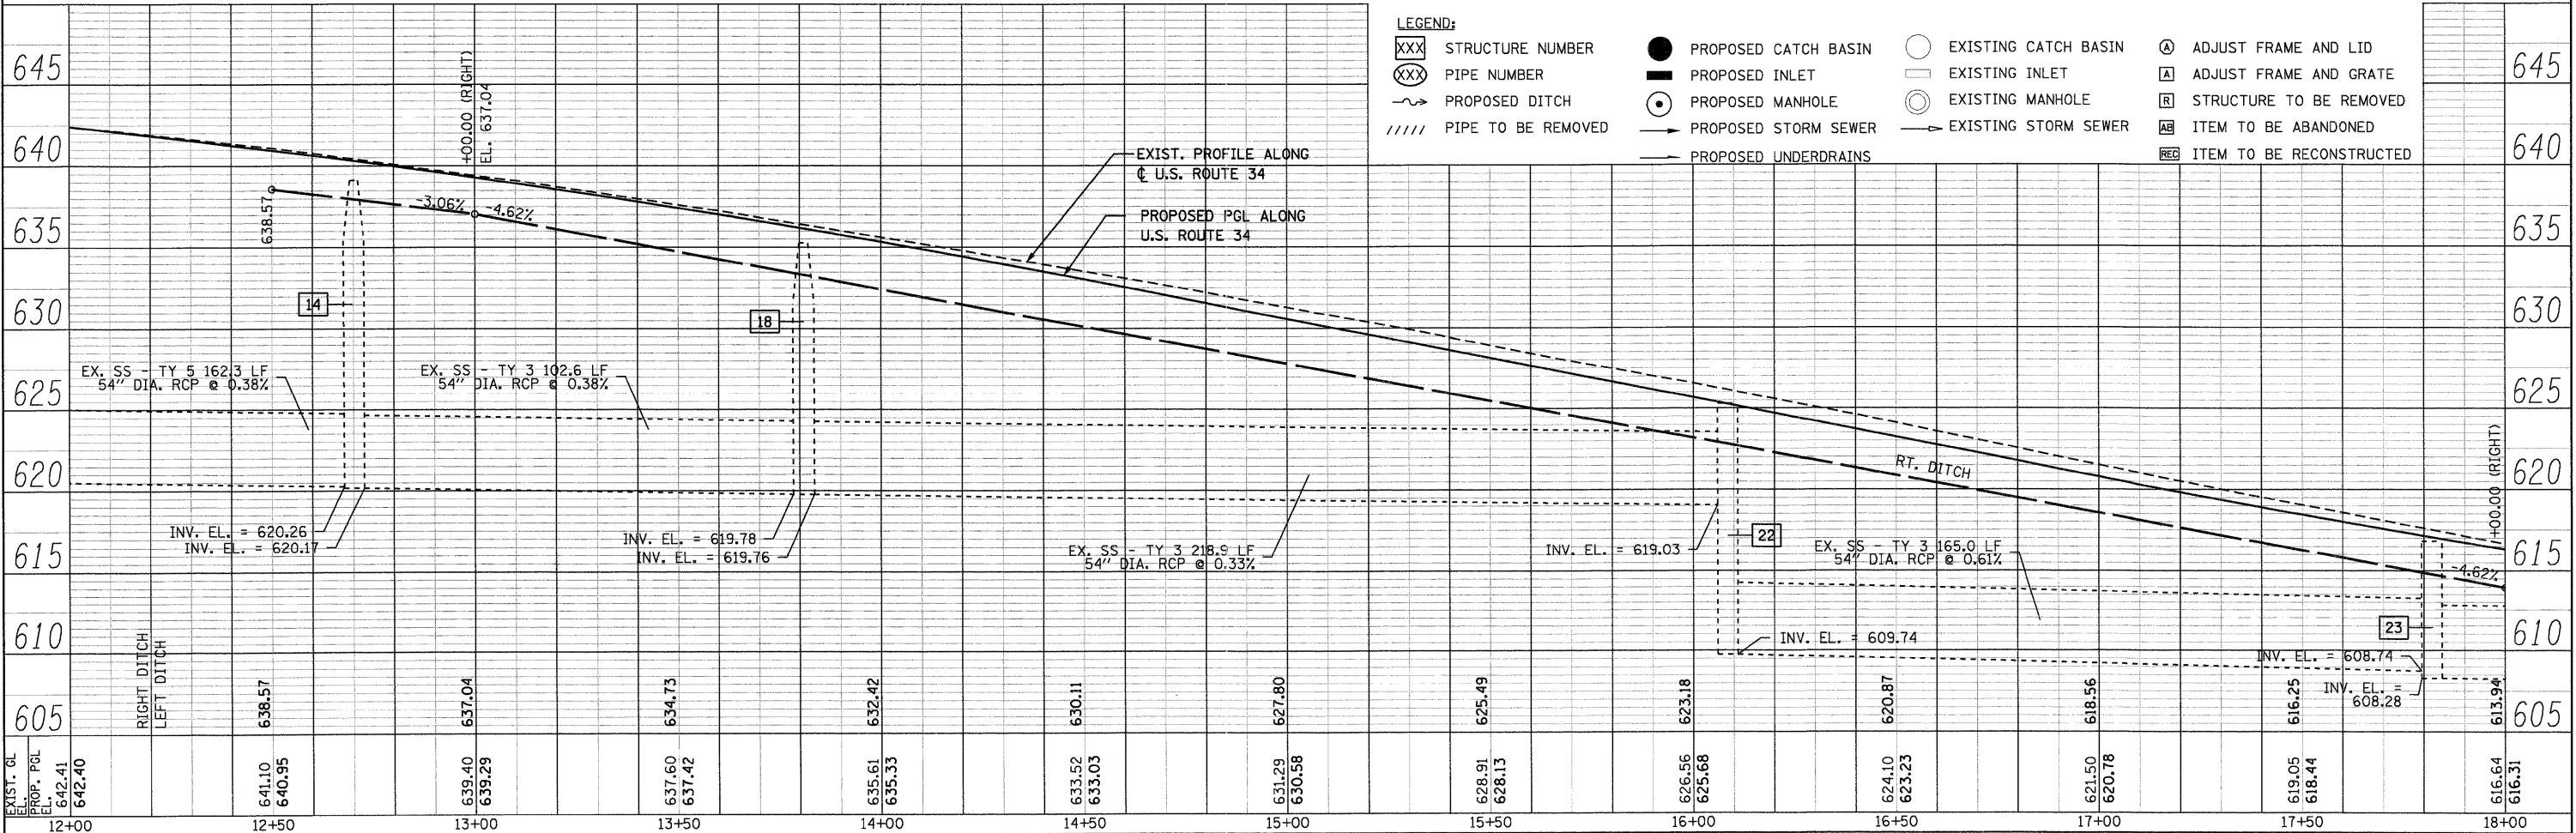
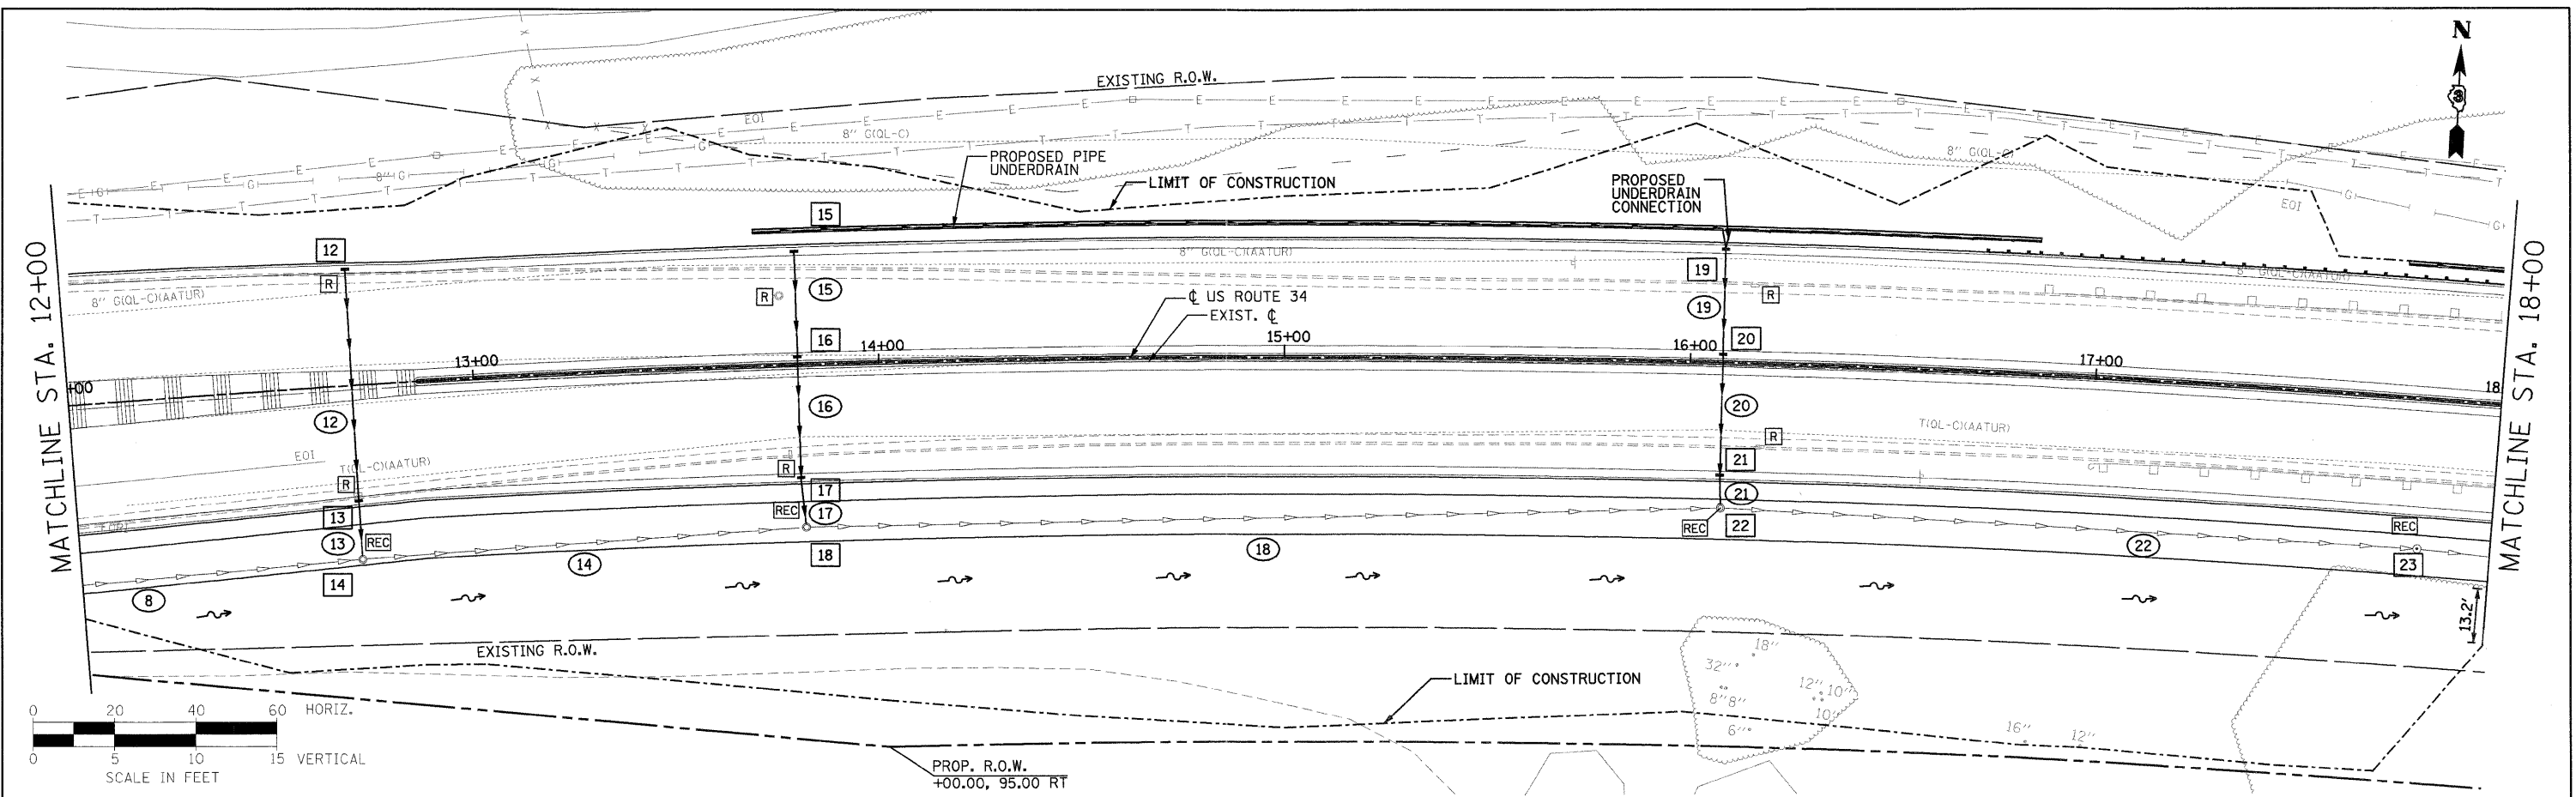


PLAN	REVISIONS	DATE
NO.	BY	
NO.	BY	
PROFILE	REVISIONS	DATE
NO.	BY	
NO.	BY	
PB Americas, Inc. 230 WEST MONROE STREET, SUITE 400 CHICAGO, IL 60606 (312)782-8150	FILE NAME = 0366985-ah-2drain.dgn PLOT SCALE = PLOT DATE = 19-AUG-2011 08:20	DESIGNED - RJD DRAWN - RJD CHECKED - PMK DATE - 08-18-2011	REVISED - REVISED - REVISED - REVISED -	STATE OF ILLINOIS DEPARTMENT OF TRANSPORTATION	DRAINAGE PLAN & PROFILE US ROUTE 34 SCALE: AS SHOWN DRNG - 2 OF 28 STA. 12+00 TO STA. 18+00	F.A.P. RTE. 591 SECTION 13R-2;14R-1 & BR-1(1);15R-1 COUNTY KENDALL TOTAL SHEETS NO. 429 SHEET NO. 161 CONTRACT NO. 66985 ILLINOIS FED. AID PROJECT
---	--	---	--	---	---	--