
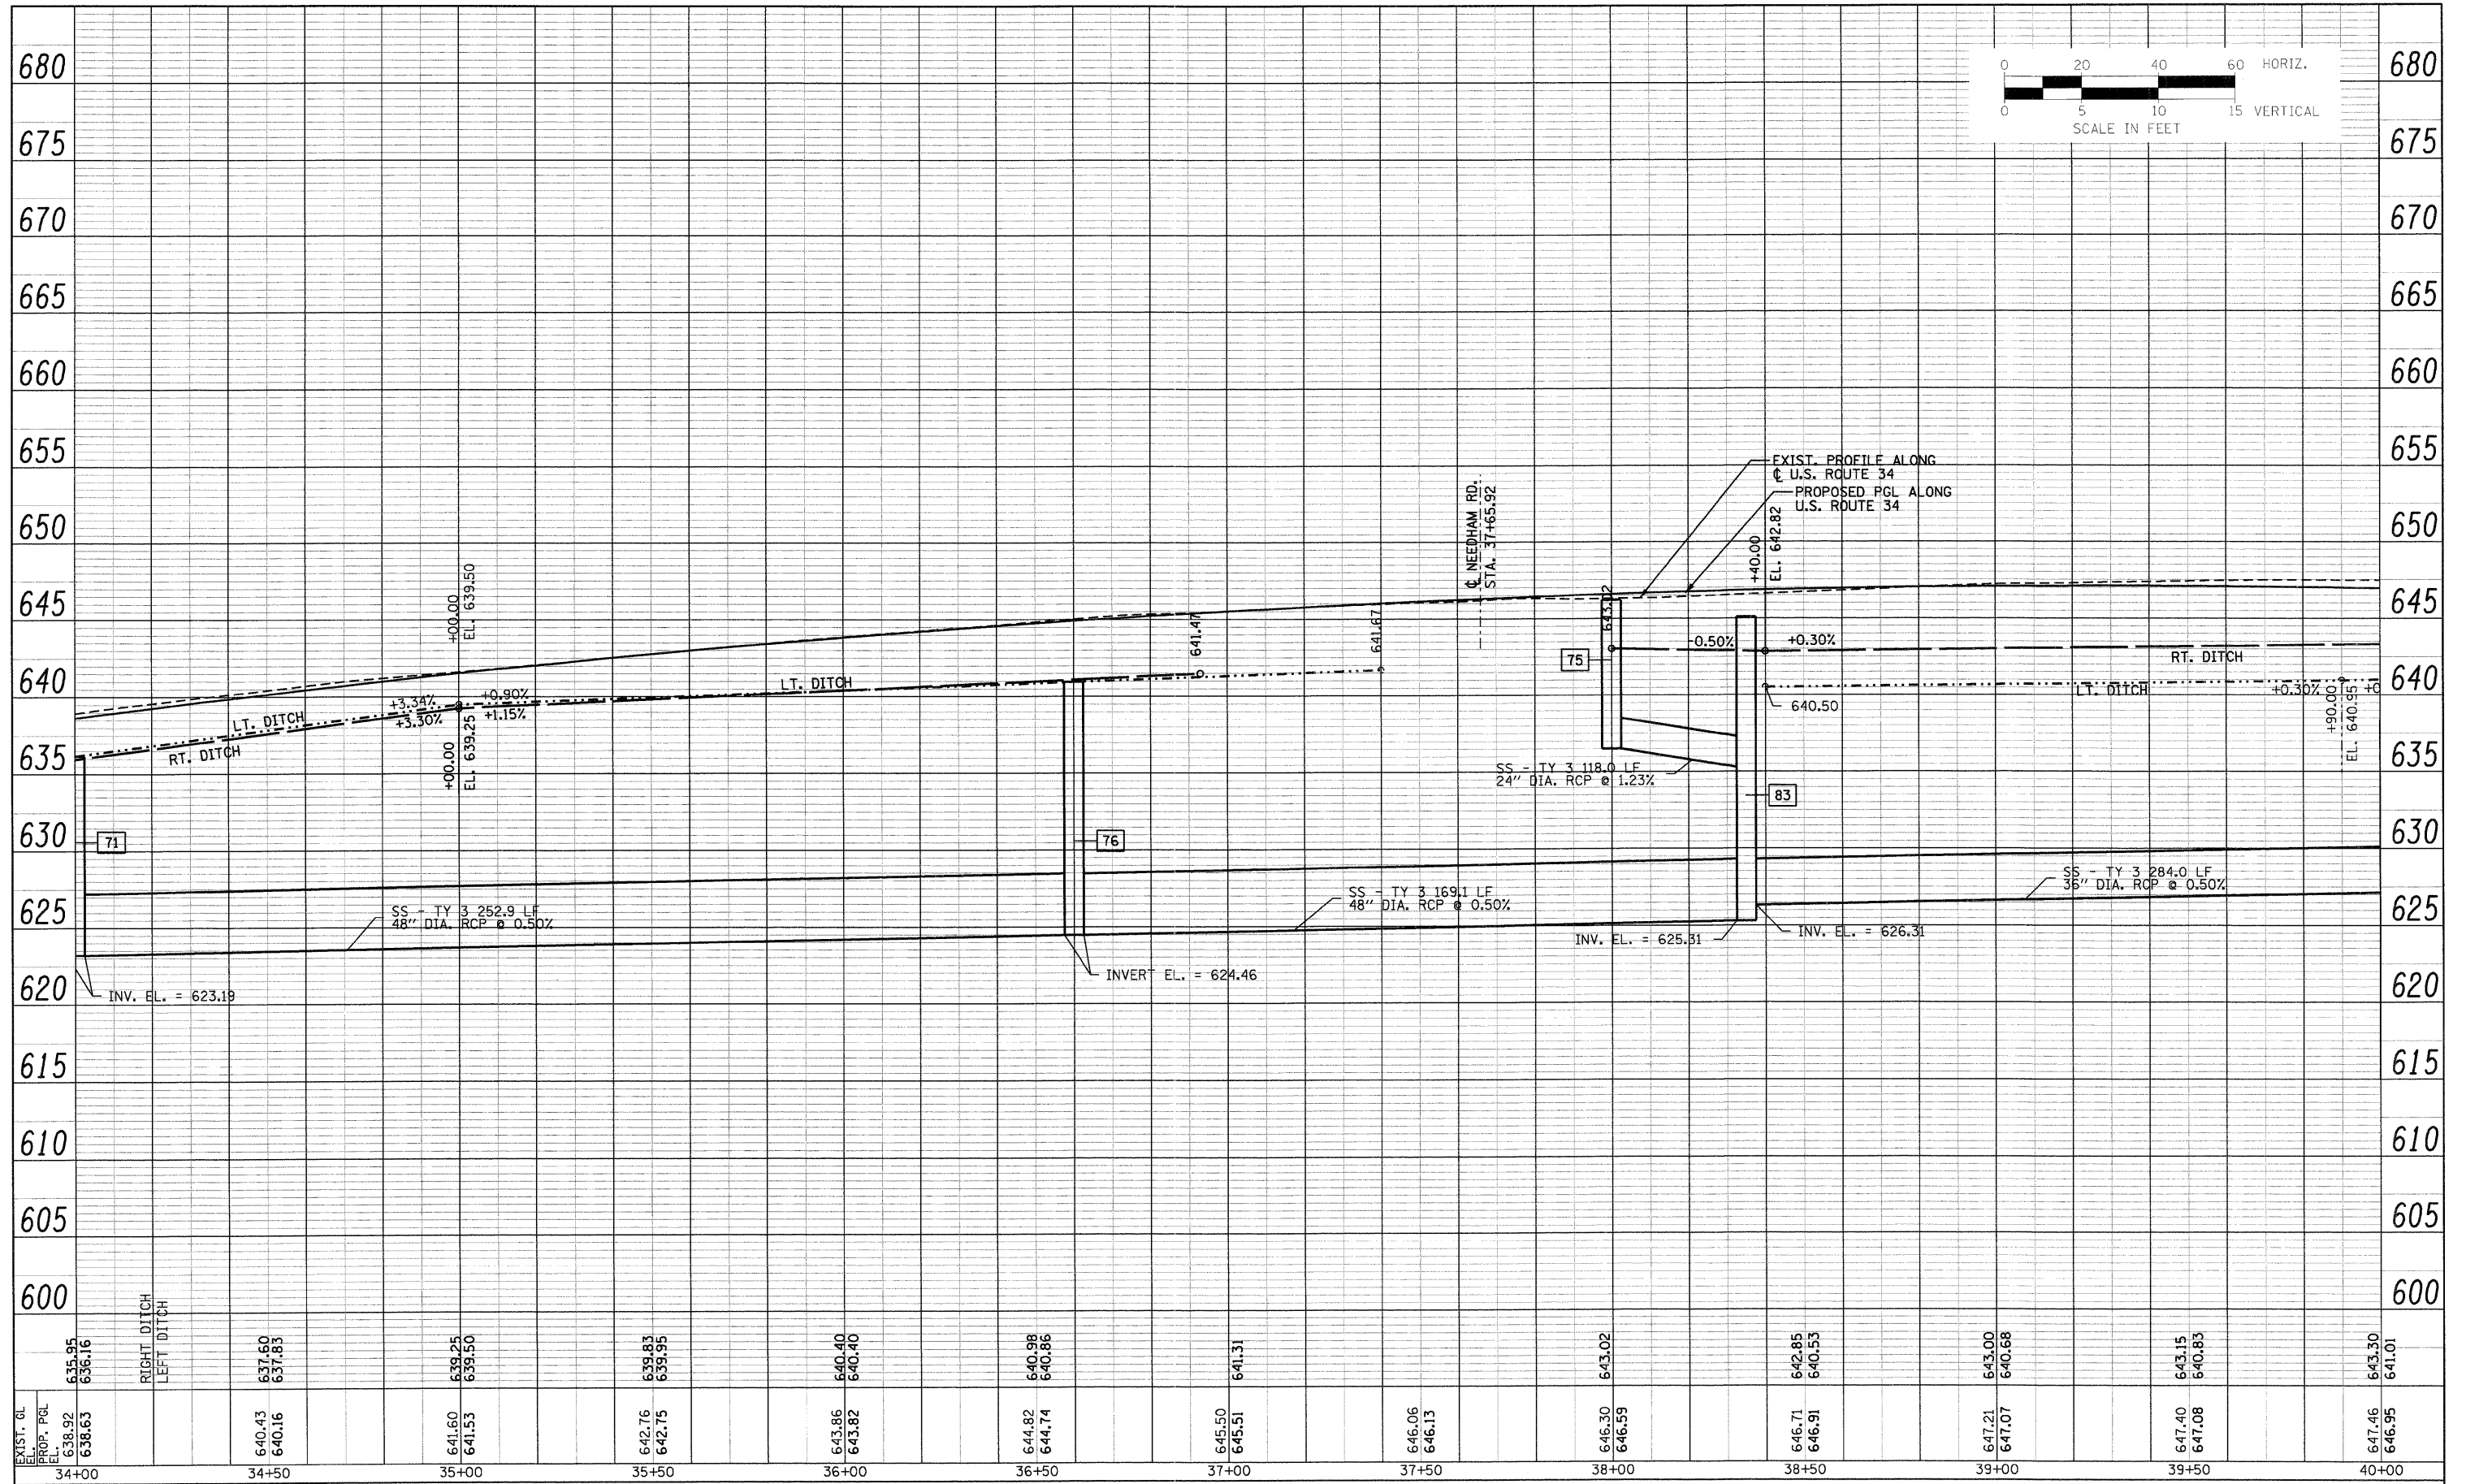


PLAN SURVEYED PLOTTED CHECKED
 NOTE BOOK NO. OF WAY CHECKED
 NO. CAD FILE NAME

PROFILE SURVEYED PLOTTED CHECKED
 NOTE BOOK NO. OF WAY CHECKED
 NO. STRUCTURE NOTATION'S CIVTD

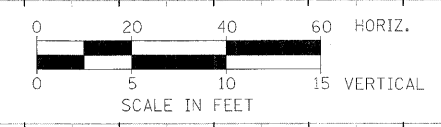

PB Americas, Inc. 230 WEST MONROE STREET, SUITE 900 CHICAGO, IL, 60606 (312)762-8150	FILE NAME = D366985-shr-6drain-prof.dgn PLOT SCALE = PLOT DATE = 19-AUG-2011 08:20	DESIGNED - RJD DRAWN - RJD CHECKED - PMK DATE - 08-18-2011	REVISED - REVISED - REVISED - REVISED -	STATE OF ILLINOIS DEPARTMENT OF TRANSPORTATION	DRAINAGE PLAN & PROFILE US ROUTE 34 SCALE: AS SHOWN DRNG - 6B OF 28 STA. 34+00 TO STA. 40+00	F.A.P. RTE. 591 SECTION 13R-2(1)4R-1 & BR-1(1)15R-1 COUNTY KENDALL TOTAL SHEETS 429 SHEET NO. 169 FINAL SUBMITTAL CONTRACT NO. 66985 ILLINOIS FED. AID PROJECT
---	--	---	--	---	--	--