
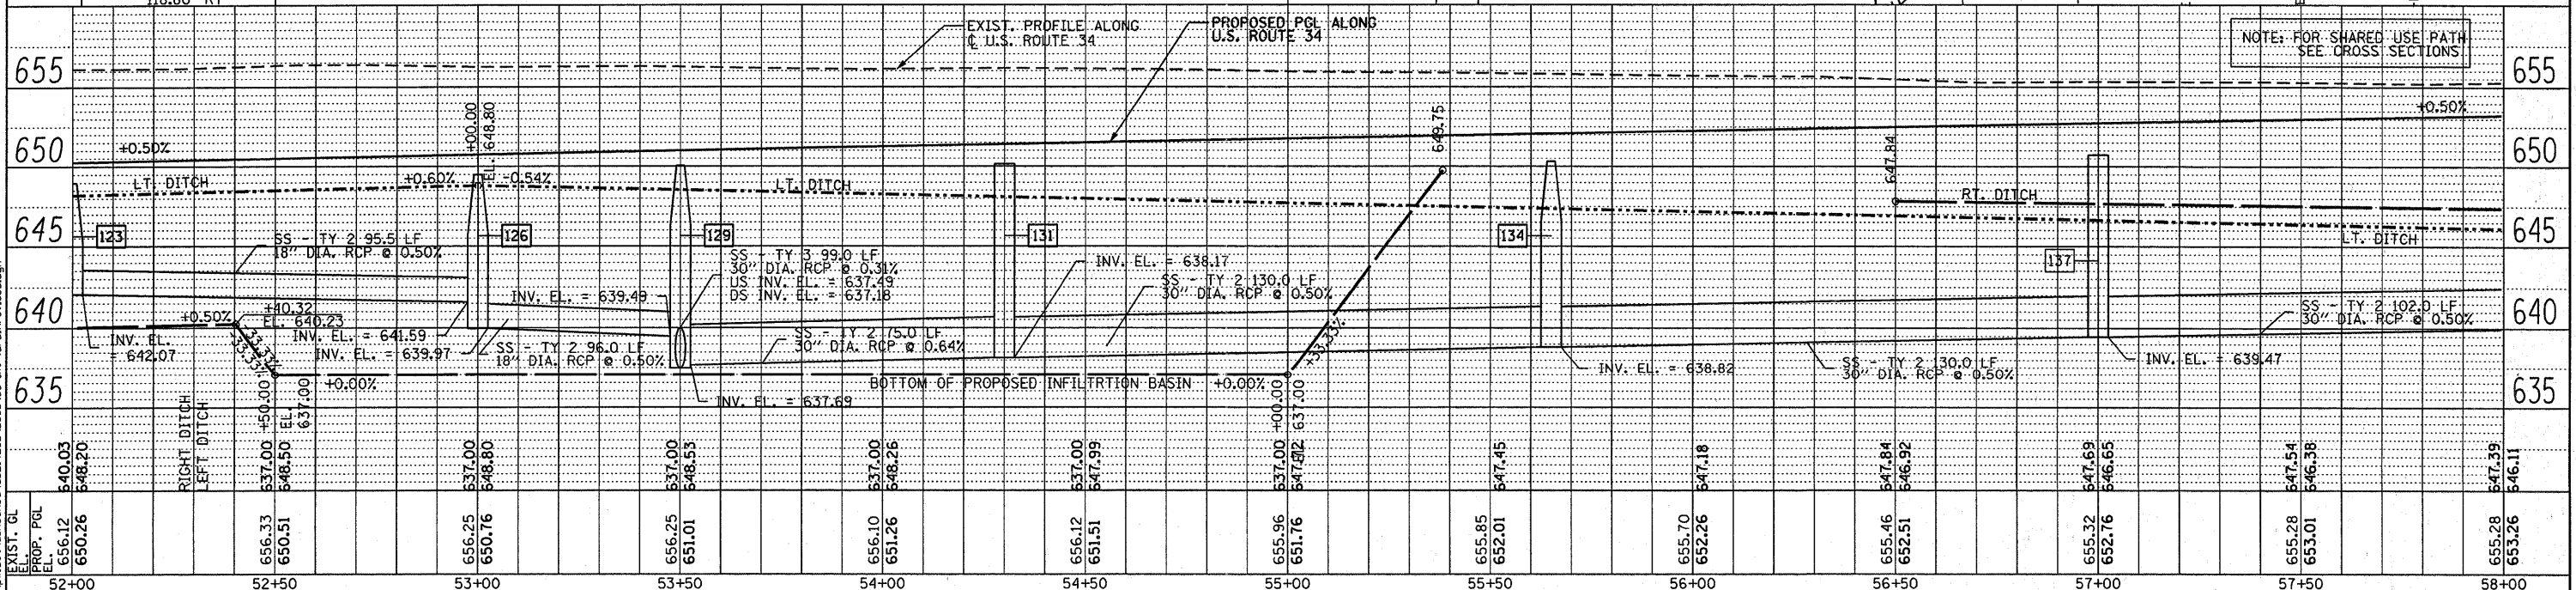
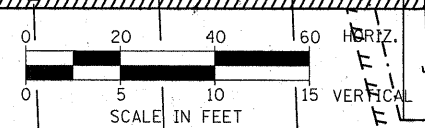


- LEGEND:**
- XXX STRUCTURE NUMBER
  - XXX PIPE NUMBER
  - PROPOSED DITCH
  - PIPE TO BE REMOVED
  - XXX RIPRAP NUMBER
  - PROPOSED CATCH BASIN
  - PROPOSED INLET
  - PROPOSED MANHOLE
  - PROPOSED STORM SEWER
  - PROPOSED UNDERDRAINS
  - PROPOSED CONCRETE HEADWALL FOR PIPE DRAIN
  - EXISTING CATCH BASIN
  - EXISTING INLET
  - EXISTING MANHOLE
  - EXISTING STORM SEWER
  - UTILITY TEST HOLE (S.U.E.)
  - ADJUST FRAME AND LID
  - ADJUST FRAME AND GRATE
  - STRUCTURE TO BE REMOVED
  - ITEM TO BE ABANDONED

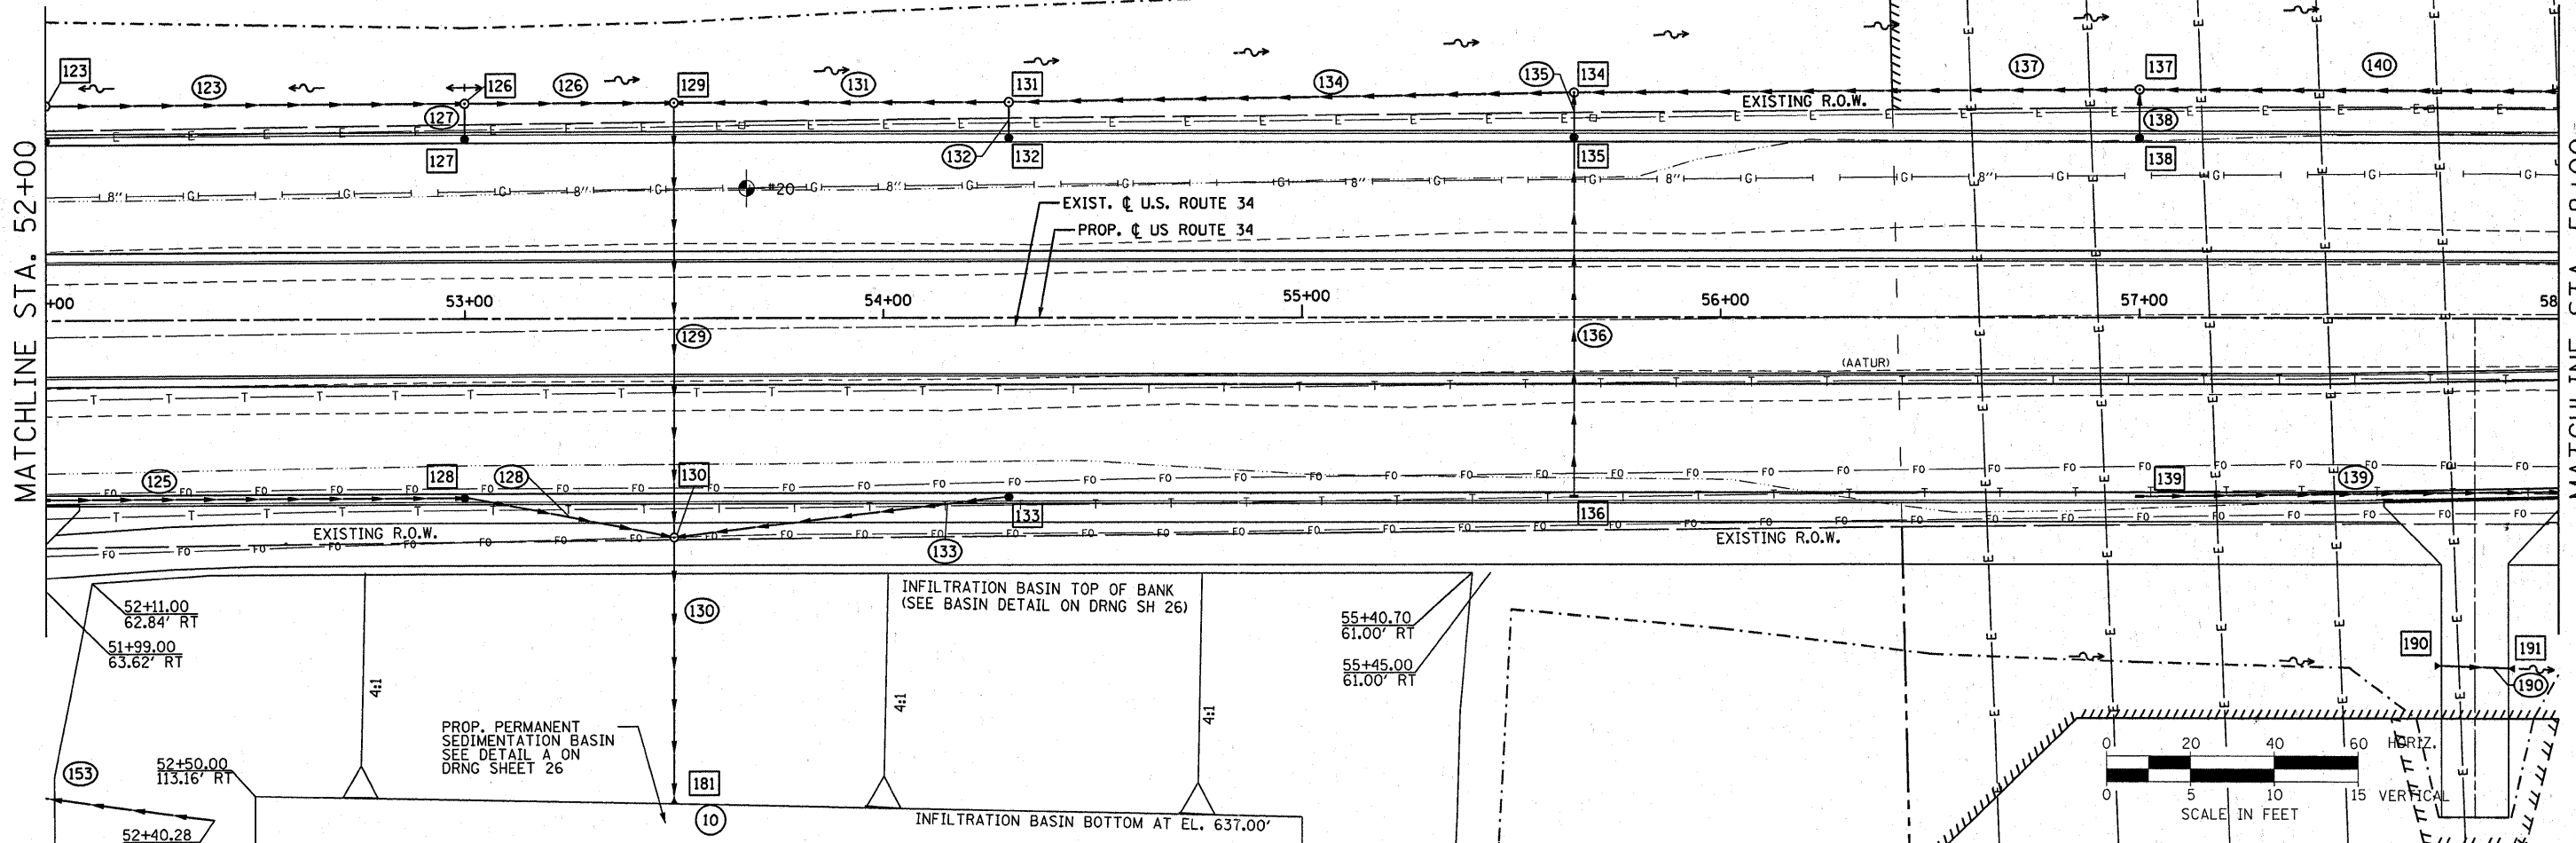

PLAN

DATE	
BY	
REVISIONS	
NO.	

PROFILE

DATE	
BY	
REVISIONS	
NO.	

c:\pwwork\pwwork\duncanbd\214252\DRNG985-rt-9-01-revised.dgn

**PB Americas, Inc.**  
 230 WEST MONROE STREET,  
 SUITE 900  
 CHICAGO, IL 60606  
 (312)762-6150

FILE NAME = duncanbd	DESIGNED - RJD	REVISED - BOD 11/21/2011
PLOT SCALE = 20.0000' / 1"	DRAWN - RJD	REVISED -
PLOT DATE = 11/22/2011	CHECKED - PMK	REVISED -
	DATE - 08-18-2011	REVISED -

**STATE OF ILLINOIS  
 DEPARTMENT OF TRANSPORTATION**

**DRAINAGE PLAN & PROFILE  
 US ROUTE 34**

SCALE: AS SHOWN    DRNG - 9 OF 28    STA. 52+00 TO STA. 58+00

F.A.P. RTE.	SECTION	COUNTY	TOTAL SHEETS	SHEET NO.
591	13R-2;14R-1 & BR-1(1);15R-1	KENDALL	429	172
FINAL SUBMITTAL			CONTRACT NO. 66985	
ILLINOIS FED. AID PROJECT				