
 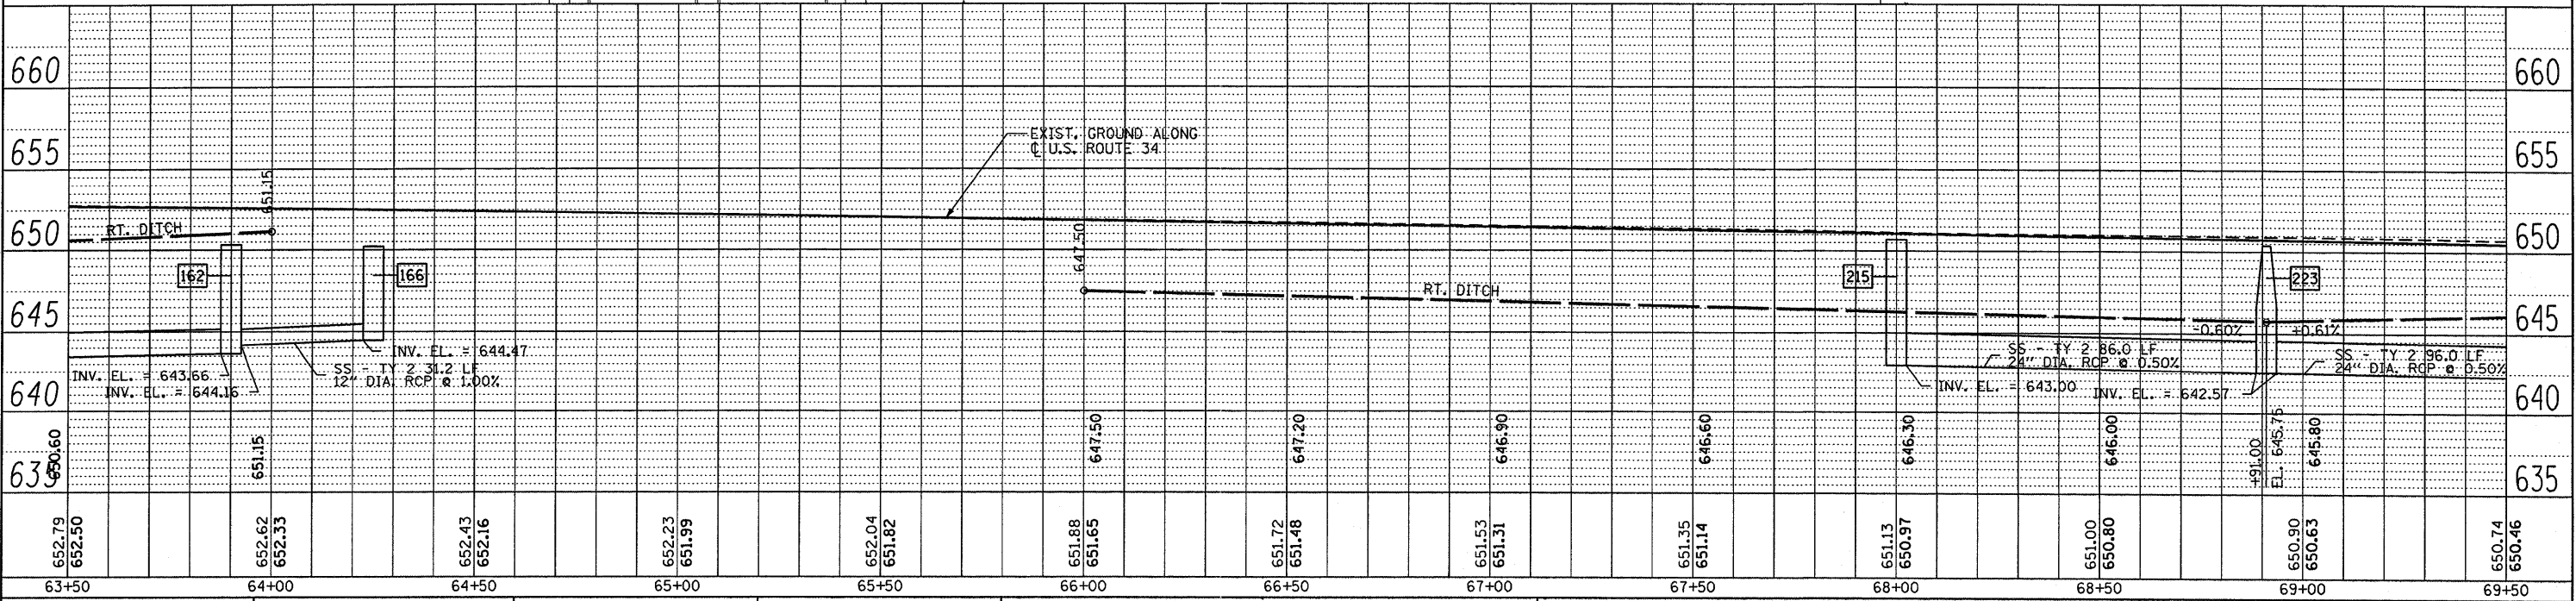



| | |
|------|------|
| PLAN | DATE |
| BY | |
| NO. | |
| NO. | |
| NO. | |
| NO. | |

| | |
|---------|------|
| PROFILE | DATE |
| BY | |
| NO. | |
| NO. | |
| NO. | |
| NO. | |

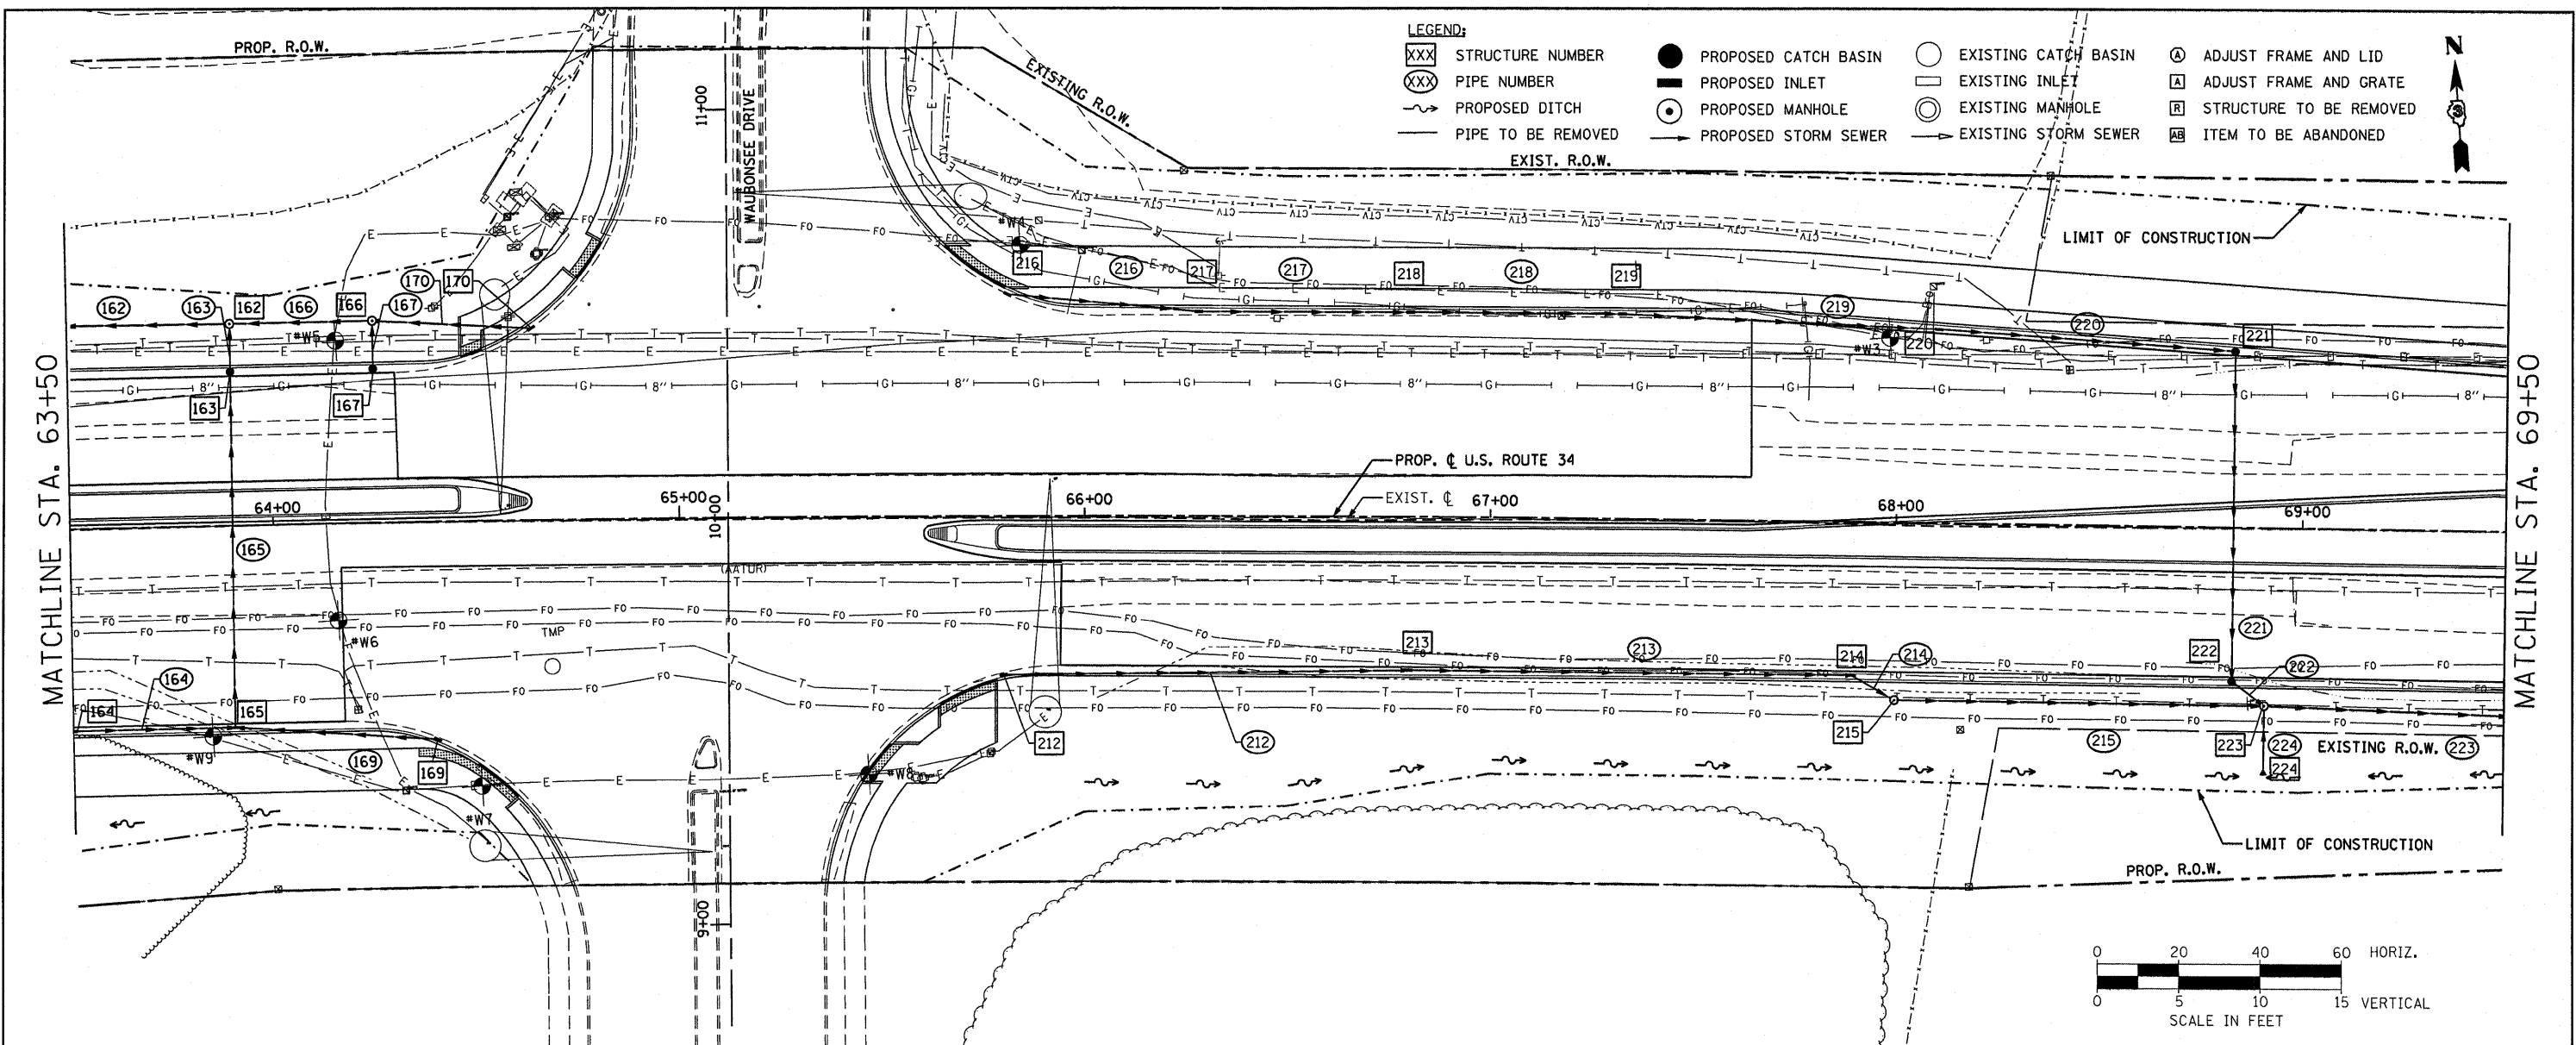

PB Americas, Inc.
 230 WEST MONROE STREET,
 SUITE 900
 CHICAGO, IL 60606
 (312)782-8150

| | | |
|-----------------------------|-------------------|--------------------------|
| FILE NAME = duncmbd | DESIGNED - RJD | REVISED - BDD 09-29-2011 |
| PLOT SCALE = 28.0000' / in. | DRAWN - RJD | REVISED - |
| PLOT DATE = 9/29/2011 | CHECKED - PMK | REVISED - |
| | DATE - 08-18-2011 | REVISED - |

**STATE OF ILLINOIS
 DEPARTMENT OF TRANSPORTATION**

**DRAINAGE PLAN & PROFILE
 US ROUTE 34**

SCALE: AS SHOWN DRNG - 11 OF 28 STA. 64+00 TO STA. 69+50

| | | | | |
|---------------------------|-----------------------------|---------|--------------------|-----------|
| F.A.P. RTE. | SECTION | COUNTY | TOTAL SHEETS | SHEET NO. |
| 591 | 13R-2+14R-1 & BR-1(1)+15R-1 | KENDALL | 429 | 174 |
| FINAL SUBMITTAL | | | CONTRACT NO. 66985 | |
| ILLINOIS FED. AID PROJECT | | | | |