
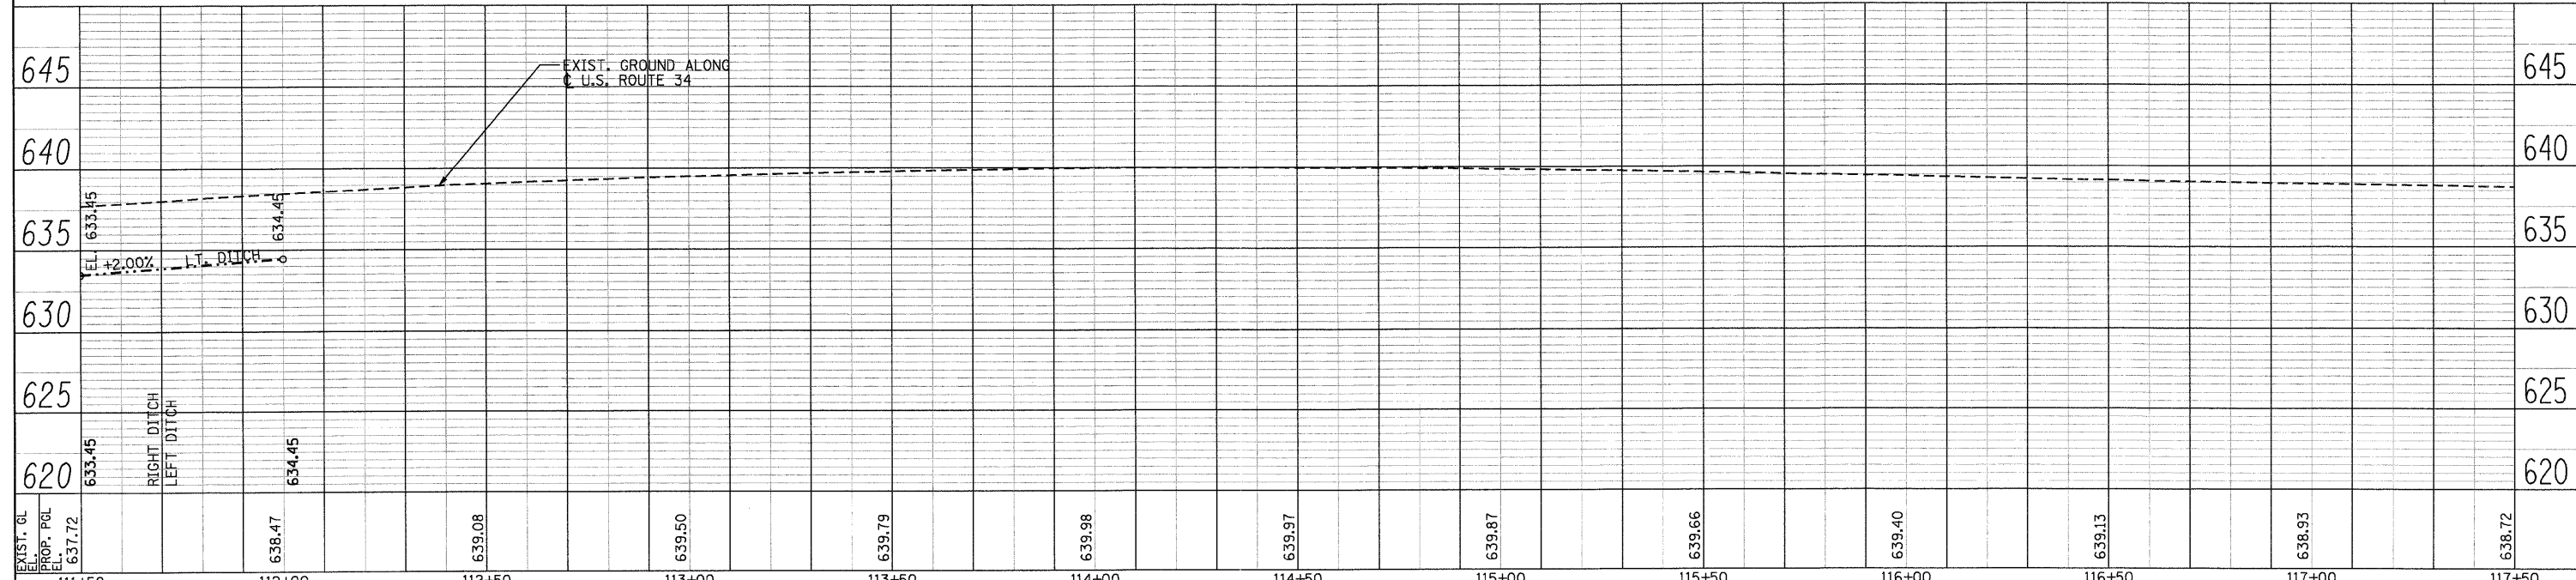


PLAN	SUBMITTED	DATE
	PLOTTED	
	GRADES CHECKED	
	STRUCTURE NOTATIONS CHKD	
	NOTE BOOK NO.	
	CADD FILE NAME	

PROFILE	SUBMITTED	DATE
	PLOTTED	
	GRADES CHECKED	
	STRUCTURE NOTATIONS CHKD	
	NOTE BOOK NO.	
	CADD FILE NAME	

- LEGEND:**
- XXX STRUCTURE NUMBER
 - XXX PIPE NUMBER
 - PROPOSED DITCH
 - PIPE TO BE REMOVED
 - PROPOSED UNDERDRAINS
 - PROPOSED CATCH BASIN
 - PROPOSED INLET
 - PROPOSED MANHOLE
 - PROPOSED STORM SEWER
 - UTILITY TEST HOLE (S.U.E.)
 - EXISTING CATCH BASIN
 - EXISTING INLET
 - EXISTING MANHOLE
 - EXISTING STORM SEWER
 - ADJUST FRAME AND LID
 - ADJUST FRAME AND GRATE
 - STRUCTURE TO BE REMOVED
 - ITEM TO BE ABANDONED
 - PROPOSED CONCRETE HEADWALL FOR PIPE DRAIN

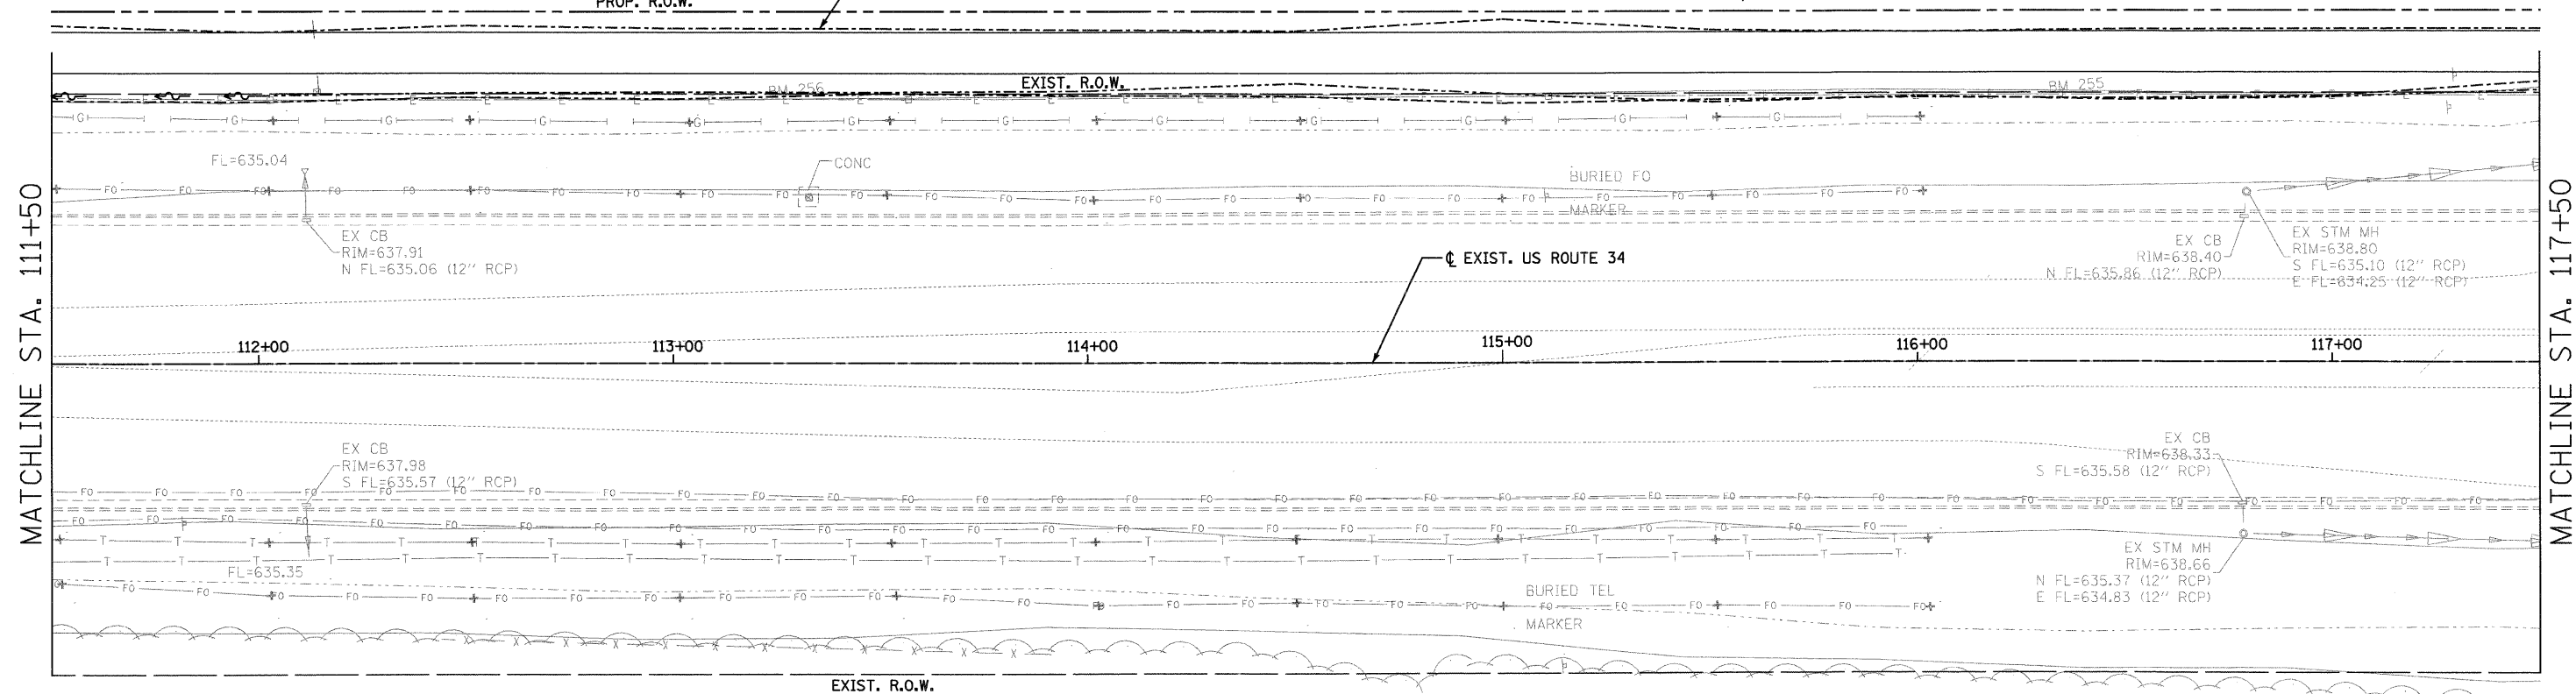

PB Americas, Inc. 230 WEST MONROE STREET, SUITE 900 CHICAGO, IL 60606 (312)782-8150	FILE NAME = D366985-shr-19-dra.mxd DESIGNED - RJD DRAWN - RJD CHECKED - PMK DATE - 08-18-2011	REVISED - REVISED - REVISED - REVISED -	STATE OF ILLINOIS DEPARTMENT OF TRANSPORTATION	DRAINAGE PLAN & PROFILE US ROUTE 34		F.A.P. RTE. 591 13R-2;14R-1 & BR-1(1);15R-1	COUNTY KENDALL	TOTAL SHEETS 429	SHEET NO. 182
	PLOT SCALE = PLOT DATE = 19-AUG-2011 08:21	SCALE: AS SHOWN DRNG - 19 OF 28 STA. 111+50 TO STA. 117+50		FINAL SUBMITTAL ILLINOIS FED. AID PROJECT	CONTRACT NO. 66985				