
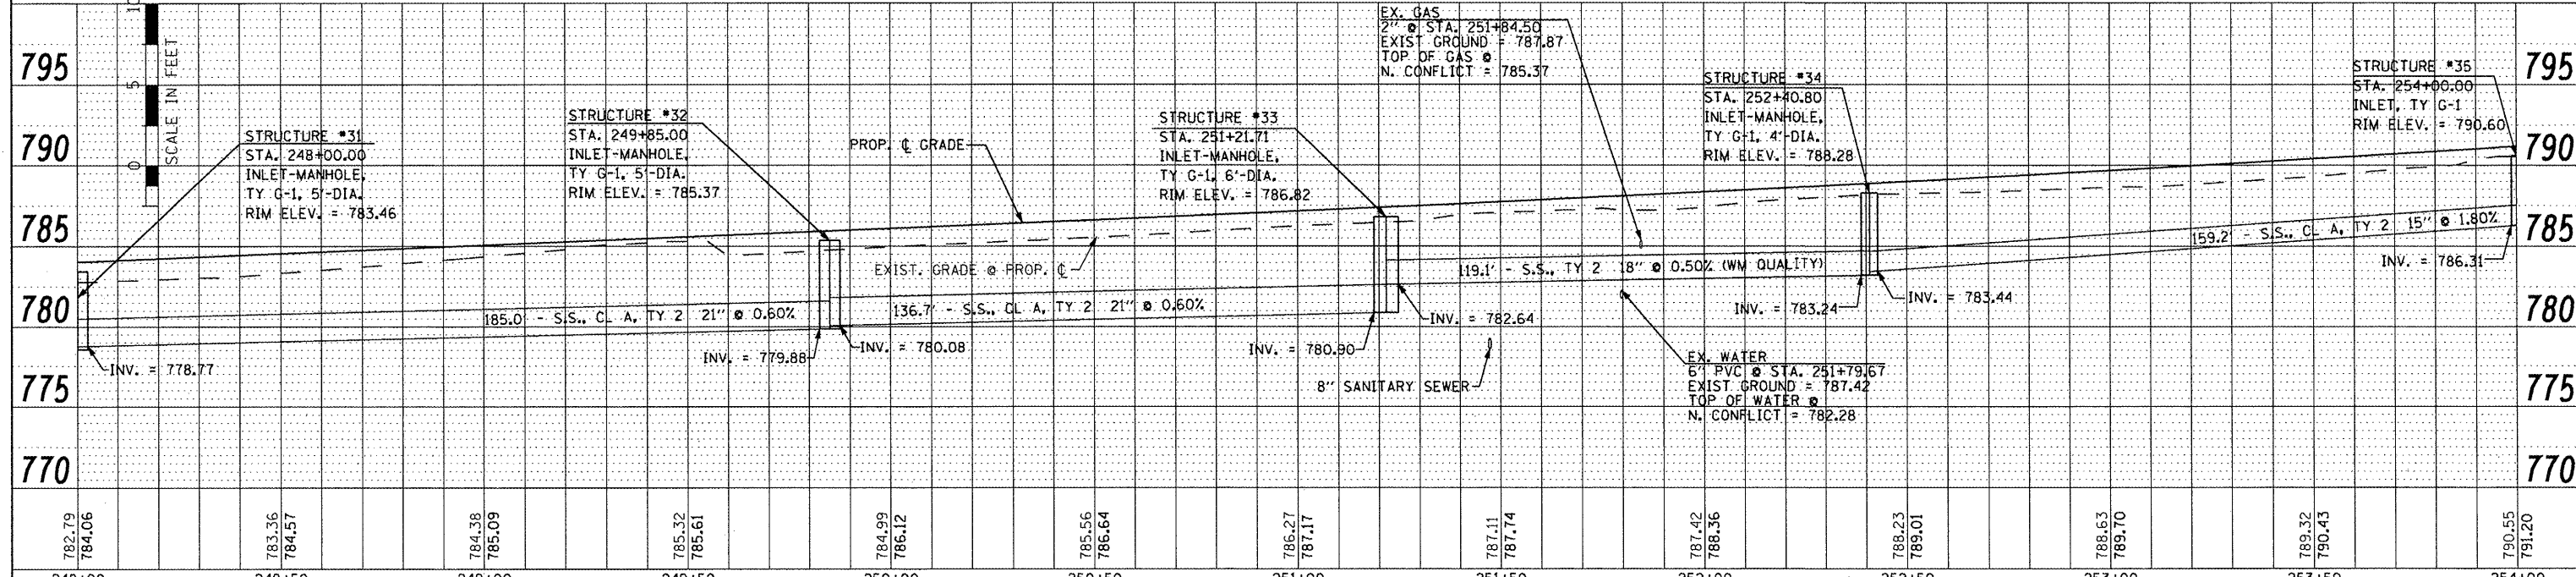
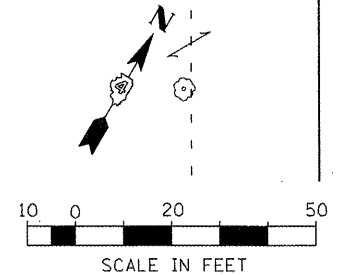


DATE  
BY  
SURVEYED  
PLOTTED  
CHECKED  
NOTE BOOK NO.  
DATE FILED

DATE  
BY  
SURVEYED  
PLOTTED  
CHECKED  
NOTE BOOK NO.  
DATE FILED

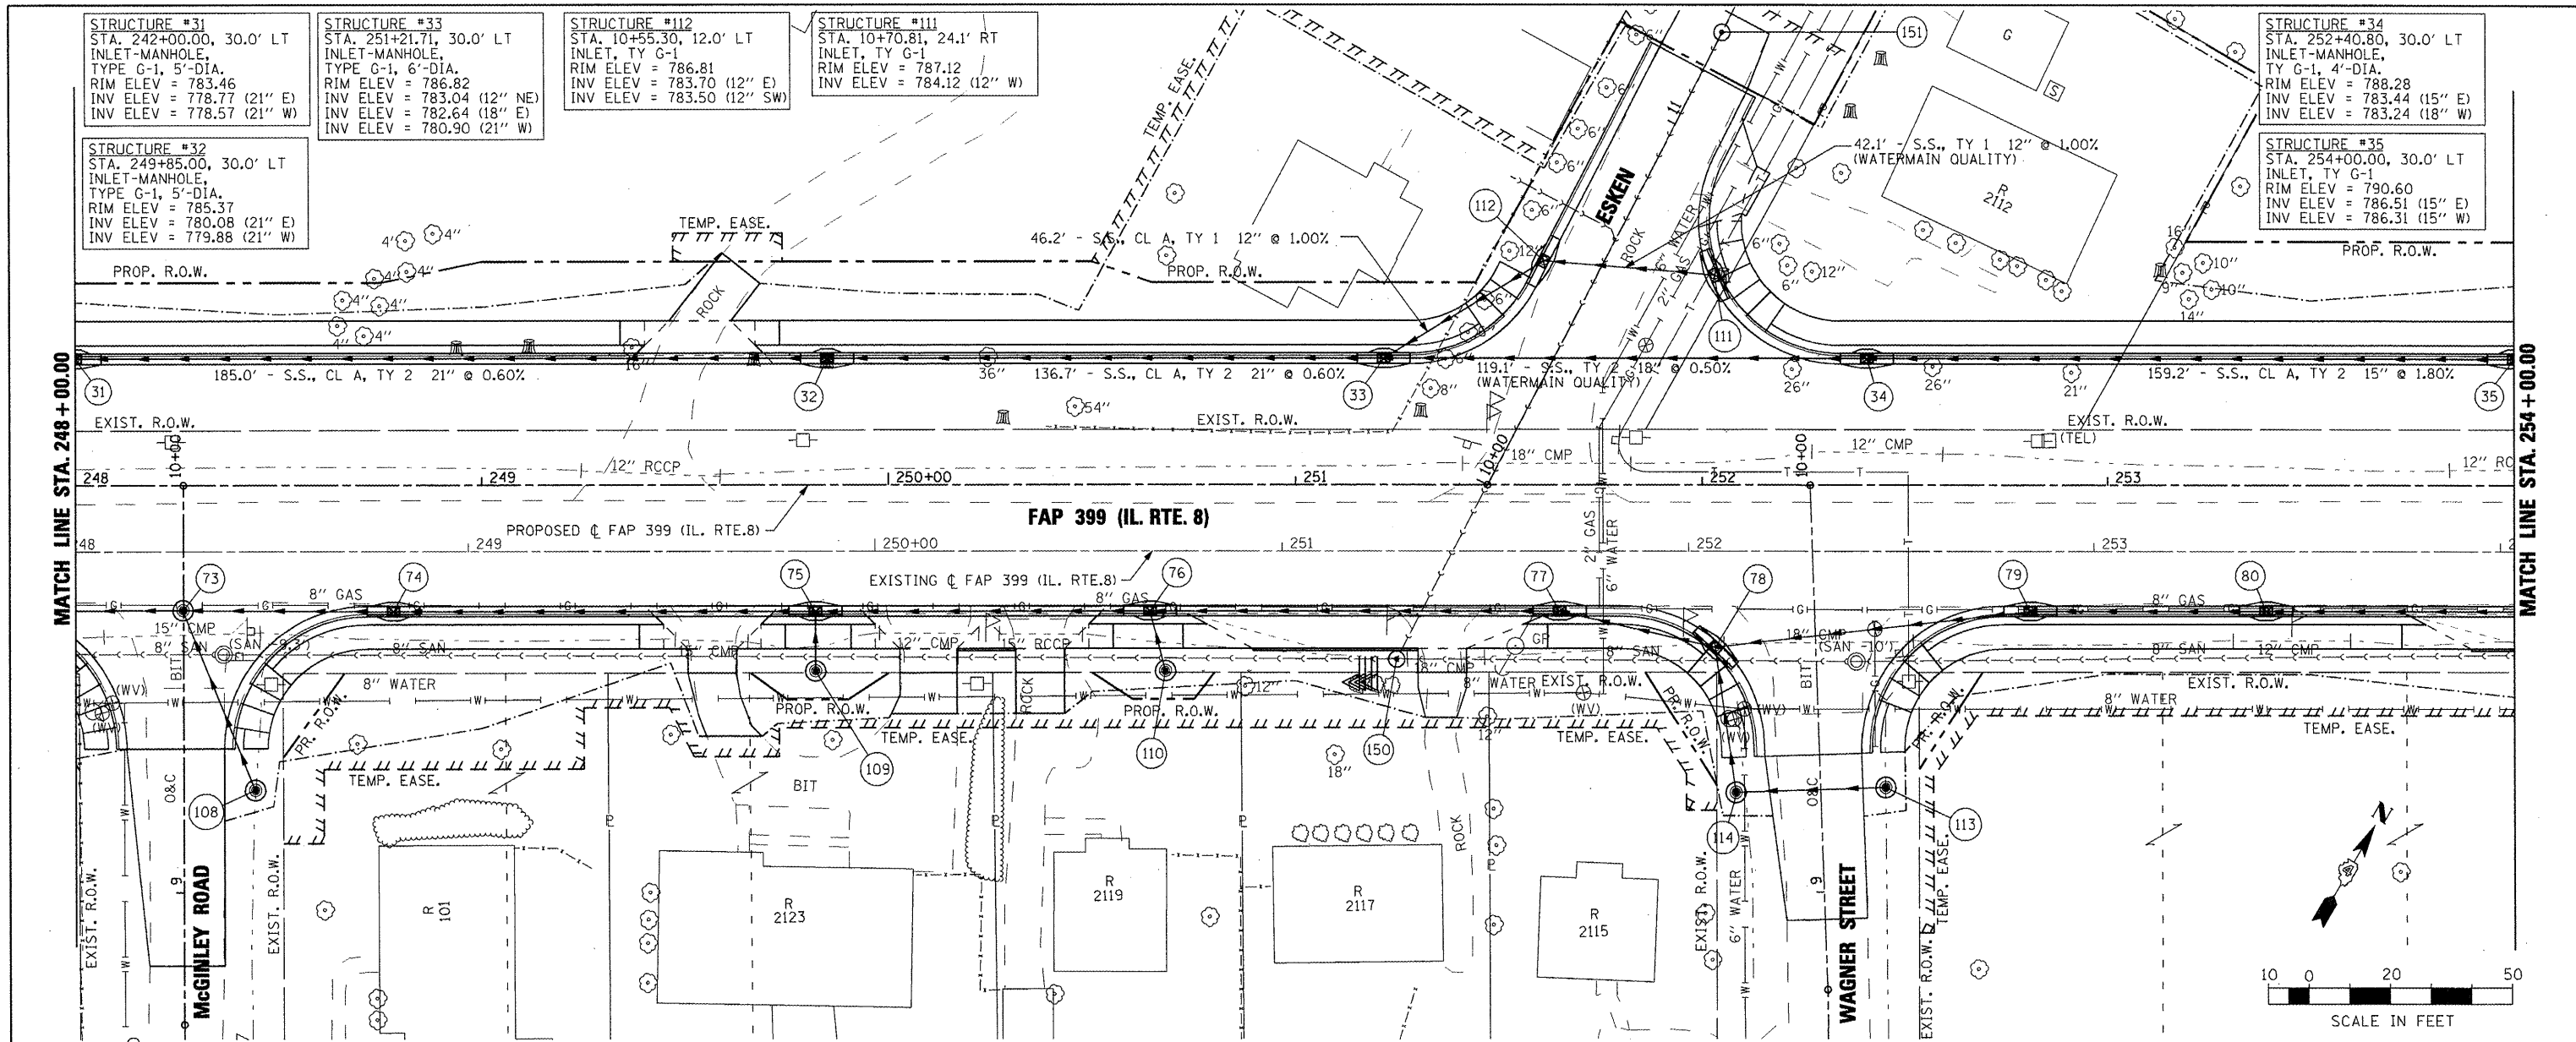

FILE NAME =	USER NAME = JDOT	DESIGNED -	REVISED -	<b>STATE OF ILLINOIS DEPARTMENT OF TRANSPORTATION</b>		<b>FAP 399 (IL RTE. 8) DRAINAGE PLAN AND PROFILE - NORTH</b>				F.A. RTE.	SECTION	COUNTY	TOTAL SHEETS	SHEET NO.	
DRAWN -										REVISED -	399	36 R-7	TAZEWELL	390	185
CHECKED -										REVISED -	CONTRACT NO. 68370				
PLOT DATE = 10/21/2011										REVISED -	ILLINOIS FED. AID PROJECT				
SCALE: AS SHOWN						SHEET NO. OF SHEETS				STA. 248+00.00 TO STA. 254+00.00					