


# ARCHIVED LIGHTING PLANS

FOR INFORMATION ONLY

F.A.P. RTE.	SECTION	COUNTY	TOTAL SHEETS	SHEET NO.
310	69-IXL-1	MORGAN	34	230
STA.	TO STA.			
FED. ROAD DIST. NO. 7	ILLINOIS FED. AID PROJECT			

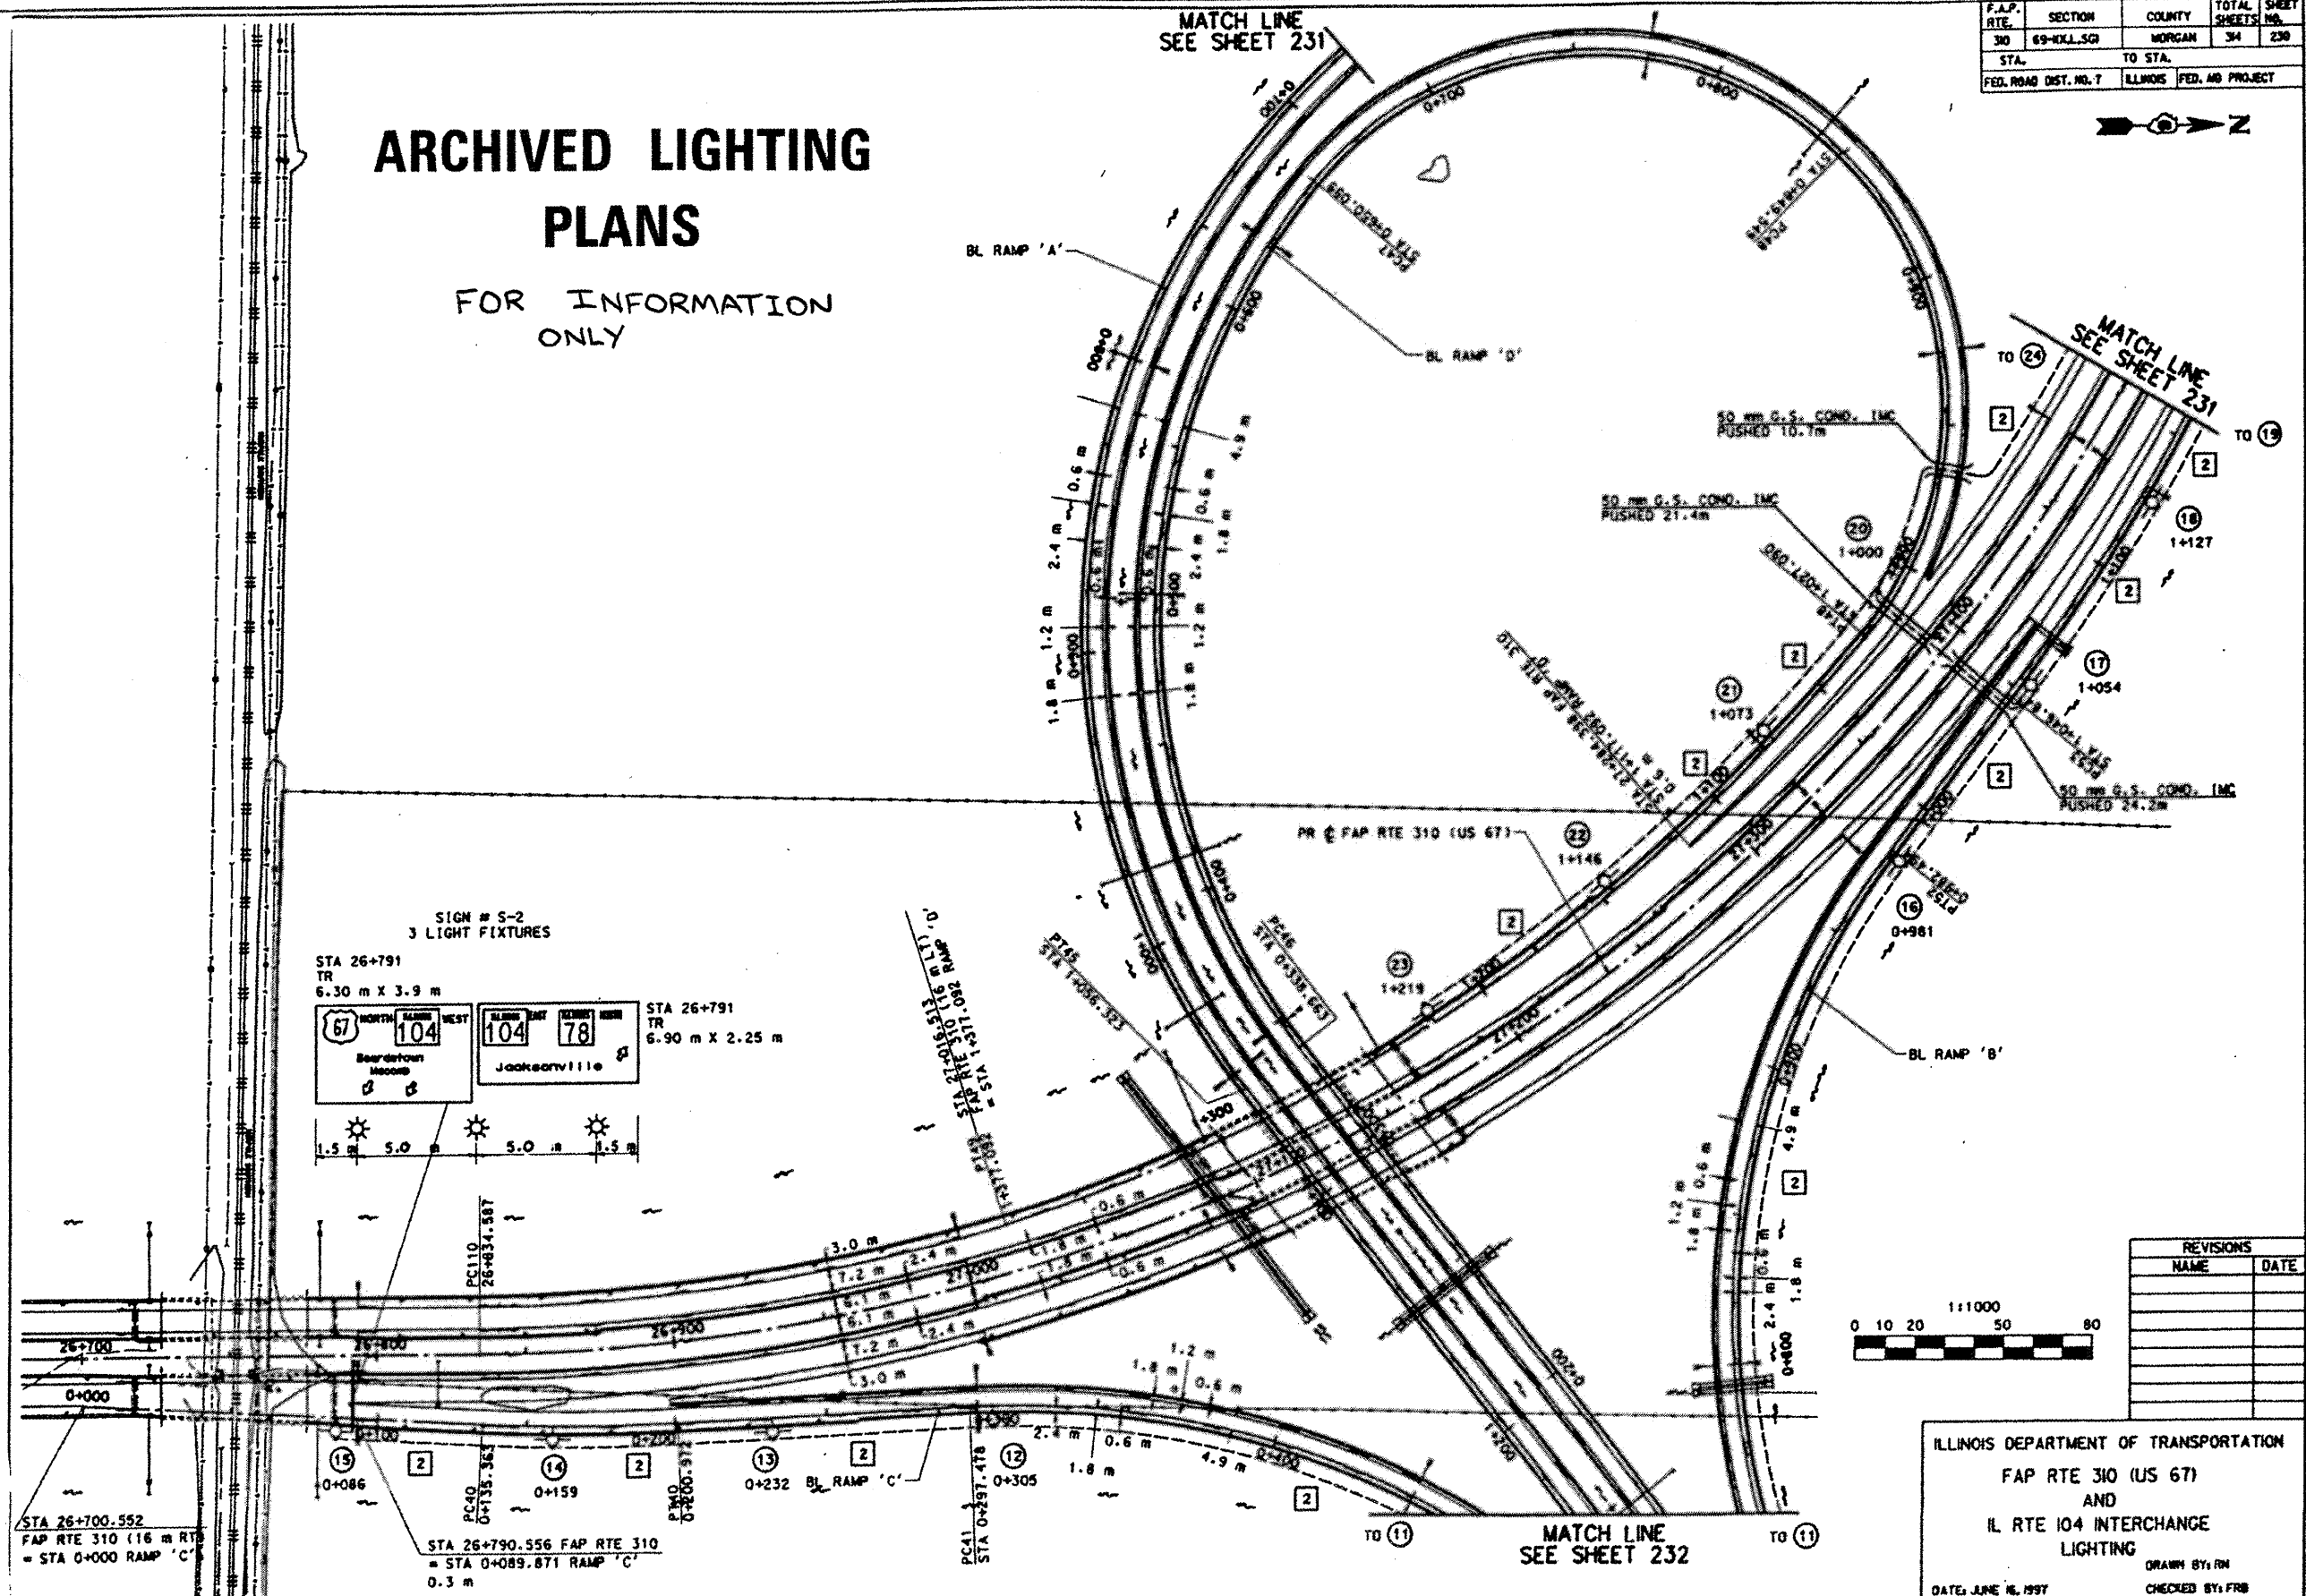

 
SIGN # S-2  
3 LIGHT FIXTURES

STA 26+791  
TR  
6.30 m X 3.9 m

67 NORTH	104	104	78
Boardman	Moore	Jacksonville	

STA 26+791  
TR  
6.90 m X 2.25 m

1.5 m 5.0 m 5.0 m 1.5 m



REVISIONS	
NAME	DATE

ILLINOIS DEPARTMENT OF TRANSPORTATION  
FAP RTE 310 (US 67)  
AND  
IL RTE 104 INTERCHANGE  
LIGHTING  
DRAWN BY: RM  
CHECKED BY: FRB  
DATE: JUNE 16, 1997

FILE NAME:	USER NAME: jomassa	DESIGNED: _____	REVISED: _____
\\p:\work\p\dot\j\omassa\08244789\067213-13-13-lighting\details.dgn		DRAWN: _____	REVISED: _____
PLOT SCALE: 8:38.937 m / in		CHECKED: _____	REVISED: _____
PLOT DATE: Sep-21-2011 01:36:37PM		DATE: _____	REVISED: _____

STATE OF ILLINOIS  
DEPARTMENT OF TRANSPORTATION

ARCHIVED LIGHTING PLANS

SCALE: \_\_\_\_\_ SHEET \_\_\_\_\_ OF \_\_\_\_\_ SHEETS STA. \_\_\_\_\_ TO STA. \_\_\_\_\_

F.A.P. RTE.	SECTION	COUNTY	TOTAL SHEETS	SHEET NO.
310	69-IX-1	MORGAN	17	17
ILLINOIS FED. AID PROJECT			CONTRACT NO. 72E13	