
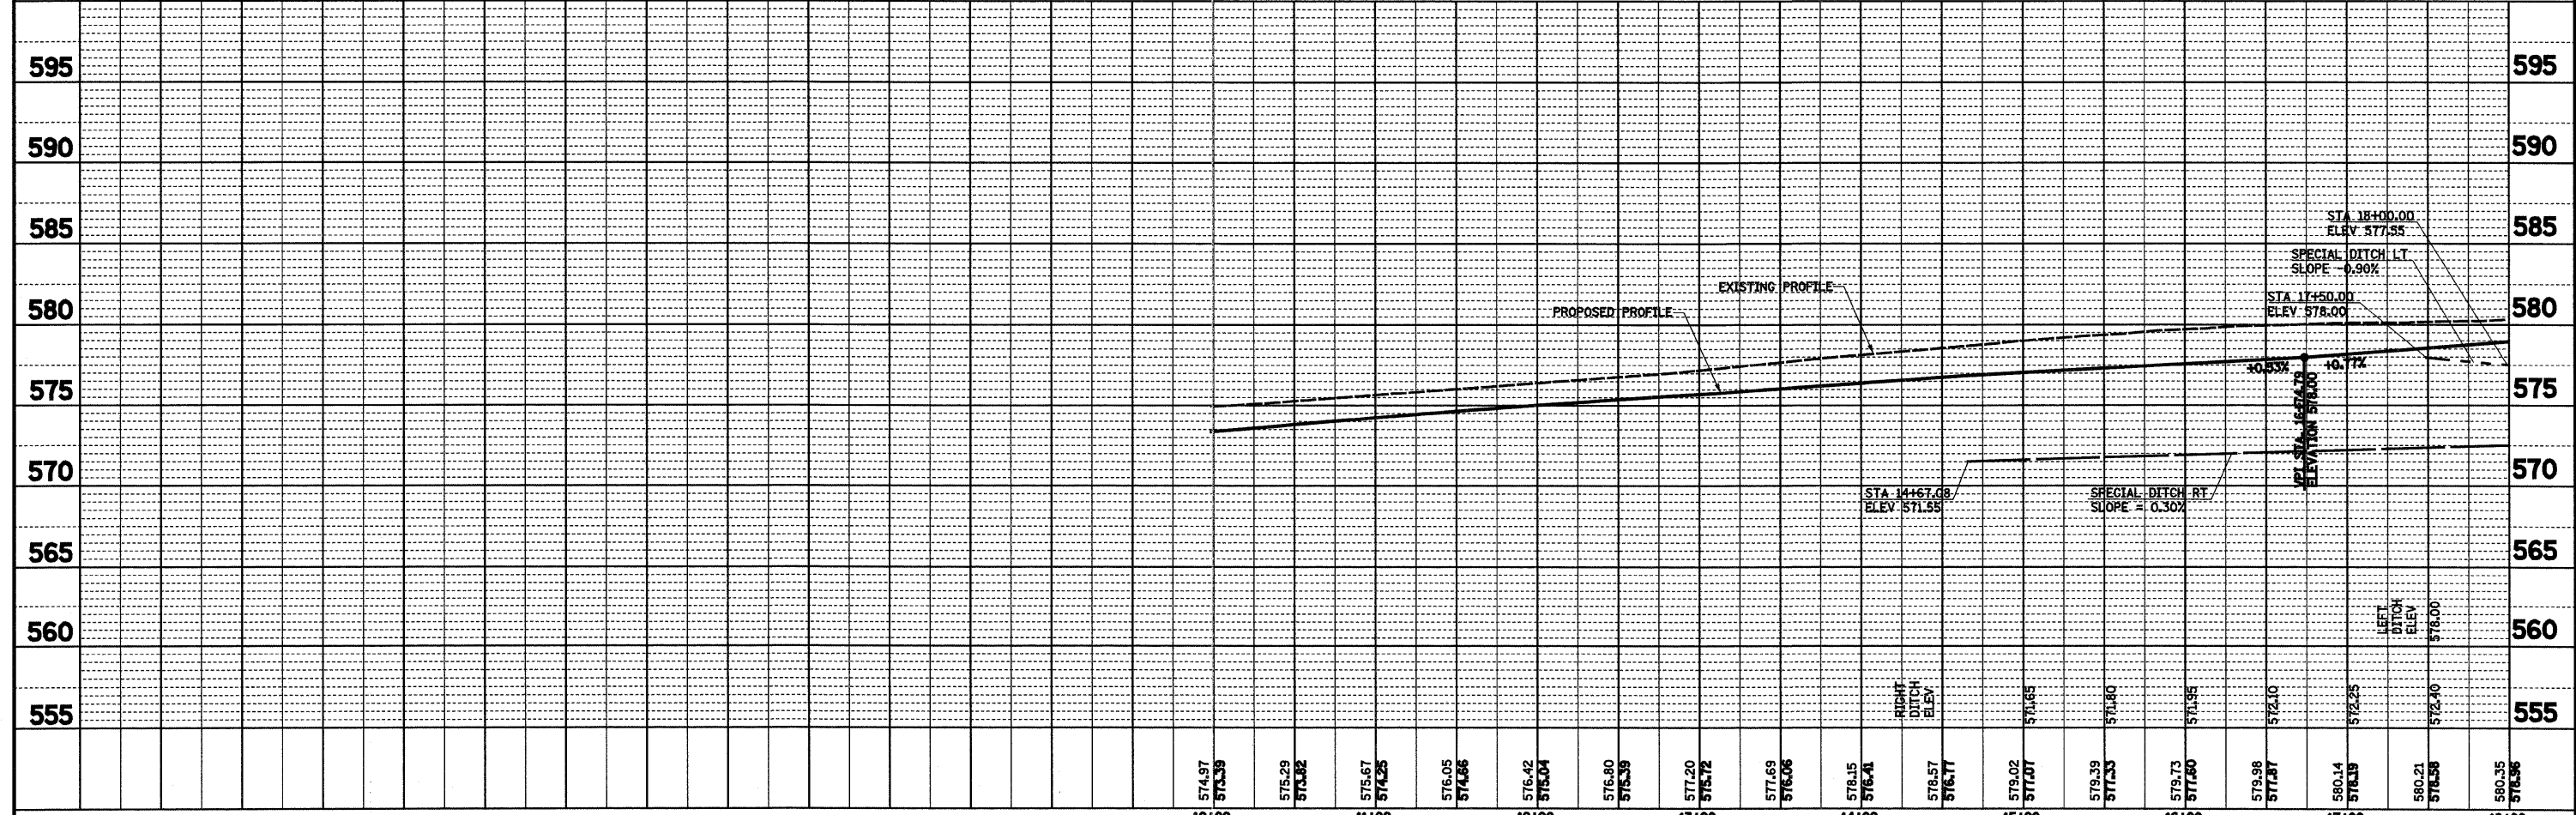


DATE	
BY	
REVIEWED	
PLANNED	
NOTED	
NO.	
FILE NAME	

DATE	
BY	
REVIEWED	
PLANNED	
NOTED	
NO.	
FILE NAME	

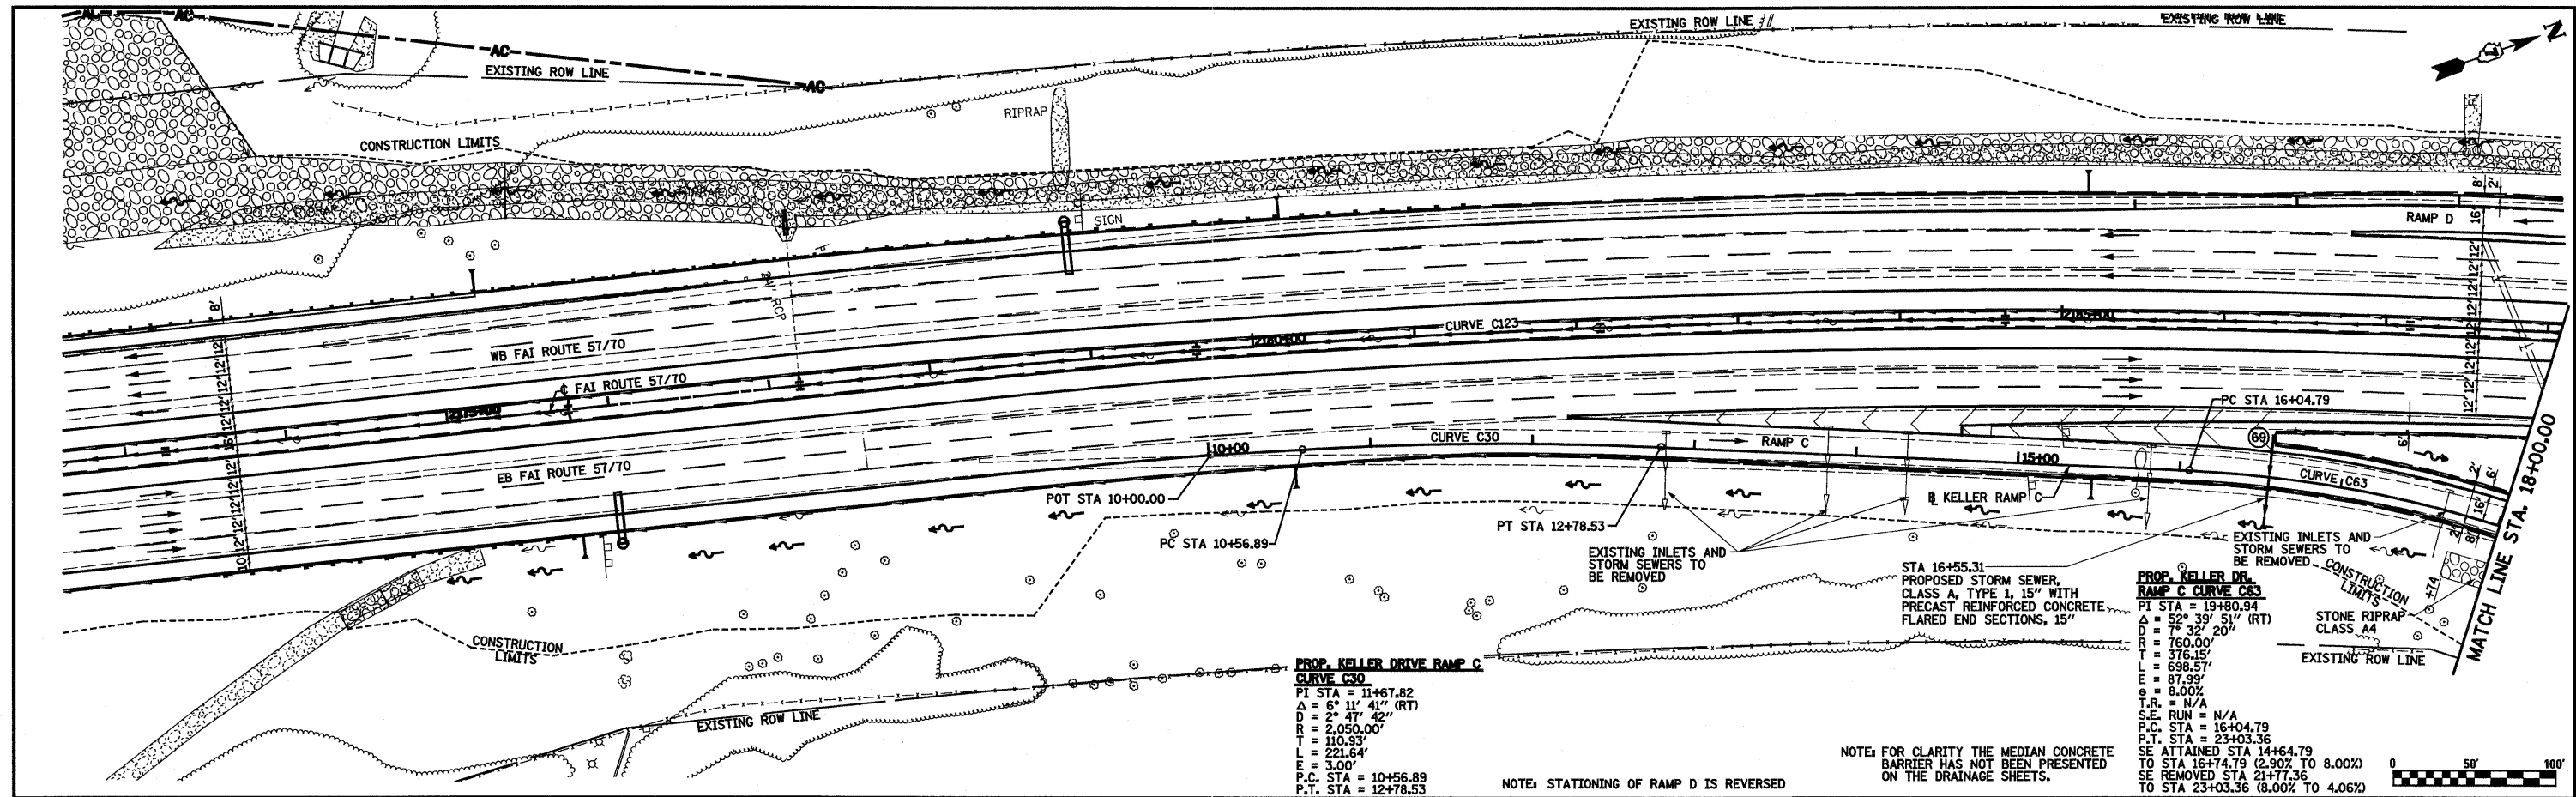

FILE NAME =	USER NAME = bwsbwl	DESIGNED - JWS	REVISED -	STATE OF ILLINOIS DEPARTMENT OF TRANSPORTATION	DRAINAGE PLAN AND PROFILE, KELLER DRIVE - RAMP C	F.A.I. RTE. =	SECTION =	COUNTY =	TOTAL SHEETS =	SHEET NO. =
5\Projects\433\433-257-10.dwg\Keller Drive Ramp C.dwg		DRAWN - PDB	REVISED -			57/70	(25-3,4)R	EFFINGHAM	1098	183
PLOT SCALE = 1/8" = 100.0000' / IN.		CHECKED - BRM	REVISED -			SCALE: 1"=50'	SHEET NO. 5 OF 9 SHEETS	FED. ROAD DIST. NO. =	ILLINOIS FED. AID PROJECT	CONTRACT NO. 74299
PLOT DATE = 3/18/2011		DATE - 4-08-08	REVISED -			STA. 10+00.00 TO STA. 18+00.00				