 



SEE "SCHEDULE OF CABLE AND CONDUIT" AND "SCHEDULE OF LIGHTING EQUIPMENT RELOCATION AND FOUNDATION REPLACEMENT" FOR UNITS AND QUANTITIES



7A OF 16

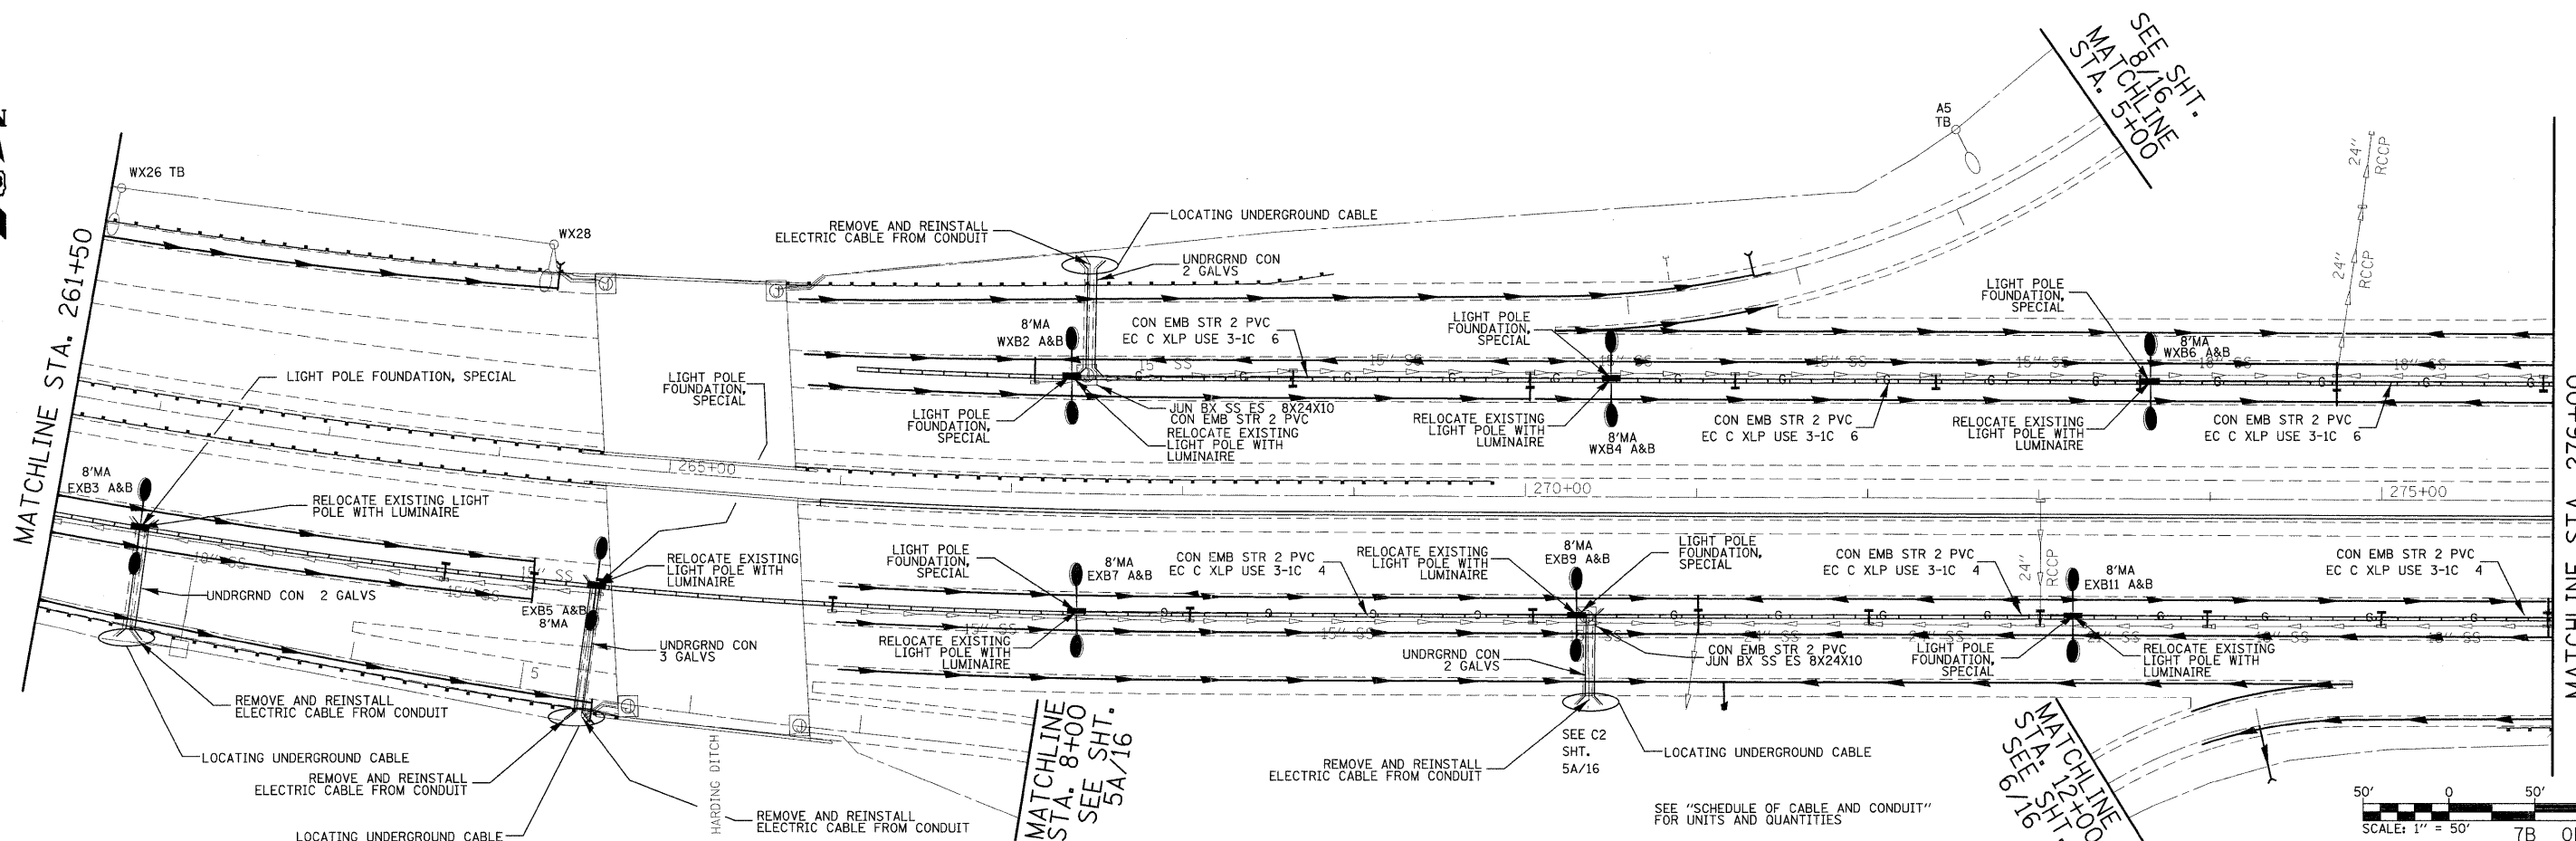

SEE "SCHEDULE OF CABLE AND CONDUIT" FOR UNITS AND QUANTITIES



7B OF 16

FILE NAME =	USER NAME = burnsideem	DESIGNED -	REVISED -
c:\pwork\pwork\burnsideem\2010\9244\876415-shr-light.dgn		DRAWN -	REVISED -
PLOT SCALE = 50.0150' / 1"		CHECKED -	REVISED -
PLOT DATE = 12/6/2011		DATE -	REVISED -

**STATE OF ILLINOIS
DEPARTMENT OF TRANSPORTATION**

**LIGHTING PLANS
CONTROLLERS #18 & #19 SHTS. 4A & 4B OF 10**

SCALE: _____ SHEET NO. ____ OF ____ SHEETS STA. _____ TO STA. _____

F.A.I. RTE.	SECTION	COUNTY	TOTAL SHEETS	SHEET NO.
64	82-(3-4)RS	ST. CLAIR	167	91
FED. ROAD DIST. NO. - [ILLINOIS] FED. AID PROJECT			CONTRACT NO. 76415	