
 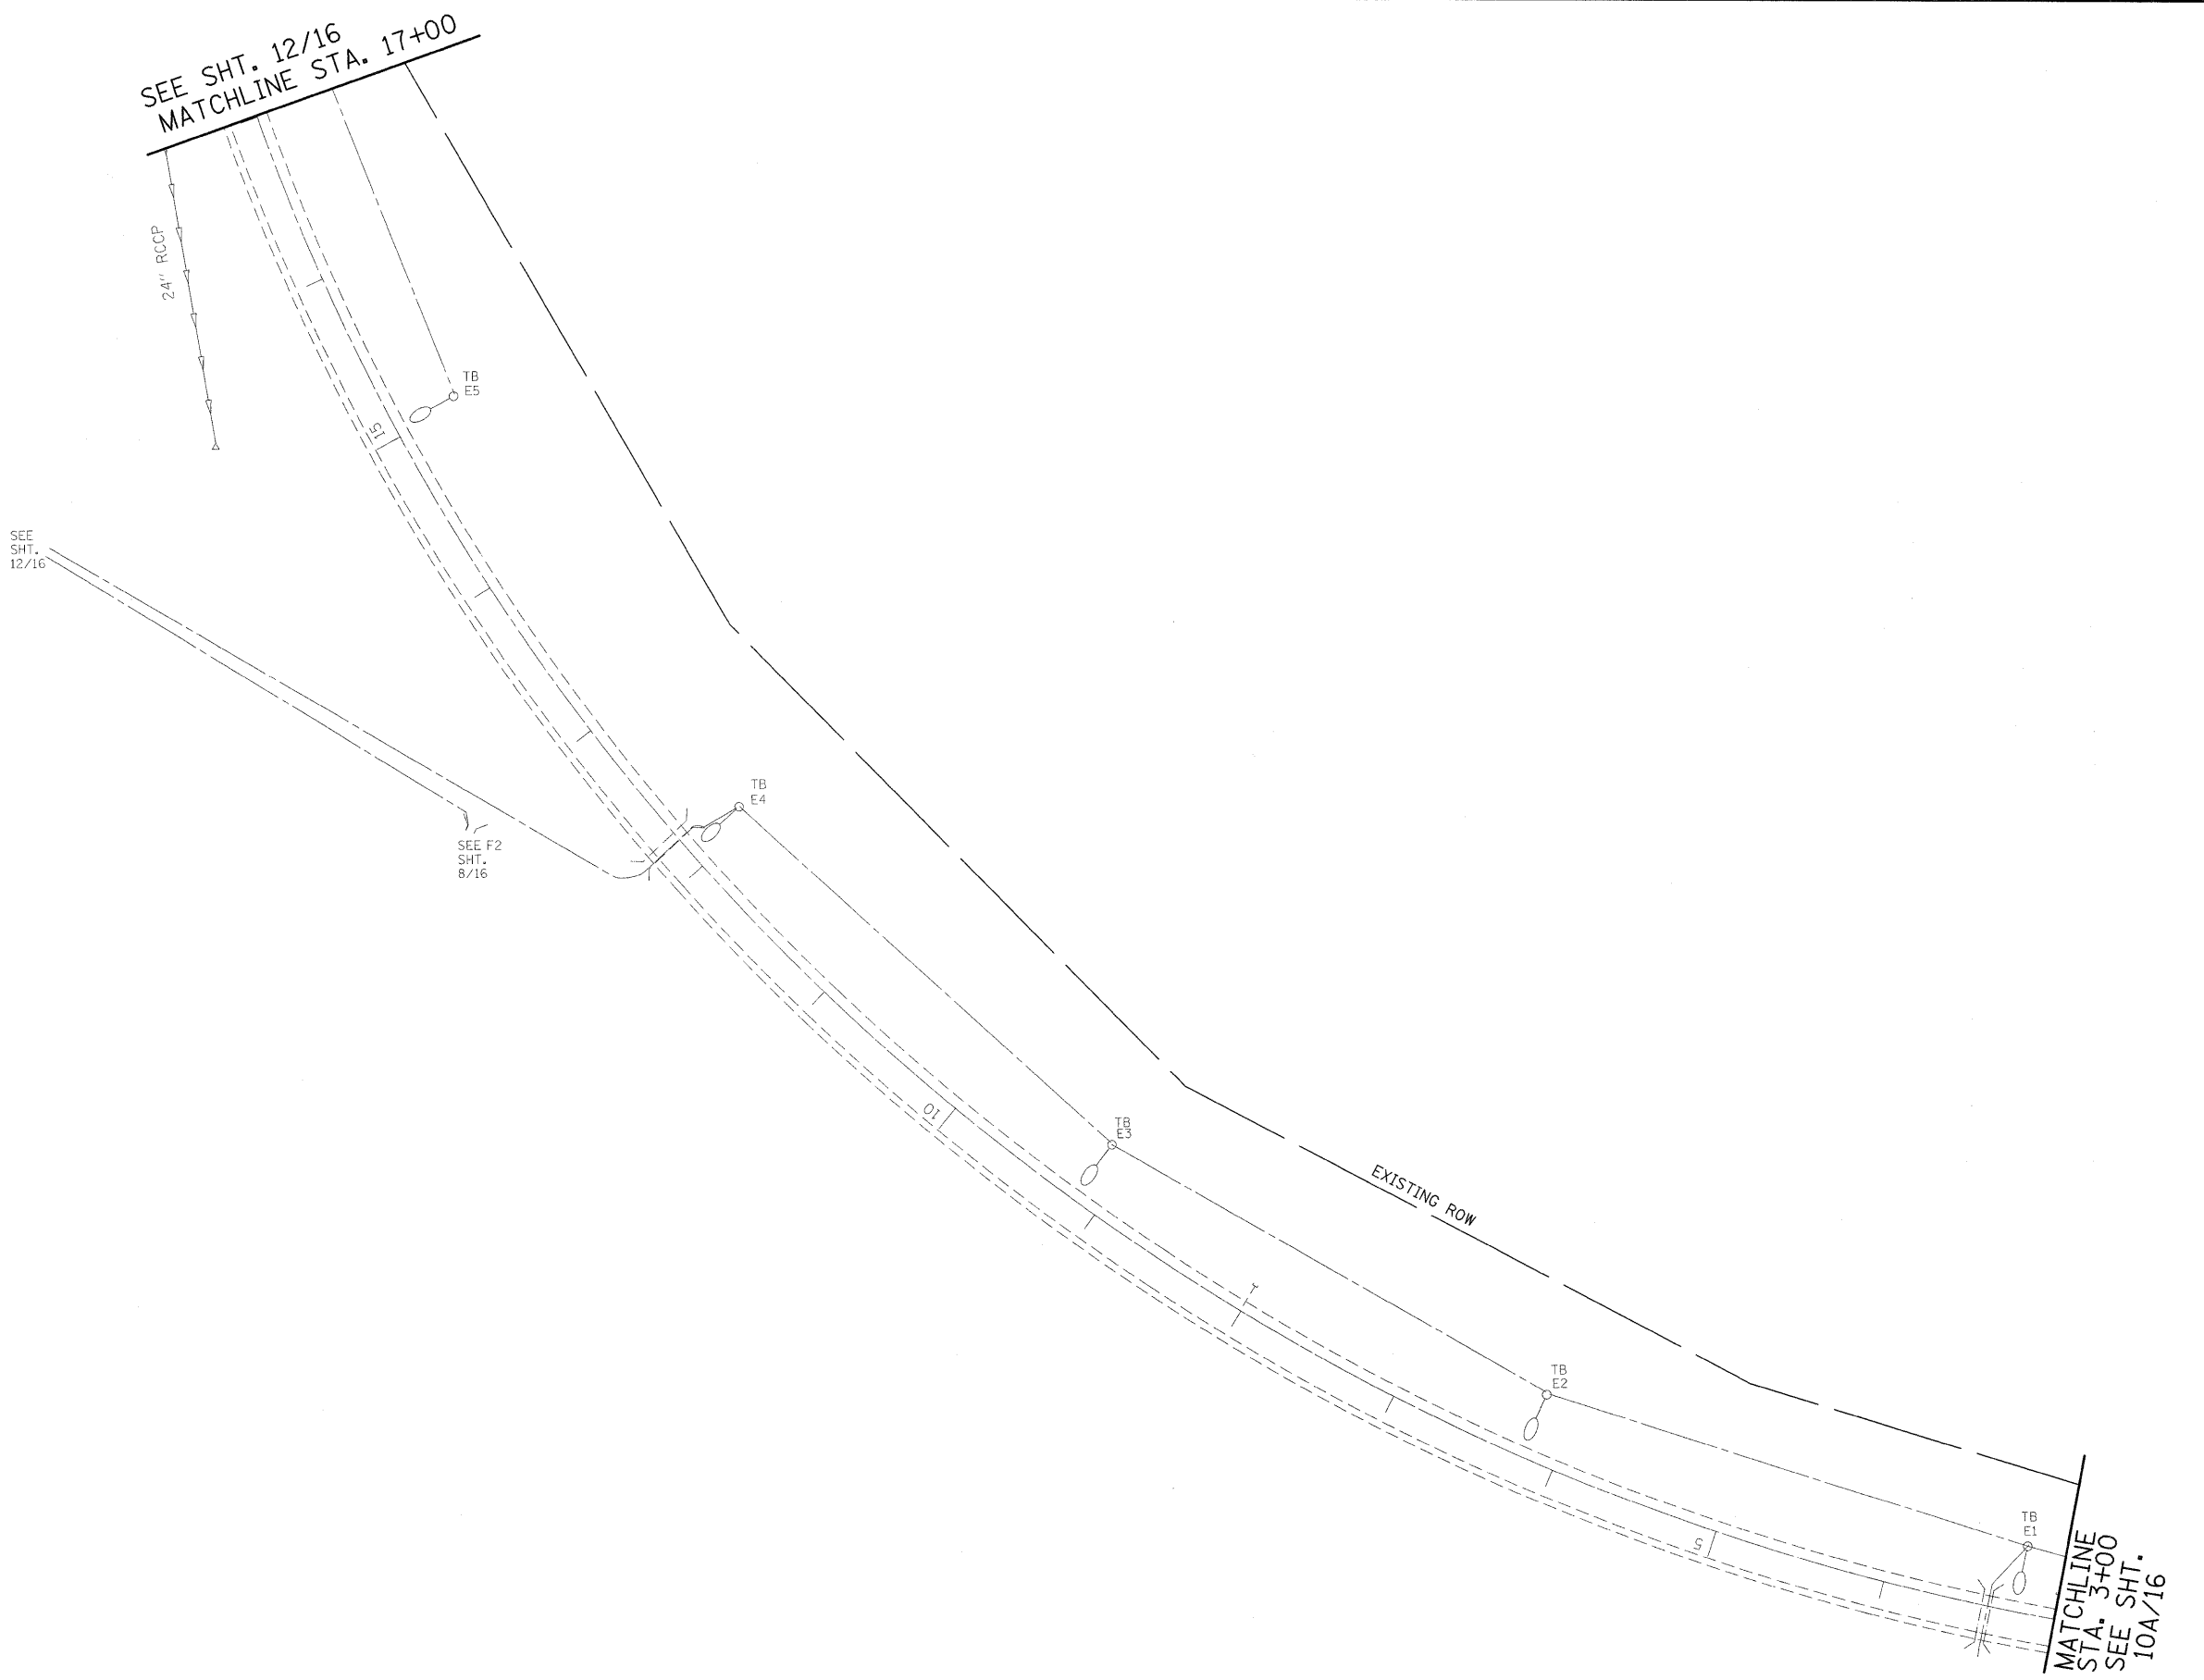


SEE SHT. 12/16
MATCHLINE STA. 17+00

SEE SHT. 12/16

SEE F2
SHT. 8/16



MATCHLINE
STA. 3+00
SEE SHT.
10A/16

FOR INFORMATION, ONLY

11 OF 16

FILE NAME = c:\pw_work\pw\dot\burnsideem\10109244\0876415-sht-light.dgn	USER NAME = burnsideem	DESIGNED -	REVISED -	STATE OF ILLINOIS DEPARTMENT OF TRANSPORTATION	LIGHTING PLANS CONTROLLERS #18 & #19 SHTS. 8 OF 10			F.A.I. RTE: 64	SECTION 82-(3-4)RS	COUNTY ST. CLAIR	TOTAL SHEETS 167	SHEET NO. 95	
	PLDT SCALE = 50.8349 / / in.	CHECKED -	REVISED -		SCALE: _____	SHEET NO. _____ OF _____ SHEETS	STA. _____ TO STA. _____	CONTRACT NO. 76415					
	PLDT DATE = 12/6/2011	DATE -	REVISED -		FED. ROAD DIST. NO. - [ILLINOIS] FED. AID PROJECT								