

SEE SHT. 8/16
MATCHLINE STA. 9+50




SEE SHT. 8/16
MATCHLINE STA. 1058+00

SEE F2
SHT. 8/16


SEE
SHT. 8/16

SEE SHT. 17/16
MATCHLINE STA. 17+00

MATCHLINE STA. 1071+50
SEE SHT. 13A/16

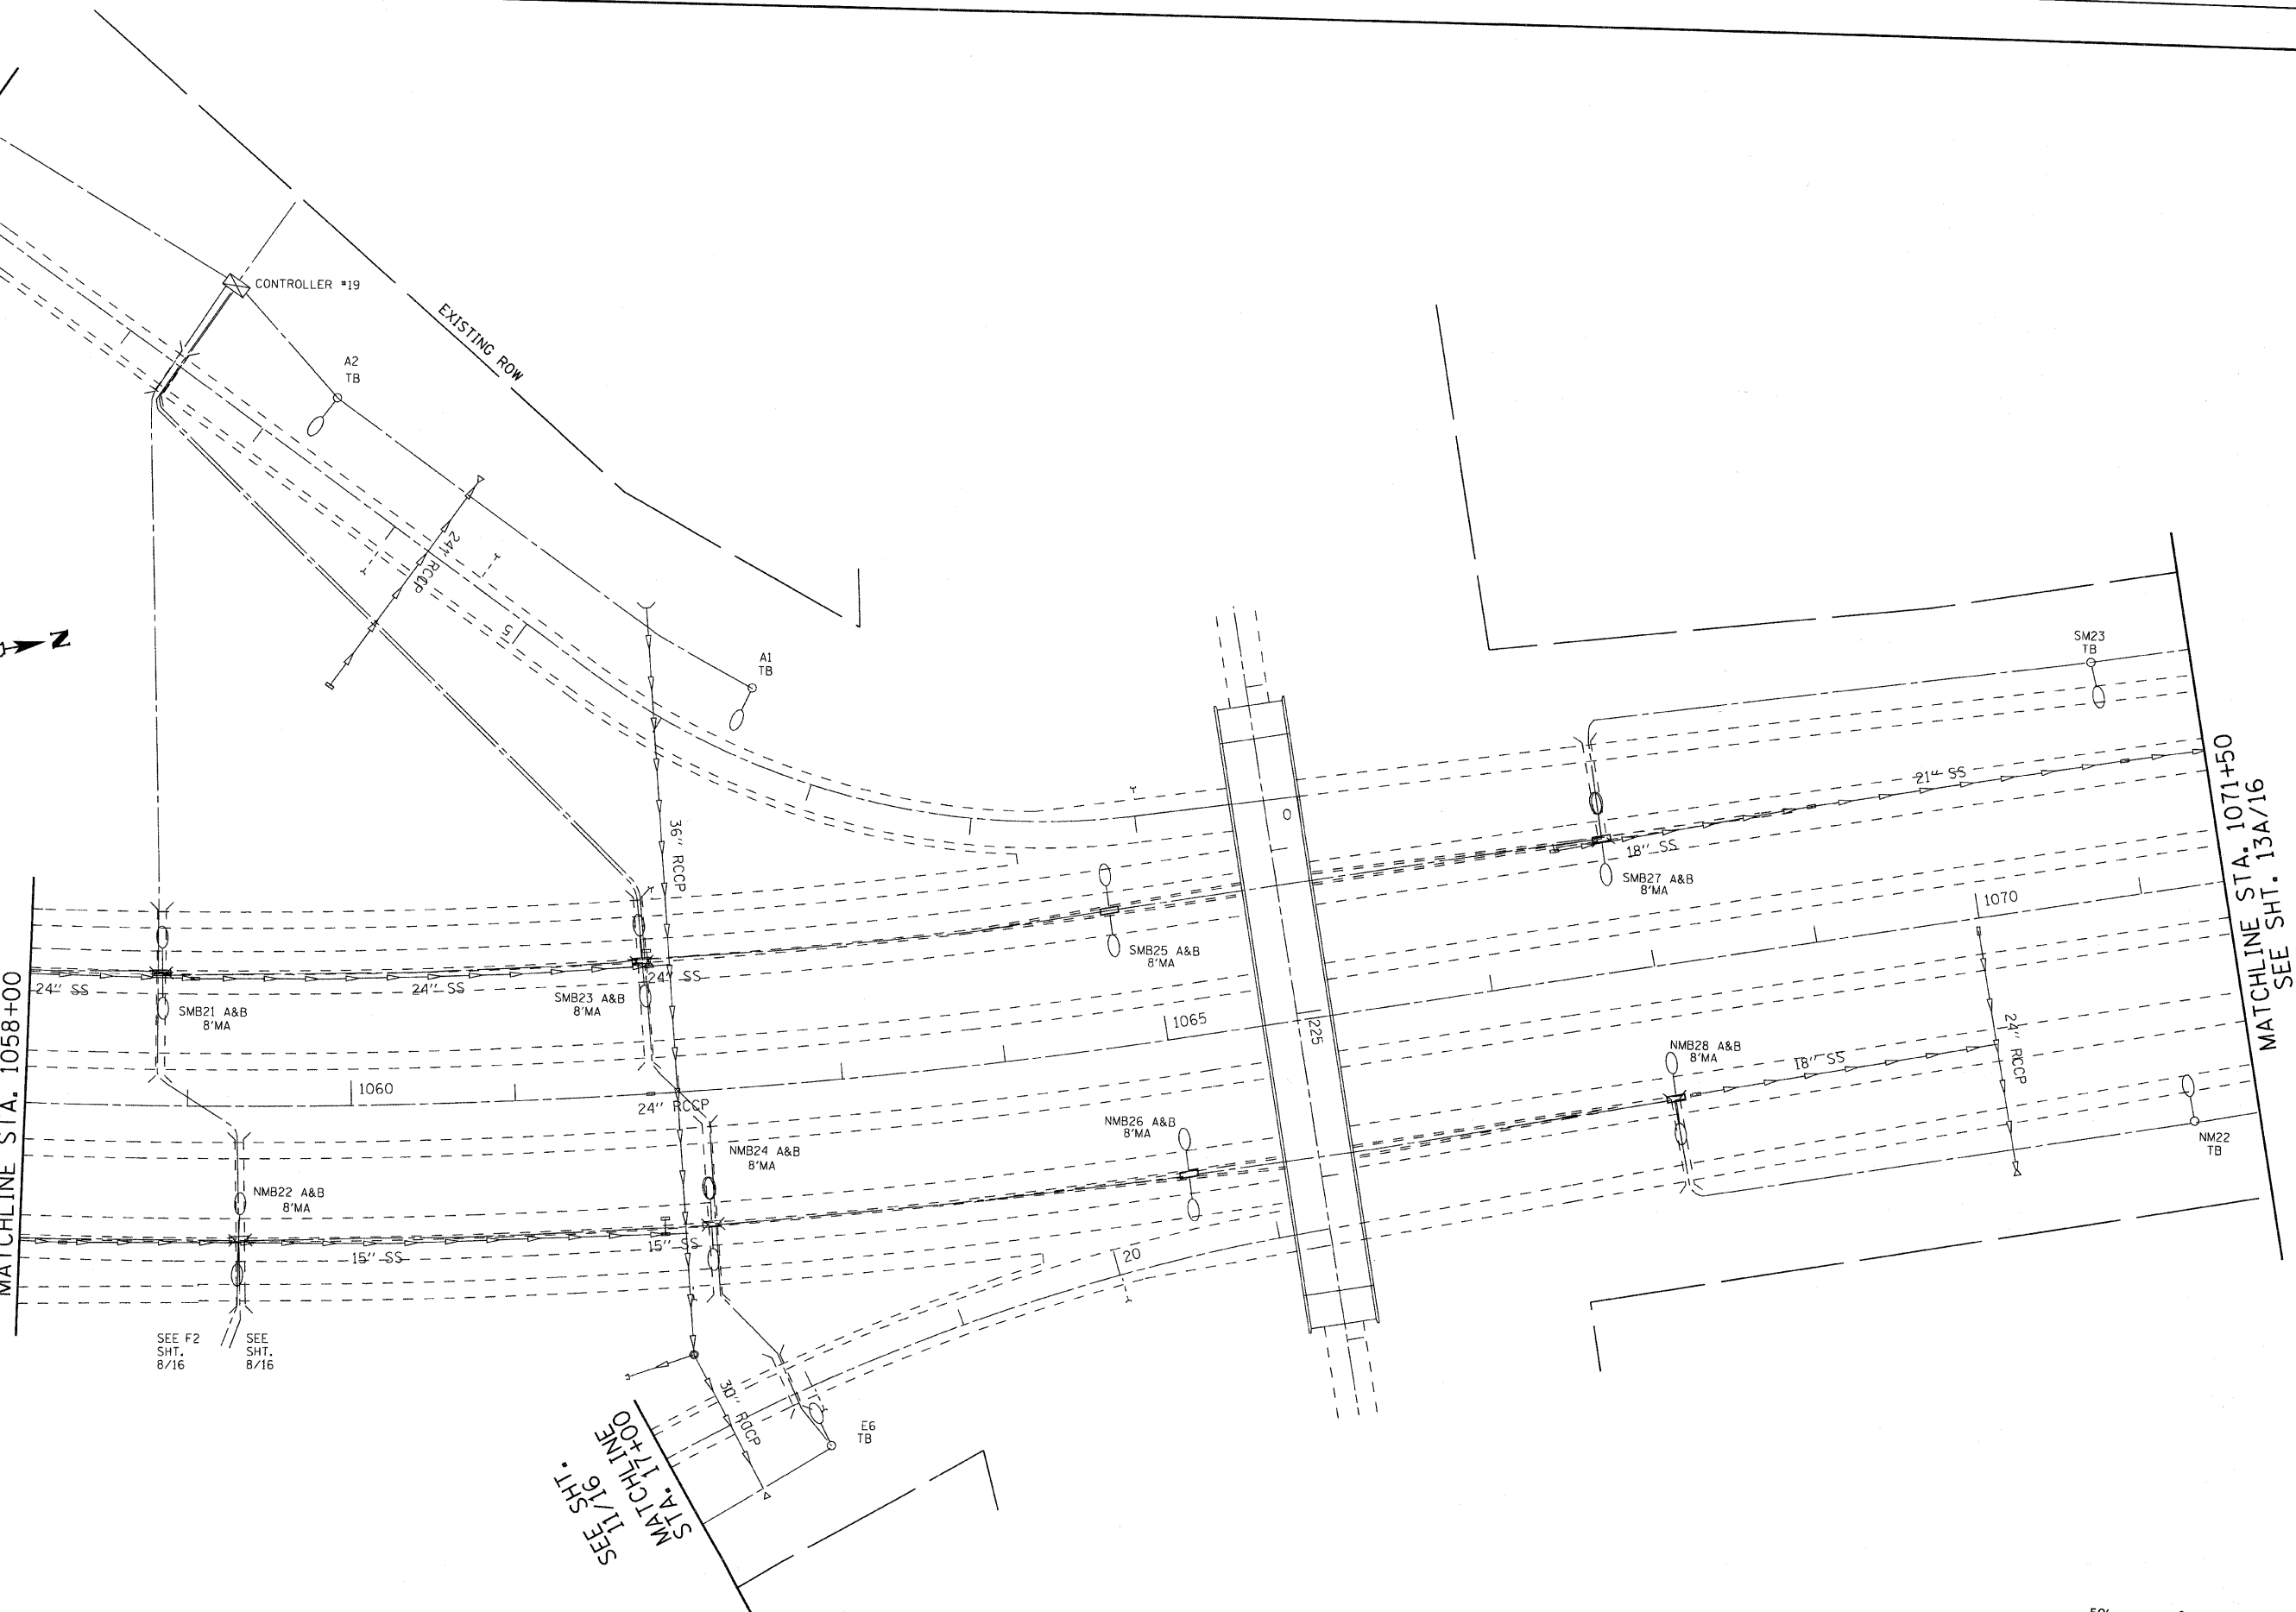

FOR INFORMATION, ONLY

 

FILE NAME =	USER NAME = prestonm	DESIGNED -	REVISED -
c:\pwork\p\pidot\prestonm\d0109244\d0	76415-sh1-light.dgn	DRAWN -	REVISED -
	PLOT SCALE = 49.9958 / in.	CHECKED -	REVISED -
	PLOT DATE = 12/7/2011	DATE -	REVISED -

STATE OF ILLINOIS
DEPARTMENT OF TRANSPORTATION

LIGHTING PLANS
CONTROLLERS #18 & #19 SHTS. 9 OF 10

SCALE: SHEET NO. OF SHEETS STA. TO STA.

F.A.I. RTE.	SECTION	COUNTY	TOTAL SHEETS	SHEET NO.
64	82-13-4RS	ST. CLAIR	167	96
CONTRACT NO. 76415				