
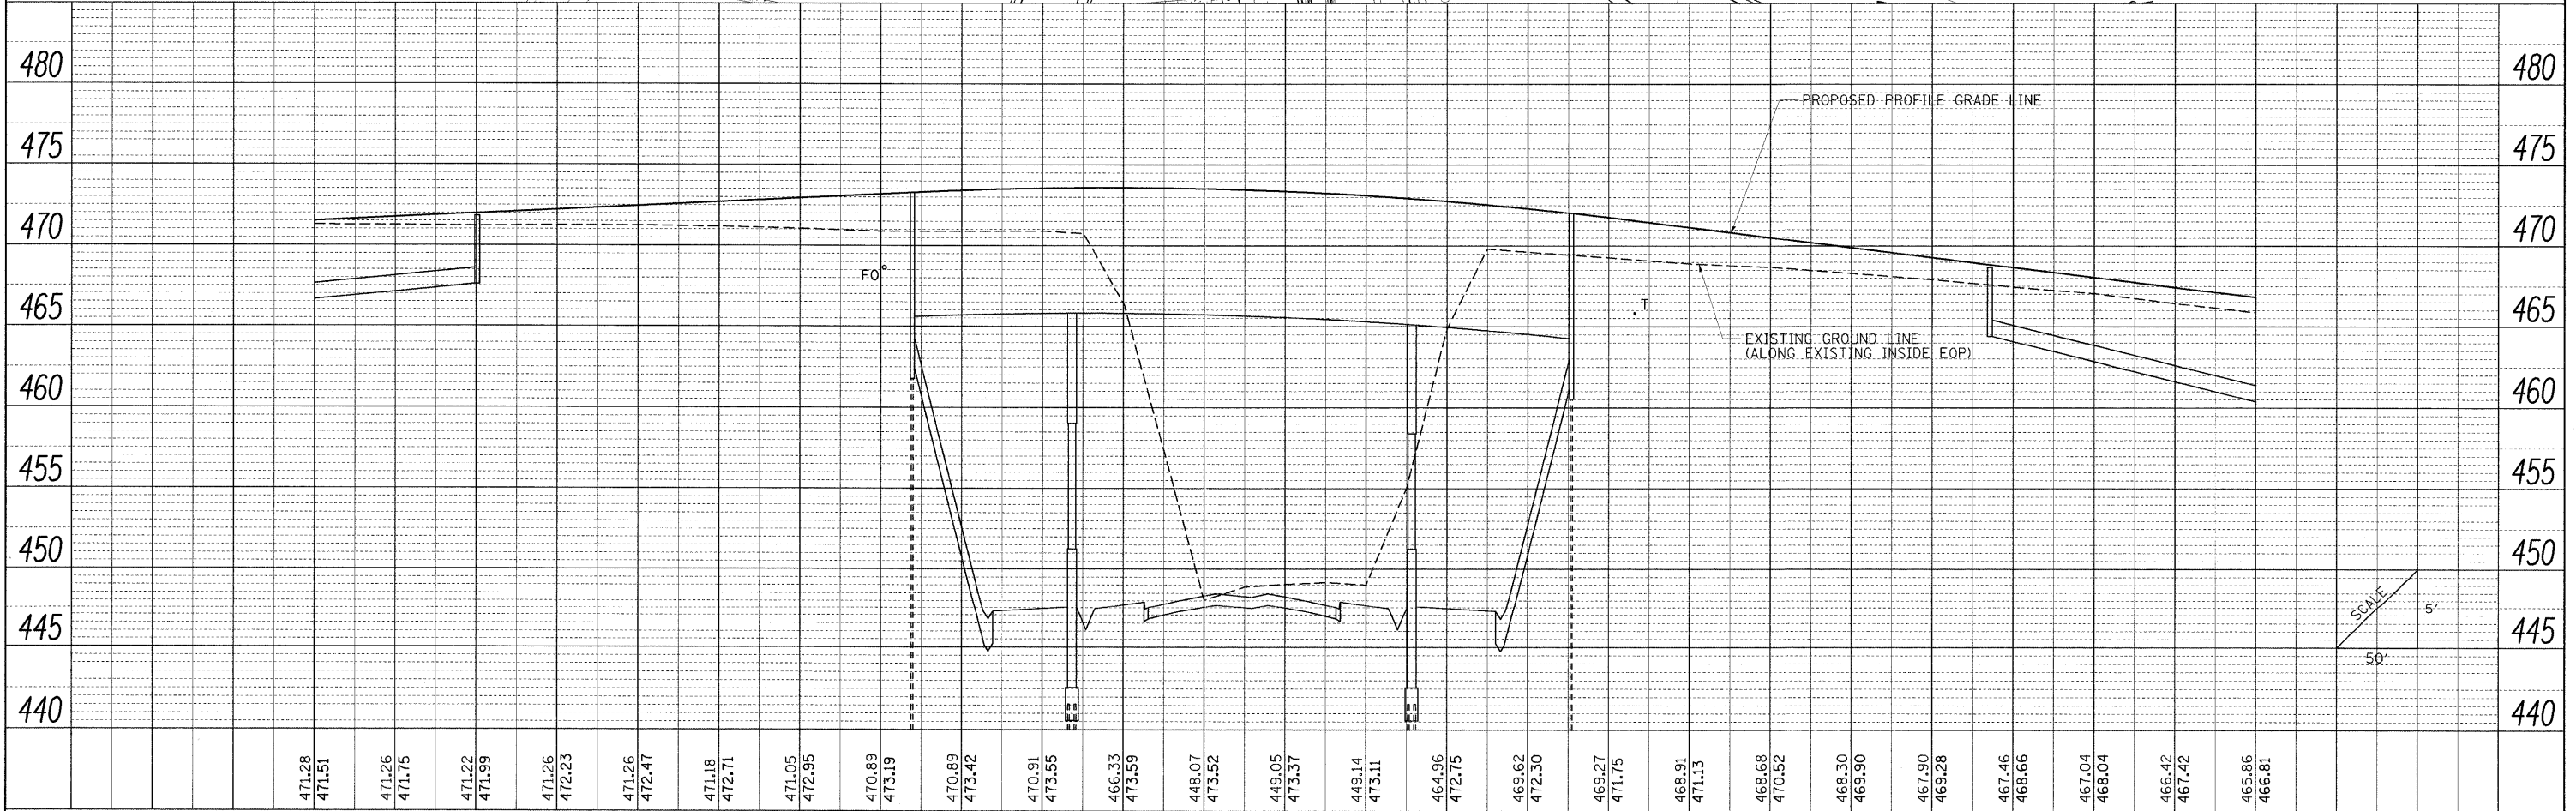


PLAN
NO.
DATE

PROF FILE
NO.
DATE

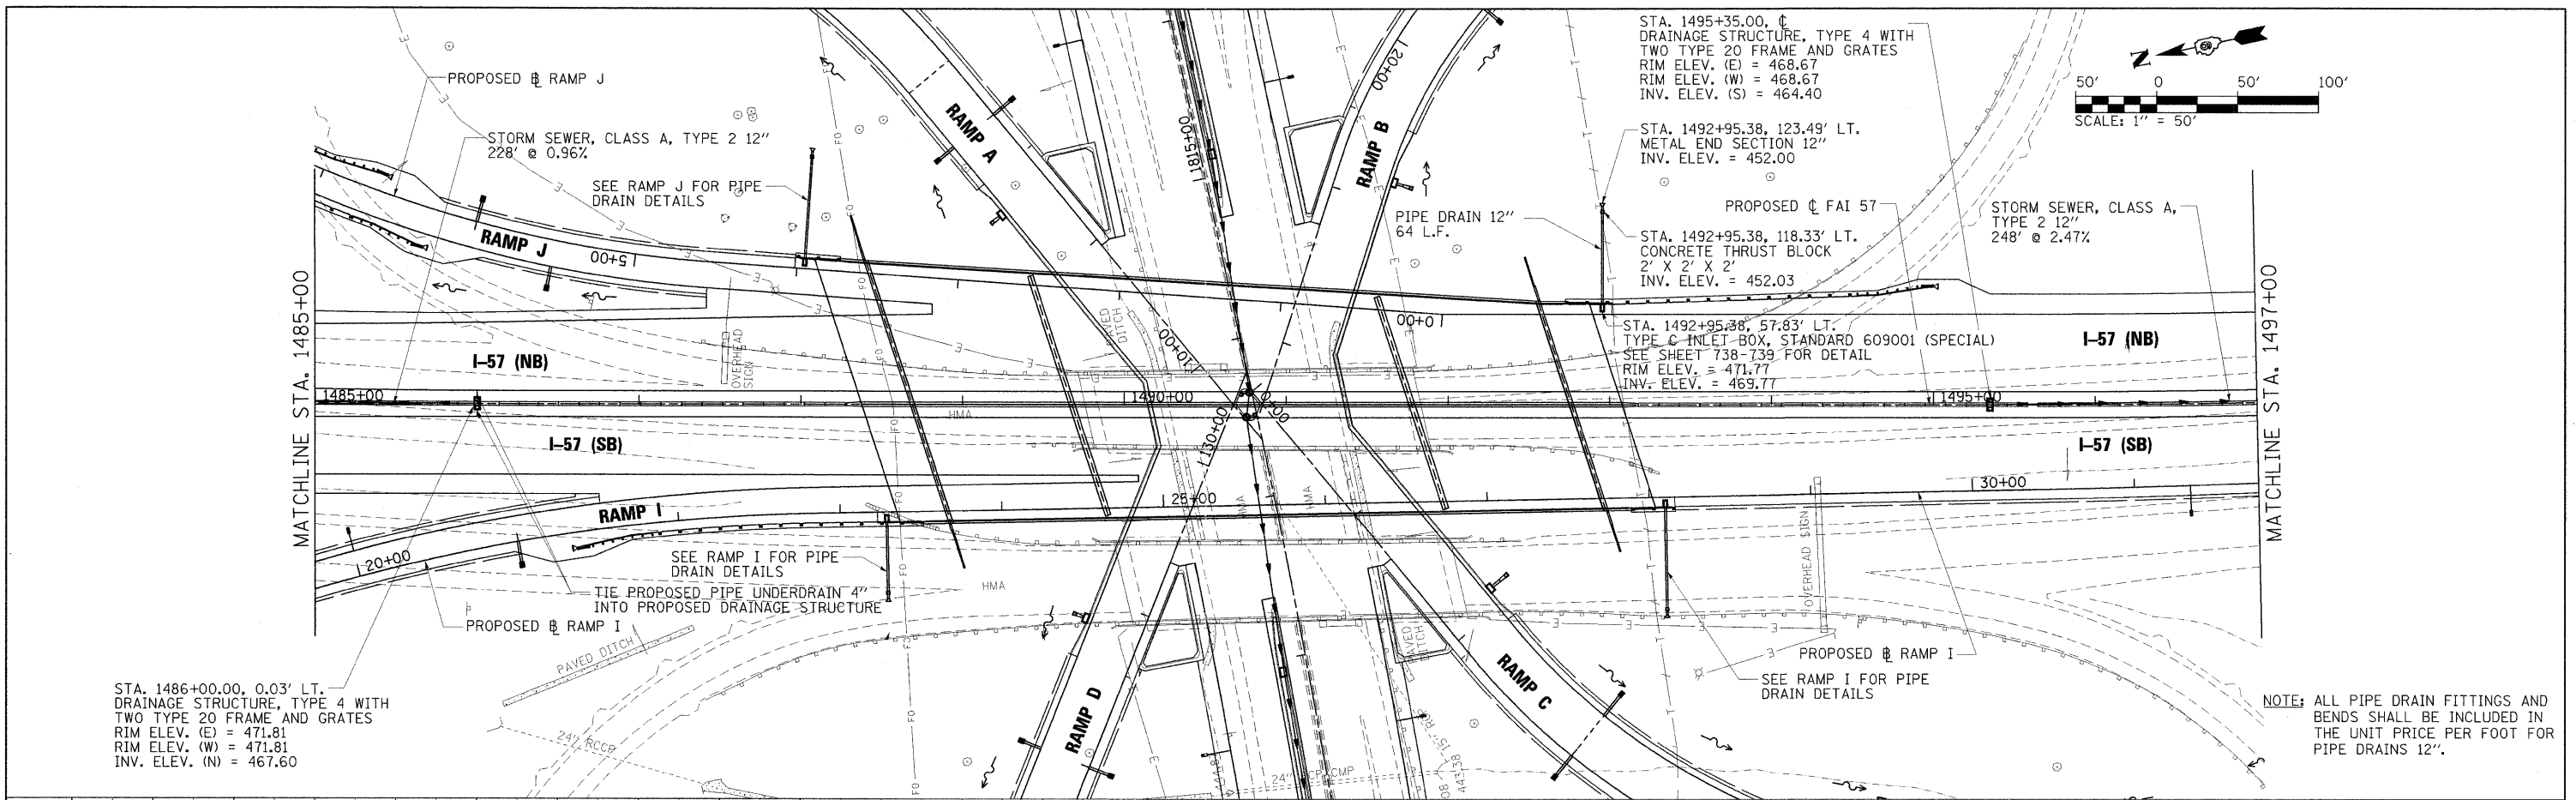

FILE NAME =	USER NAME = Brad Dowden	DESIGNED - SCD / BMB	REVISED -	STATE OF ILLINOIS DEPARTMENT OF TRANSPORTATION				DRAINAGE PLAN AND PROFILE INTERSTATE 57			F.A. RTE.	SECTION	COUNTY	TOTAL SHEETS	SHEET NO.
...\\0978182-sht-drain157-204.dgn		DRAWN - JEB / RAH	REVISED -					SCALE: 1" = 50' SHEET NO. OF SHEETS STA. 1485+00 TO STA. 1497+00			* 01-6-2HKB-2, HB-1,2; 01-1R-1	WILLIAMSON	968	305	
	PLOT SCALE = 50.0000' / IN.	CHECKED - SCD / BJD	REVISED -												* F.A.I. 57 AND F.A.P. 331
	PLOT DATE = 10/12/2011	DATE = 10/07/11	REVISED -								ILLINOIS FED. AID PROJECT				