

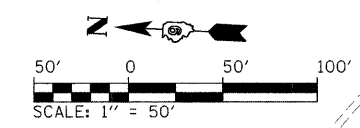


PLAN	SURVEYED	DATE
	PLOTTED	
	NOTED	
	BY	
	NO.	
	ADD FILE NAME	

PROFILE	SURVEYED	DATE
	PLOTTED	
	NOTED	
	BY	
	NO.	
	ADD FILE NAME	

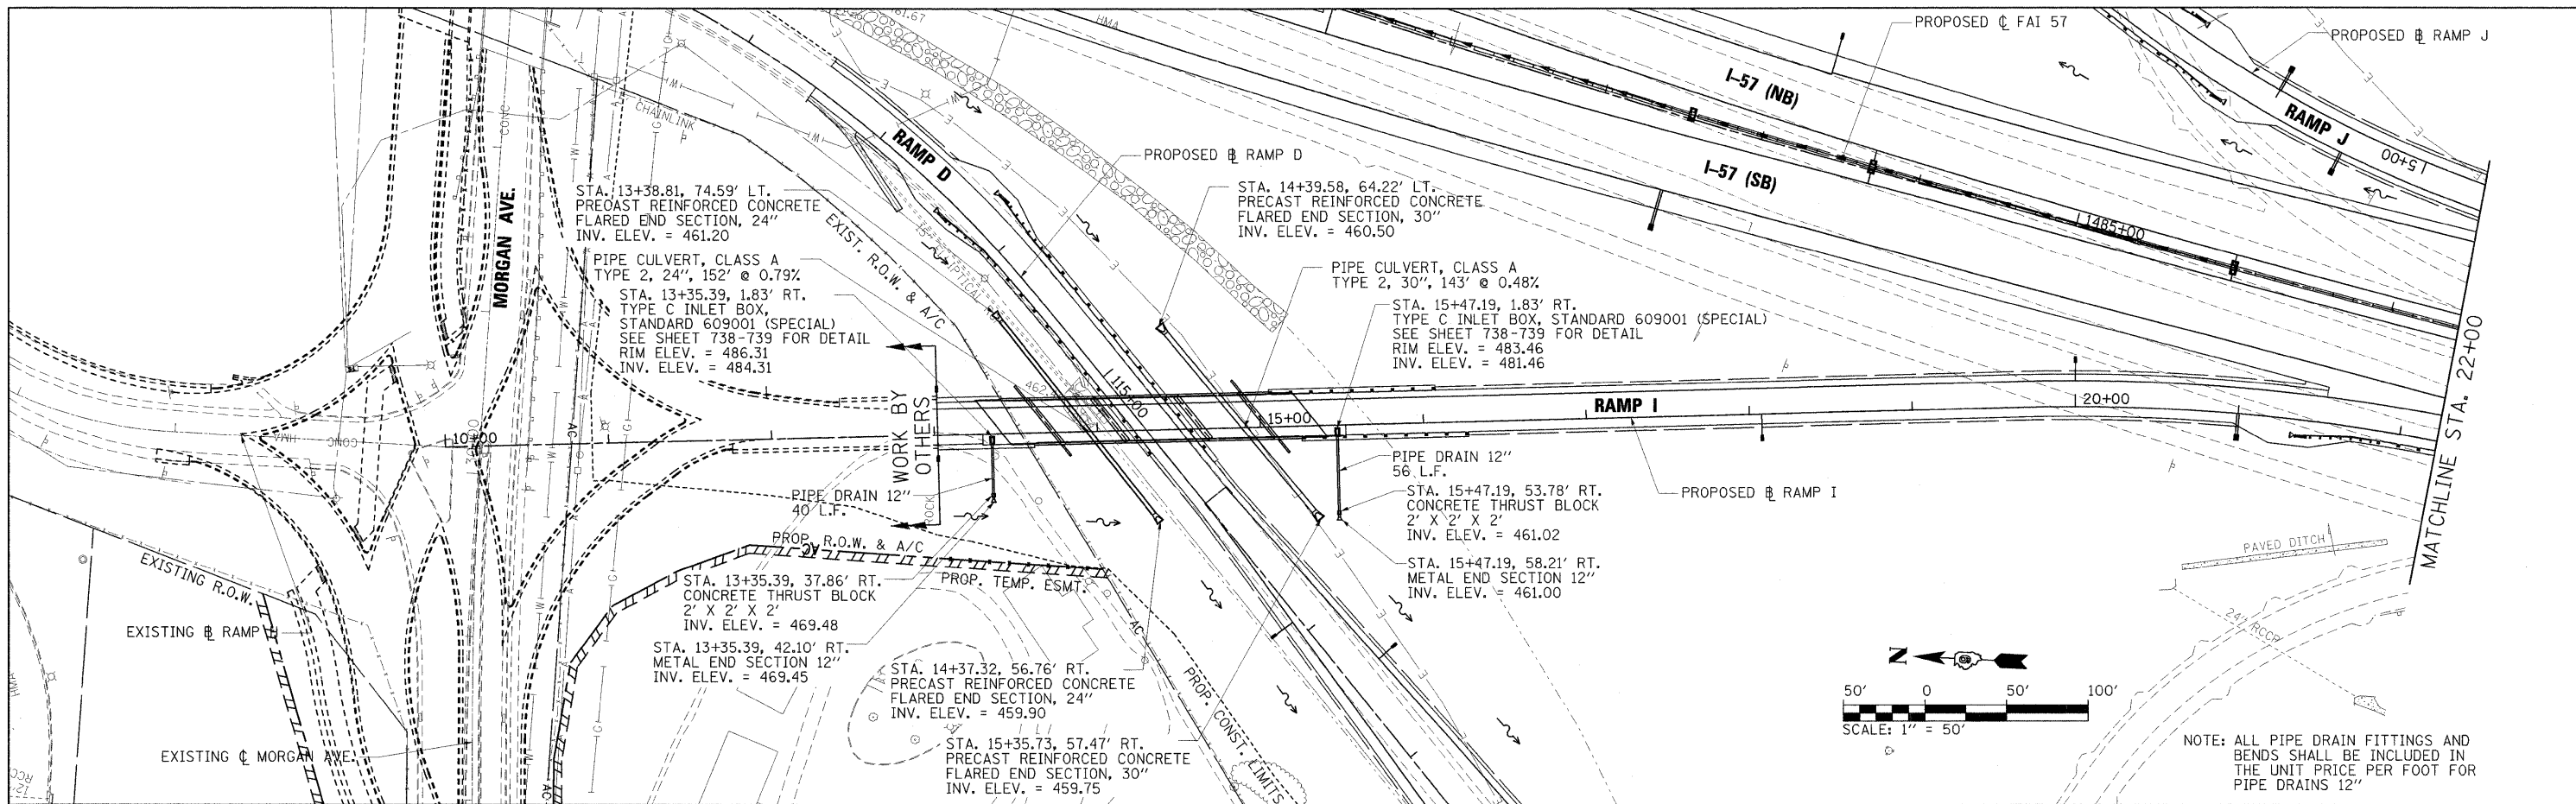

NOTE: ALL PIPE DRAIN FITTINGS AND BENDS SHALL BE INCLUDED IN THE UNIT PRICE PER FOOT FOR PIPE DRAINS 12"

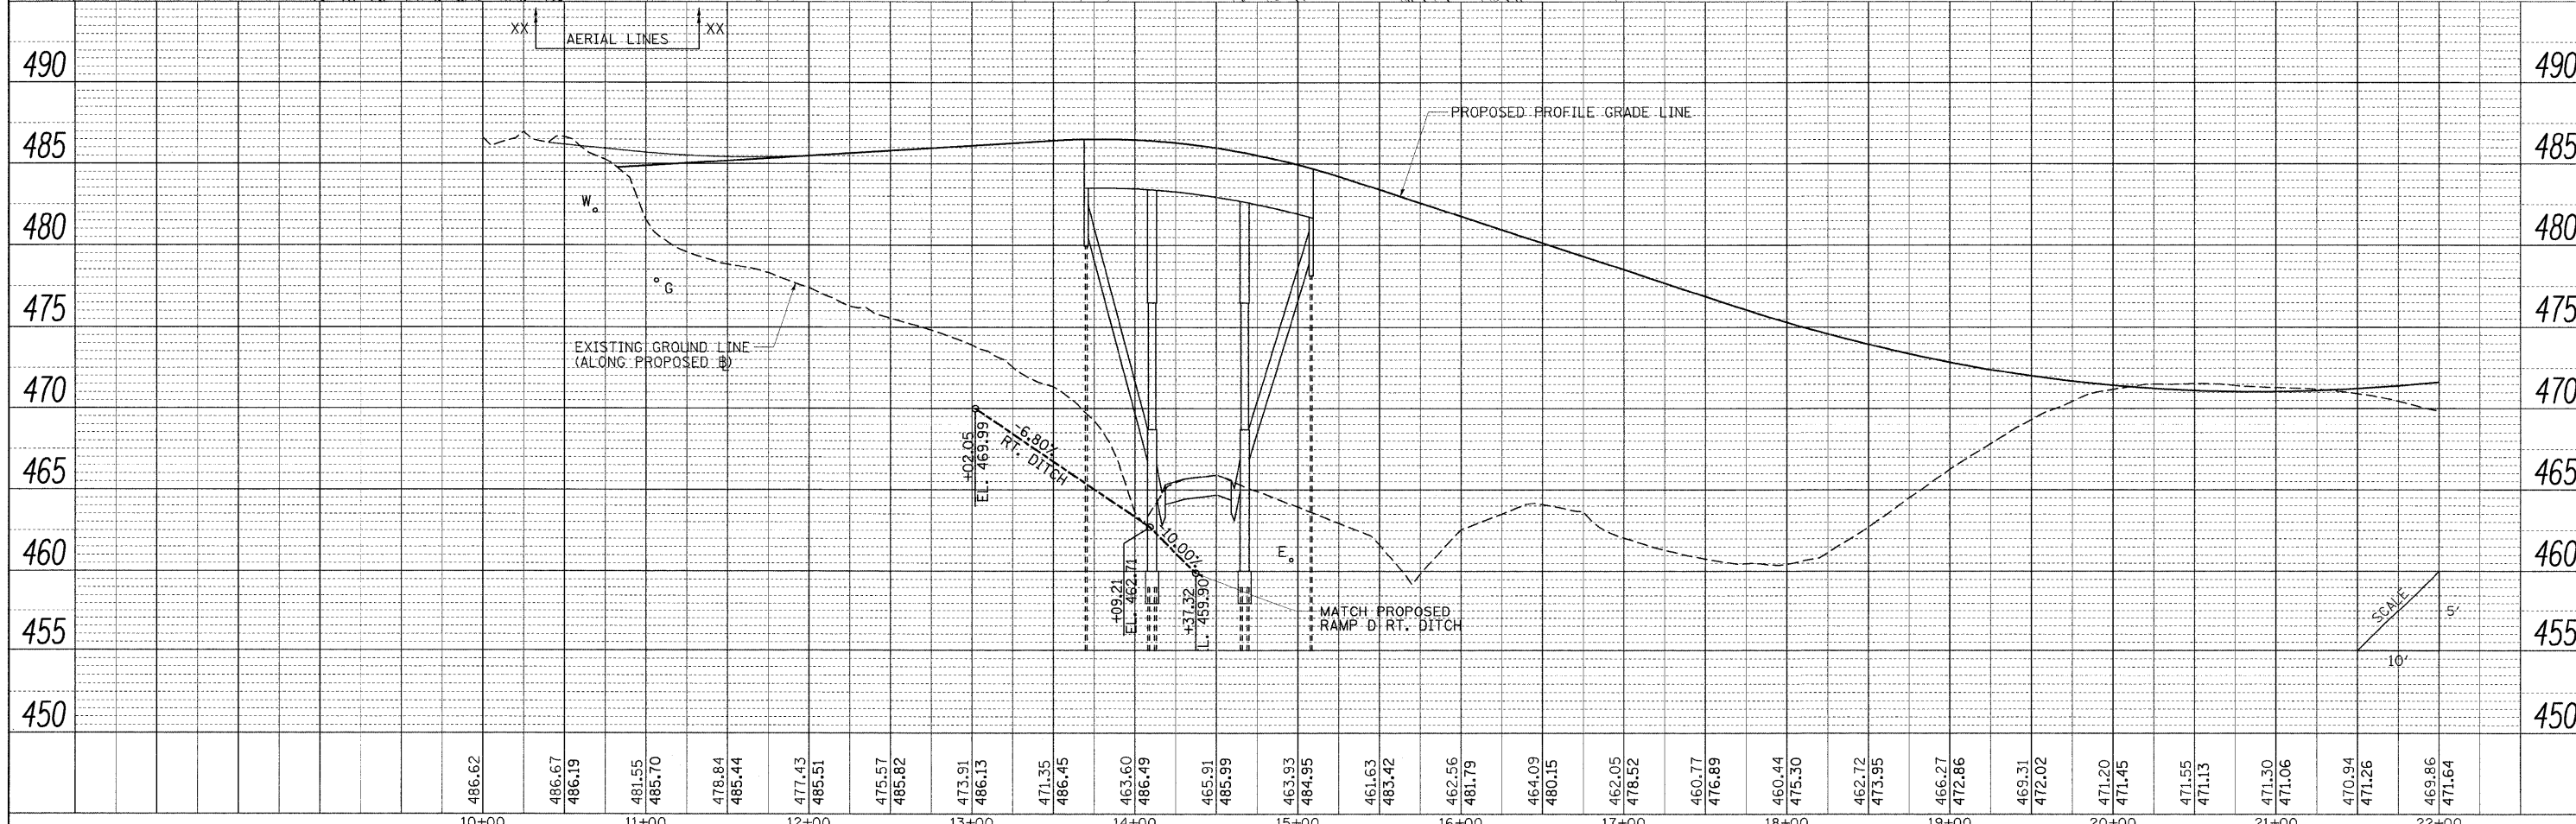

FILE NAME =	USER NAME = Brad Downen	DESIGNED - SCD / BMB	REVISED -	STATE OF ILLINOIS DEPARTMENT OF TRANSPORTATION	DRAINAGE PLAN AND PROFILE RAMP I		F.A. RTE.	SECTION	COUNTY	TOTAL SHEETS	SHEET NO.
... \0978182-sht-drainRAMP1-023.dgn		DRAWN - JEB / RAH	REVISED -		SCALE: 1" = 50'	SHEET NO. OF SHEETS	STA. 0+00 TO STA. 12+00	(X1-6-2)HBK-2, HB-1,2; (X1-1R-1)	WILLIAMSON	968	324
		CHECKED - SCD / BJD	REVISED -					* F.A.I. 57 AND F.A.P. 331	CONTRACT NO. 78182		
		DATE - 10/07/11	REVISED -					ILLINOIS FED. AID PROJECT			