


REMOVAL LEGEND

	PAVEMENT REMOVAL
	PAVED SHOULDER REMOVAL
	MEDIAN REMOVAL
	HOT-MIX ASPHALT SURFACE REMOVAL, BUTT JOINT
	HOT-MIX ASPHALT SURFACE REMOVAL, VARIABLE DEPTH
	DRIVEWAY PAVEMENT REMOVAL
	COMBINATION CURB AND GUTTER REMOVAL
	TREE REMOVAL

- NOTES:**
1. SEE SCHEDULE OF QUANTITIES FOR REMOVAL DETAILS AND QUANTITIES.
 2. SEE SIGNING AND LIGHTING PLANS FOR SIGNING AND LIGHTING REMOVALS.
 3. SEE DRAINAGE PLAN AND PROFILE SHEETS AND CULVERT PROFILES FOR LIMITS OF PARTIAL CULVERT REMOVAL.

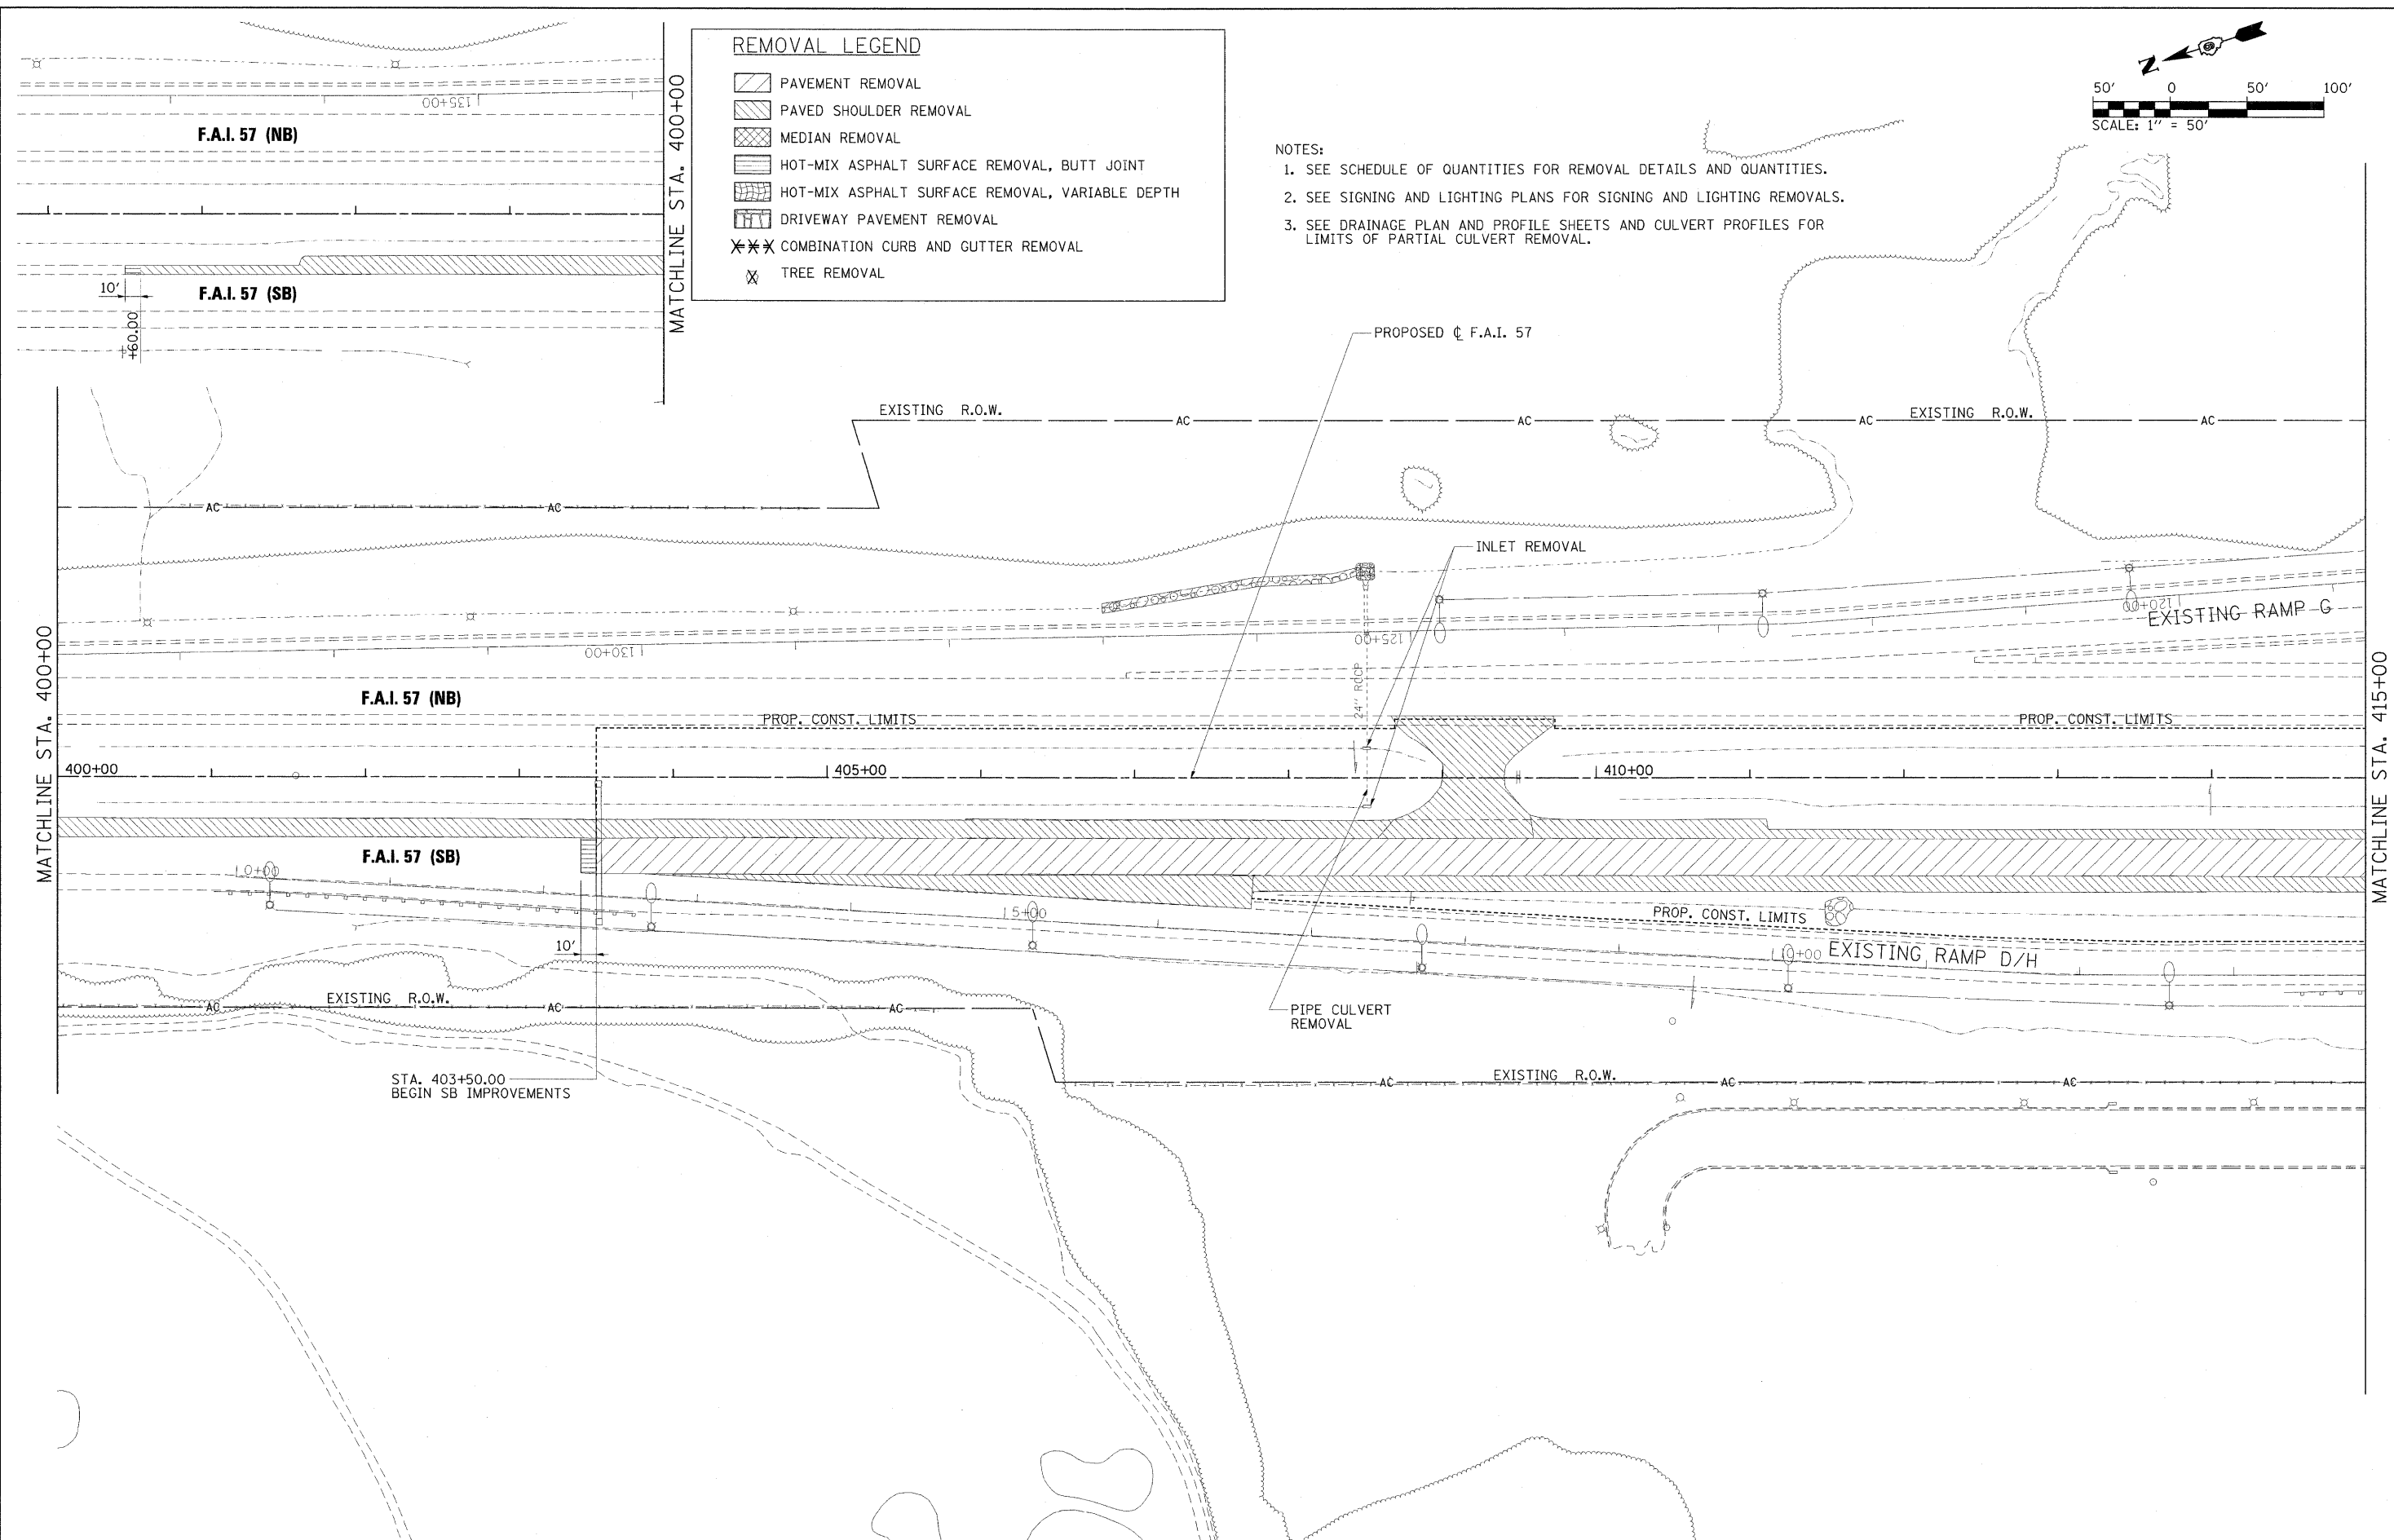

FILE NAME = ...D978162*shtr-em-157_002.dgn	USER NAME = Rob Heady	DESIGNED - MKW	REVISED -	STATE OF ILLINOIS DEPARTMENT OF TRANSPORTATION	REMOVAL PLAN INTERSTATE 57	F.A. RTE.	SECTION	COUNTY	TOTAL SHEETS	SHEET NO.
	PLOT SCALE = 50.0000 "/> <td>DRAWN - MKW</td> <td>REVISED -</td> <td>* 0X1-6-2IHBK-2, HB-1,2; 1X-1R-1</td> <td>WILLIAMSON</td> <td>968</td> <td>339</td>	DRAWN - MKW	REVISED -			* 0X1-6-2IHBK-2, HB-1,2; 1X-1R-1	WILLIAMSON	968	339	
	PLOT DATE = 10/7/2011	CHECKED - BJD	REVISED -			* F.A.I. 57 AND F.A.P. 331	CONTRACT NO. 78182	ILLINOIS FED. AID PROJECT		
		DATE - 10/07/11	REVISED -			SCALE: 1" = 50'	SHEET NO. OF SHEETS	STA. 400+00 TO STA. 415+00		