

ROUTE	SECTION	COUNTY	TOWNSHIP	TOTAL SHEETS	SHEET NUMBER
FAS 1919	06-00144-00-WR	JACKSON	MAKANDA	91	1
JOB NO. C-99-579-06			PROJECT NO. SR-1919(106)		
BOSKYDELL ROAD			CONTRACT NO. 99338		



**INDEX OF SHEETS**

SHEET NO.	DESCRIPTION
1	TITLE AND COVER SHEET, INDEX OF SHEETS, LIST OF STANDARDS AND LOCATION MAP
2	STRUCTURAL DESIGN DATA, SUMMARY OF QUANTITIES AND PROJECT BENCHMARK LIST
3	TYPICAL SECTIONS AND DETAIL FOR MAILBOX TURNOUT
4-22	PLAN AND PROFILES
23-36	GRADING PLAN AND TREE REMOVAL PLAN
37	CULVERT REMOVAL AND TREE REMOVAL SCHEDULES
38	MISCELLANEOUS STORM SEWER ITEMS SCHEDULE, DETAIL - INLET, TYPE C, SPECIAL AND DETAIL OF CONCRETE COLLAR
39	DRIVEWAY SCHEDULE, CURB AND GUTTER SCHEDULE, RIPRAP SCHEDULE, DRIVEWAY APRON DETAILS, SIDE ROAD SECTION VIEW, CURB AND GUTTER DETAILS AND GUTTER OUTLET, SPECIAL DETAILS
40	TRAFFIC CONTROL PLAN
41-44	STORM WATER POLLUTION PREVENTION PLAN
45-82	CROSS SECTIONS
83-85	BOX CULVERT DETAILS
86	ELECTRICAL SITE PLAN, METER LOOP & LIGHTING CONTROL DETAIL, TYPICAL CONTROL SCHEMATIC AND NOTES
87	ELECTRICAL DETAILS
88-90	PAVEMENT MARKING, SIGNAGE & RIGHT-OF-WAY MARKER PLAN
91	PAVEMENT MARKING SCHEDULE, SIGNAGE SCHEDULE, RIGHT-OF-WAY MARKER SCHEDULE AND TYPICAL PARKING SPACE MARKING DETAIL

**STATE OF ILLINOIS**  
**DEPARTMENT OF TRANSPORTATION**  
**DIVISION OF HIGHWAYS**  
**PLANS FOR THE PROPOSED IMPROVEMENTS TO**  
**BOSKYDELL ROAD (FAS 1919)**  
**SECTION 06-00144-00-WR**  
**JACKSON COUNTY**  
**JOB NO. C-99-579-06**  
**PROJECT NO. SR-1919(106)**  
**CONTRACT NO. 99338**

**LIST OF STANDARDS**

STANDARD NO.	TITLE
280001-06	TEMPORARY EROSION CONTROL SYSTEMS
542301-03	PRECAST REINFORCED CONCRETE FLARED END SECTION
542401-01	METAL END SECTION FOR PIPE CULVERTS
542406-01	METAL END SECTIONS FOR PIPE ARCHES
542546-01	INLET BOX, FLUSH FOR MEDIAN
542601-03	REINFORCED CONCRETE PIPE ELBOW 24", 30" OR 36" (600MM, 750MM OR 900MM)
602301-03	INLET - TYPE A
602401-03	MANHOLE TYPE A
602601-02	PRECAST REINFORCED CONCRETE FLAT SLAB TOP
604001-03	FRAME AND LIDS TYPE 1
606001-04	CONCRETE CURB TYPE B AND COMBINATION CONCRETE CURB AND GUTTER
606006-02	OUTLETS FOR CONCRETE CURB AND GUTTER TYPE B-6.24 (B-15.60)
606201-02	TYPE B GUTTER (INLET, OUTLET & ENTRANCE)
606401-01	PAVED DITCH
630001-10	STEEL PLATE BEAM GUARDRAIL, TYPE A
630301-05	SHOULDER WIDENING FOR TYPE 1 (SPECIAL) GUARDRAIL TERMINALS
665001-02	WOVEN WIRE FENCE
666001-01	RIGHT OF WAY MARKERS
701001-02	OFF-RD OPERATIONS, 2L, 2W, MORE THAN 15' (4.5M) AWAY
701006-03	OFF-RD OPERATIONS, 2L, 2W, 15' (4.5M) TO 24" (600MM) FROM PAVEMENT EDGE
701301-04	LANE CLOSURE 2L, 2W SHORT TIME OPERATIONS
701306-03	LANE CLOSURE, 2L, 2W, SLOW MOVING OPERATIONS DAY ONLY FOR SPEEDS > 45 MPH
701501-06	LANE CLOSURE, URBAN, 2L, 2W UNDIVIDED
701901-02	TRAFFIC CONTROL DEVICES
720001-01	SIGN PANEL MOUNTING DETAILS
720006-03	SIGN PANEL ERECTION DETAILS
728001-01	TELESCOPING STEEL SIGN SUPPORT
780001-03	TYPICAL PAVEMENT MARKINGS
781001-03	TYPICAL APPLICATIONS RAISED REFLECTIVE PAVEMENT MARKERS
B.L.R. 21-9	TYPICAL APPLICATION OF TRAFFIC CONTROL DEVICES FOR CONSTRUCTION ON RURAL LOCAL HIGHWAYS
B.L.R. 22-7	TYPICAL APPLICATION OF TRAFFIC CONTROL DEVICES FOR CONSTRUCTION ON RURAL LOCAL HIGHWAYS
B.L.R. 24-2	MAILBOX TURNOUT FOR LOCAL ROADS
B.L.R. 23-4	TRAFFIC BARRIER TERMINAL TYPE 1
B.L.R. 27-1	TRAFFIC BARRIER TERMINAL TYPE 5A

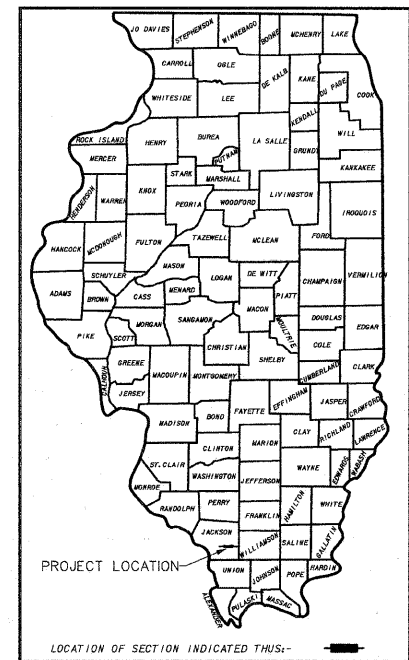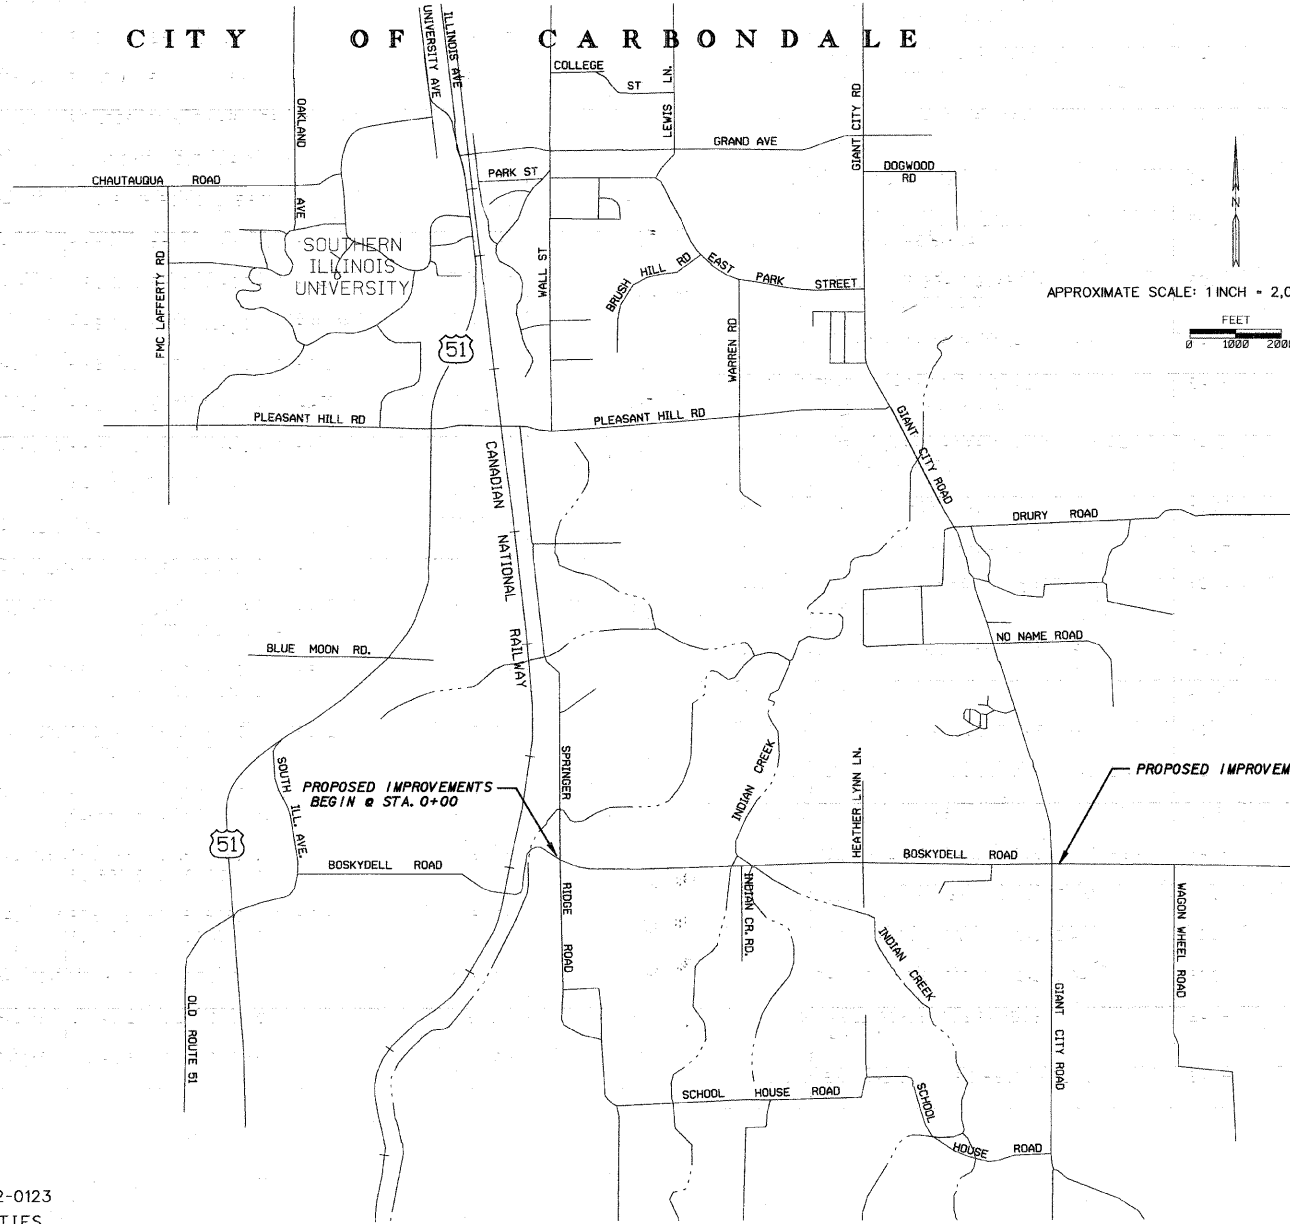

**LAYOUT**  
 TOTAL LENGTH OF PROJECT = 11.243 FT. = 2.129 MI.  
 OMISSION STA. 43+51.5 TO STA. 44+37 (BRIDGE STRUCTURE #039-3160)  
 NET LENGTH OF IMPROVEMENT = 11.157.5 FT. = 2.113 MI.

**SCALES**  
 PLAN 1/4" = 20 FEET  
 PROFILE 1/4" = 20 FEET HORIZ.  
 PROFILE 1/4" = 10 FEET VERT.  
 CROSS SECTIONS 1/4" = 10 FEET HORIZ.  
 CROSS SECTIONS 1/4" = 10 FEET VERT.

J.U.L.I.E - 1-800-892-0123  
**UTILITIES**  
 ELECTRIC - SOUTHERN ILLINOIS POWER COOPERATIVE  
               - EGYPTIAN ELECTRIC COOPERATIVE  
 GAS - AMEREN ILLINOIS  
 TELEPHONE - FRONTIER COMMUNICATIONS  
 CABLE TV - MEDIACOM  
 WATER - SOUTH HIGHWAY WATER DISTRICT

TED R. BEGGS  
 REG. NO. 62-053736  
 DATE 10/25/11  
 EXPIRES 11-30-11

DESIGNATION:	BOSKYDELL ROAD
CLASSIFICATION:	FAS 1919
A.D.T. (2032)	RURAL COLLECTOR
DESIGN SPEED	1,760
	40 MPH

APPROVED [Signature] 10/25 2011  
 GRANT C. GUTHMAN - JACKSON COUNTY ENGINEER  
  
 APPROVED [Signature] 10/25 2011  
 DAN WILLIAMS - MAKANDA TOWNSHIP HIGHWAY COMMISSIONER  
  
 APPROVED [Signature] 10/31 2011  
 - DISTRICT 9 ENGINEER OF LOCAL ROADS & STREETS  
  
 RELEASING FOR BID BASED ON LIMITED REVIEW [Signature] 10/31 2011  
 OMER M. OSMAN, P.E. - ACTING DEPUTY DIRECTOR OF HIGHWAYS REGION FIVE ENGINEER

SCALE AS SHOWN	PLANS PREPARED BY J. T. BLANKINSHIP, INC. CONSULTING ENGINEERS	BOOK 471-W	FILE NO. E*8879
DATE	401 S. 17TH STREET MURPHYSBORO, ILLINOIS	SHEET NO. 1 OF 91	