



F.A.I. SHEETS	SECTION	COUNTY	TOTAL SHEETS	SHEET NO.
90/94	2004-099TS	COOK	65	30
STA. -		TO STA. -		
FED. ROAD DIST. NO. 1		ILLINOIS	FED. AID PROJECT	
62840				

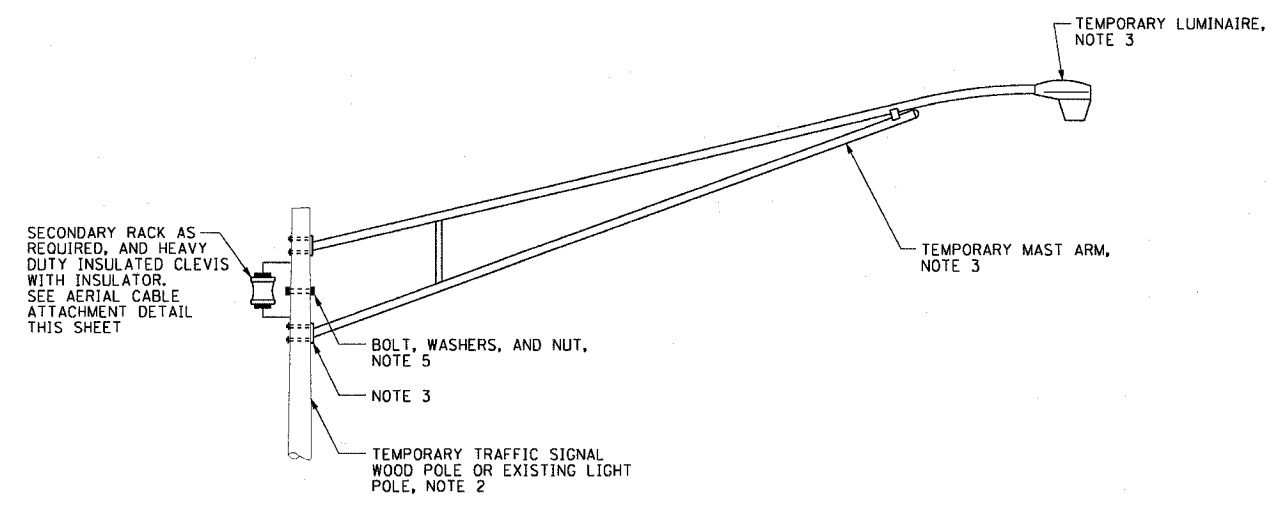

AERIAL CABLE TO TEMPORARY LIGHTING UNIT INSTALLATION DETAIL
NOT TO SCALE

NOTES:

1. SEE DRAWING E-1 AND E-2 FOR CDOT ELECTRICAL GENERAL NOTES, SYMBOLS AND ABBREVIATIONS.
2. SEE TEMPORARY LIGHTING PLANS FOR LOCATIONS OF THE TEMPORARY LIGHTING UNITS AND ROUTING OF THE TEMPORARY AERIAL CABLES.
3. TEMPORARY MAST ARM, LUMINAIRE, AND ALL HARDWARE REQUIRED TO MOUNT THE TEMPORARY MAST ARM TO THE POLE WILL BE INCLUDED FOR PAYMENT UNDER THE "TEMPORARY LIGHTING UNIT" PAY ITEM.
4. SEE DRAWING BOE-24 FOR BOE LIGHTING MAST ARM DETAILS.
5. ALL HARDWARE REQUIRED TO MOUNT THE TEMPORARY AERIAL CABLES TO THE WOOD POLE WILL BE INCLUDED FOR PAYMENT UNDER THE "AERIAL CABLE WITH MESSENGER WIRE, 2-1/2" NO.4" PAY ITEM.
6. ALL HARDWARE REQUIRED TO PROVIDE POWER TO THE TEMPORARY LUMINAIRE FROM THE TEMPORARY LIGHTING CIRCUIT AERIAL CABLES WILL BE INCLUDED FOR PAYMENT UNDER THE "TEMPORARY LIGHTING UNIT" PAY ITEM.

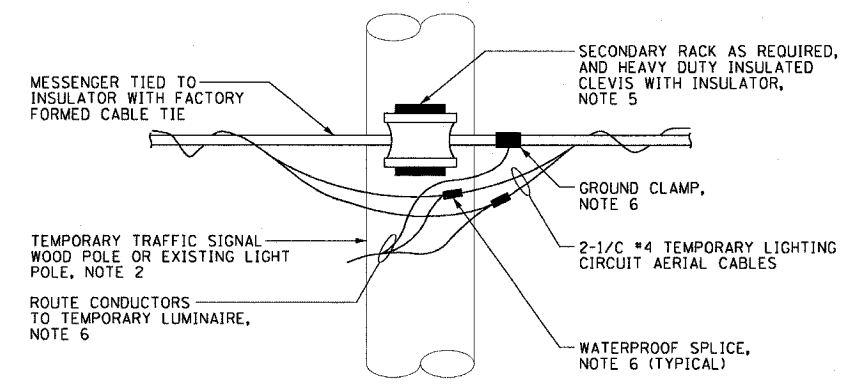

AERIAL CABLE ATTACHMENT DETAIL
NOT TO SCALE

E-14



REVISIONS	
NAME	DATE

ILLINOIS DEPARTMENT OF TRANSPORTATION
F.A.I. 90/94 (DAN RYAN EXPRESSWAY)
TRAFFIC SIGNALS AT 63RD STREET AND
WENTWORTH AVENUE/ WELLS STREET
TEMPORARY LIGHTING DETAILS

SCALE: AS SHOWN DRAWN BY: HAR
DATE: November 05, 2004 CHECKED BY: WDS

11/04/2004 09:01:31 AM