

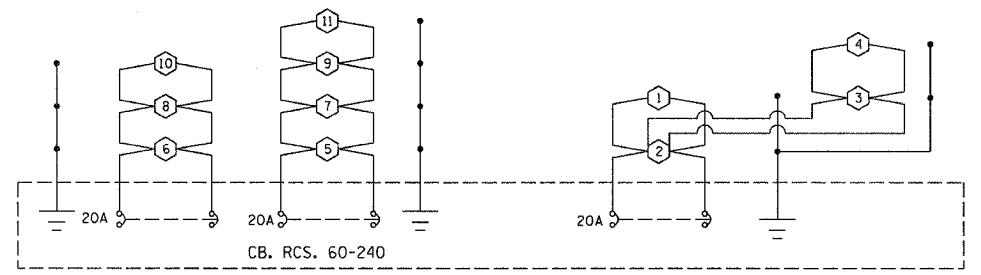
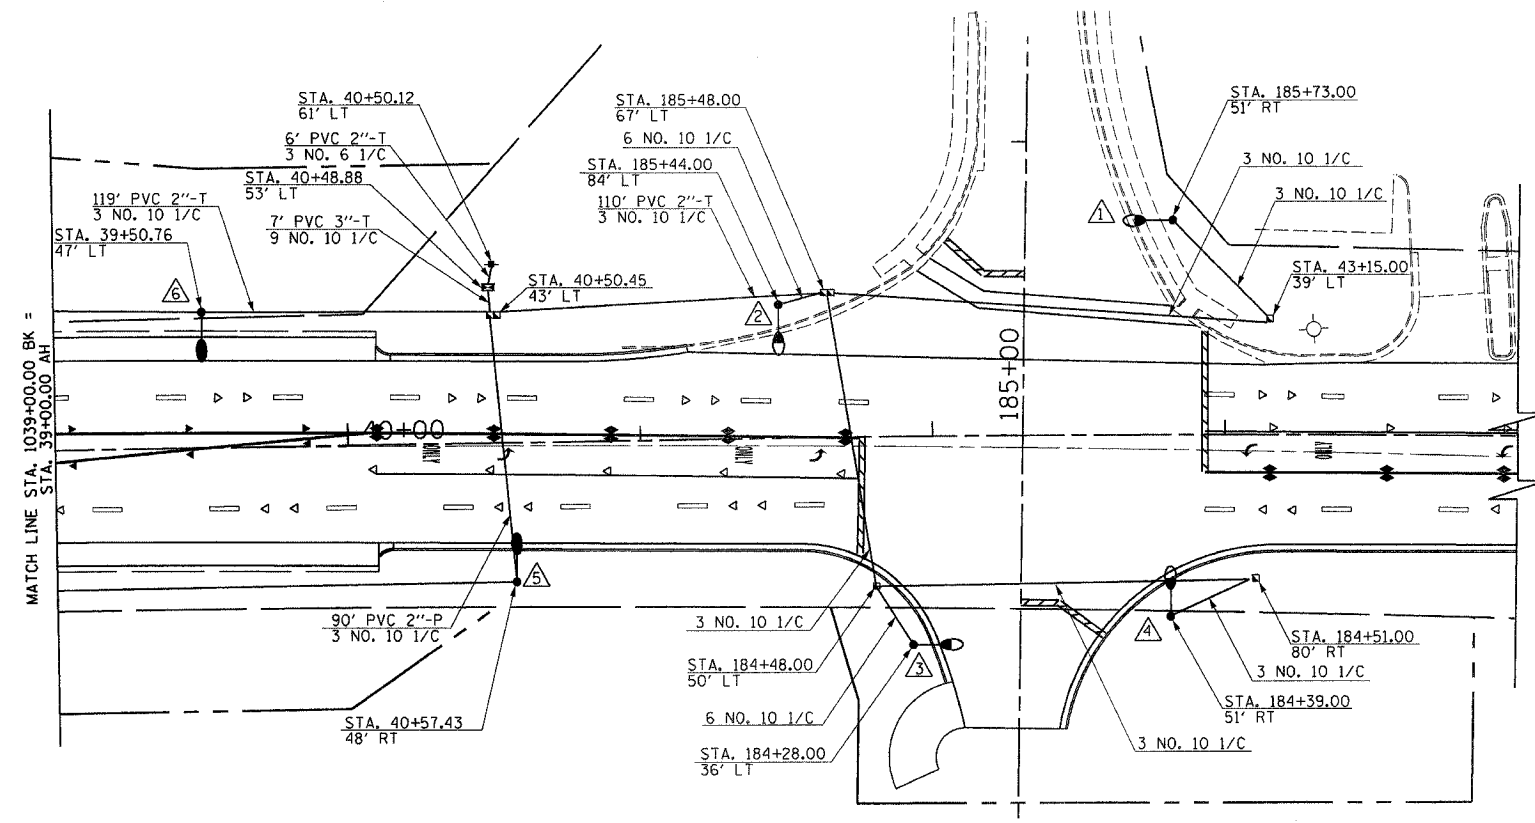


F.A.P. RTE.	SECTION	COUNTY	TOTAL SHEETS	SHEET NO.
774	.	EFFINGHAM	344	118A
FED. ROAD DIST. NO. 7 ILLINOIS FED. AID PROJECT				
*107WRS-1, 107BY, 107BY-1 & 107B-2				
CONTRACT NO. 94827				

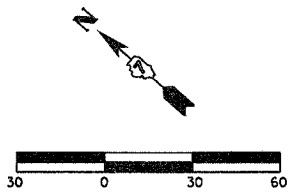

CONTROL ONE LINE

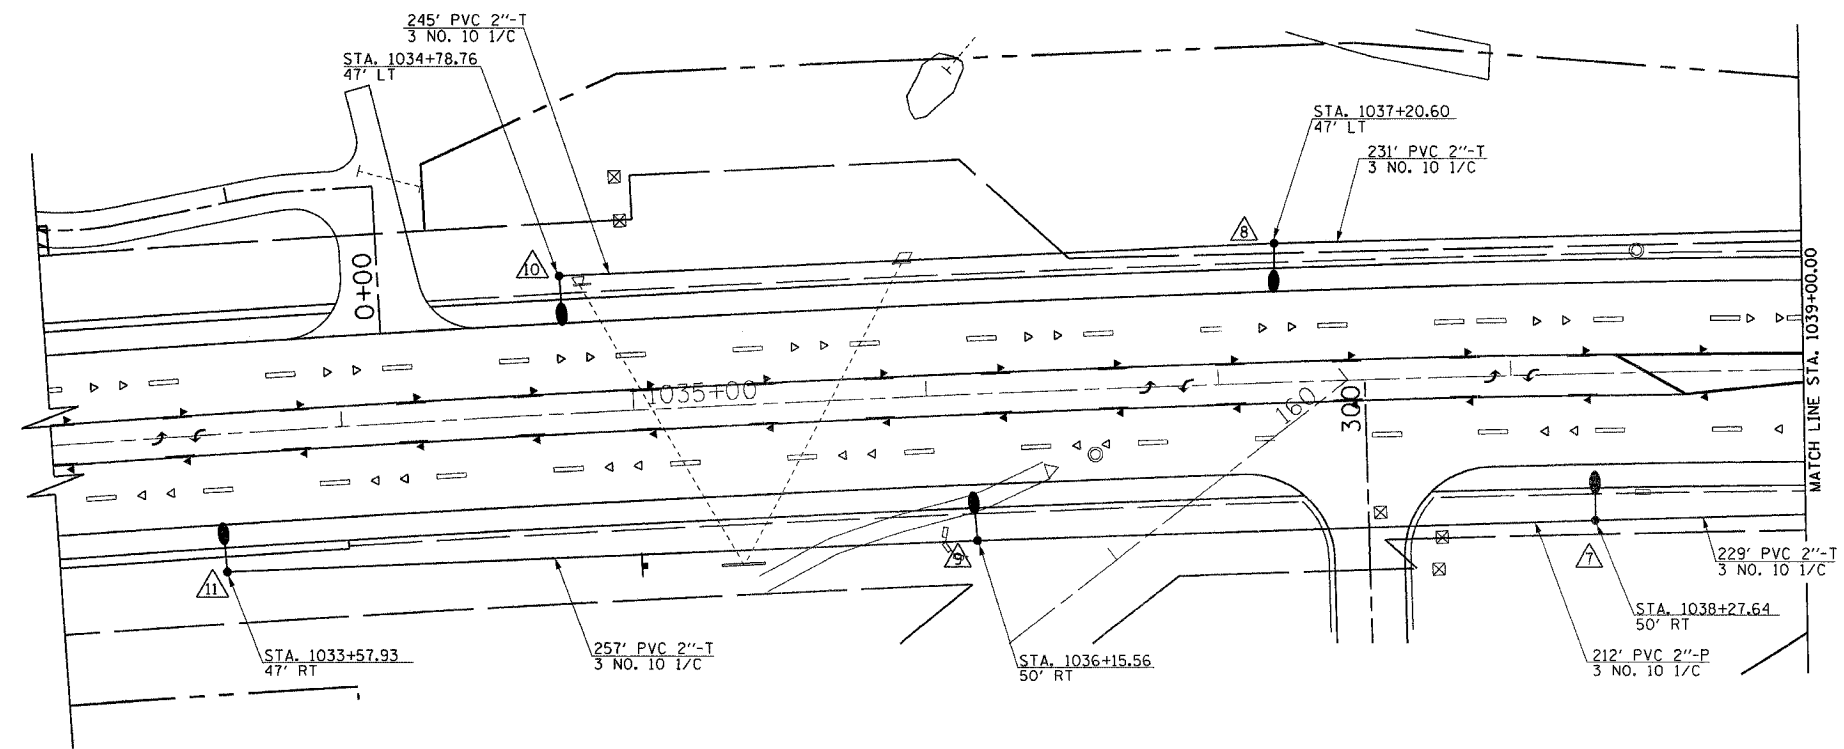

LEGEND:

- CONDUIT w/GROUND
- CONTROLLER
- HANDHOLE
- LIGHT UNIT-1
- LIGHT UNIT-2
- SERVICE POLE

REVISIONS	
NAME	DATE

ILLINOIS DEPARTMENT OF TRANSPORTATION

FORD AVENUE
LIGHTING PLANS
SHEET 7 OF 8

DRAWN BY MLO
CHECKED BY BWD

DATE 8/02

LIGHTING LAYOUT