


SIGN DETAIL
1:75

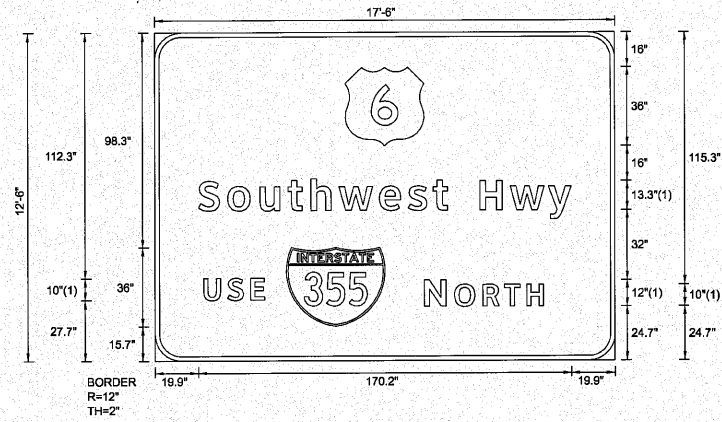

Panel Style: Guide Sign.ssi
Dimensions are in inches.tenths

FONT:
(1) ClearviewHwy-5-W
Panel Style: Guide Sign.ssi
M.U.T.C.D.: 2009 Edition

Letter locations are panel edge to lower left corner

SIGN NUMBER	EB-BS-13; STA. 754+80
WIDTH x HGHT.	17'-6" x 12'-6"
BORDER WIDTH	2"
CORNER RADIUS	12"
MOUNTING	Ground
BACKGROUND	TYPE: Reflective
	COLOR: Green
LEGEND/BORDER	TYPE: Reflective
	COLOR: White / White

SYMBOL	ROT	X	Y	WID	HT
M1_4	0	87	98	36	36
M1_1	0	60	15.6	45	36

LETTER POSITIONS (X)

																					LENGTH	SERIESSIZE	
S	o	u	t	h	w	e	s	t		H	w	y										ClearviewHwy-5-W	
19.9	33.2	48	60.8	71.3	84.1	102.5	115.8	127.2	133.7	148.5	162.4	179.7									170.2	13.3/10.8	
U	S	E																				ClearviewHwy-5-W	
22.3	33.2	43.7																				27.8	10
N	O	R	T	H																		ClearviewHwy-5-W	
123	136.8	149.6	159.6	169.7																		54.3	12/10

FILE NAME =	DESIGNED - ST	REVISED -
N:\PROJ\3384\2.West\Design\Striping_Signing\BRWN\signing-de\11sheets.dgn	CHECKED - FML	REVISED -
USER NAME = jkjeilmen	DATE - 10/2010	REVISED -
PLOT DATE = 12/6/2010		



STATE OF ILLINOIS
DEPARTMENT OF TRANSPORTATION

SIGNING DETAILS	
SCALE: N.T.S.	SHEET NO. ___ OF ___ SHEETS
STA. _____	TO STA. _____

F.A.RTE.	SECTION	COUNTY	TOTAL SHEETS	SHEET NO.
80	99-5-Y	WILL	276	120
FED. ROAD DIST. NO. _____				ILLINOIS FED. AID PROJECT

CONTRACT NO. 60147