
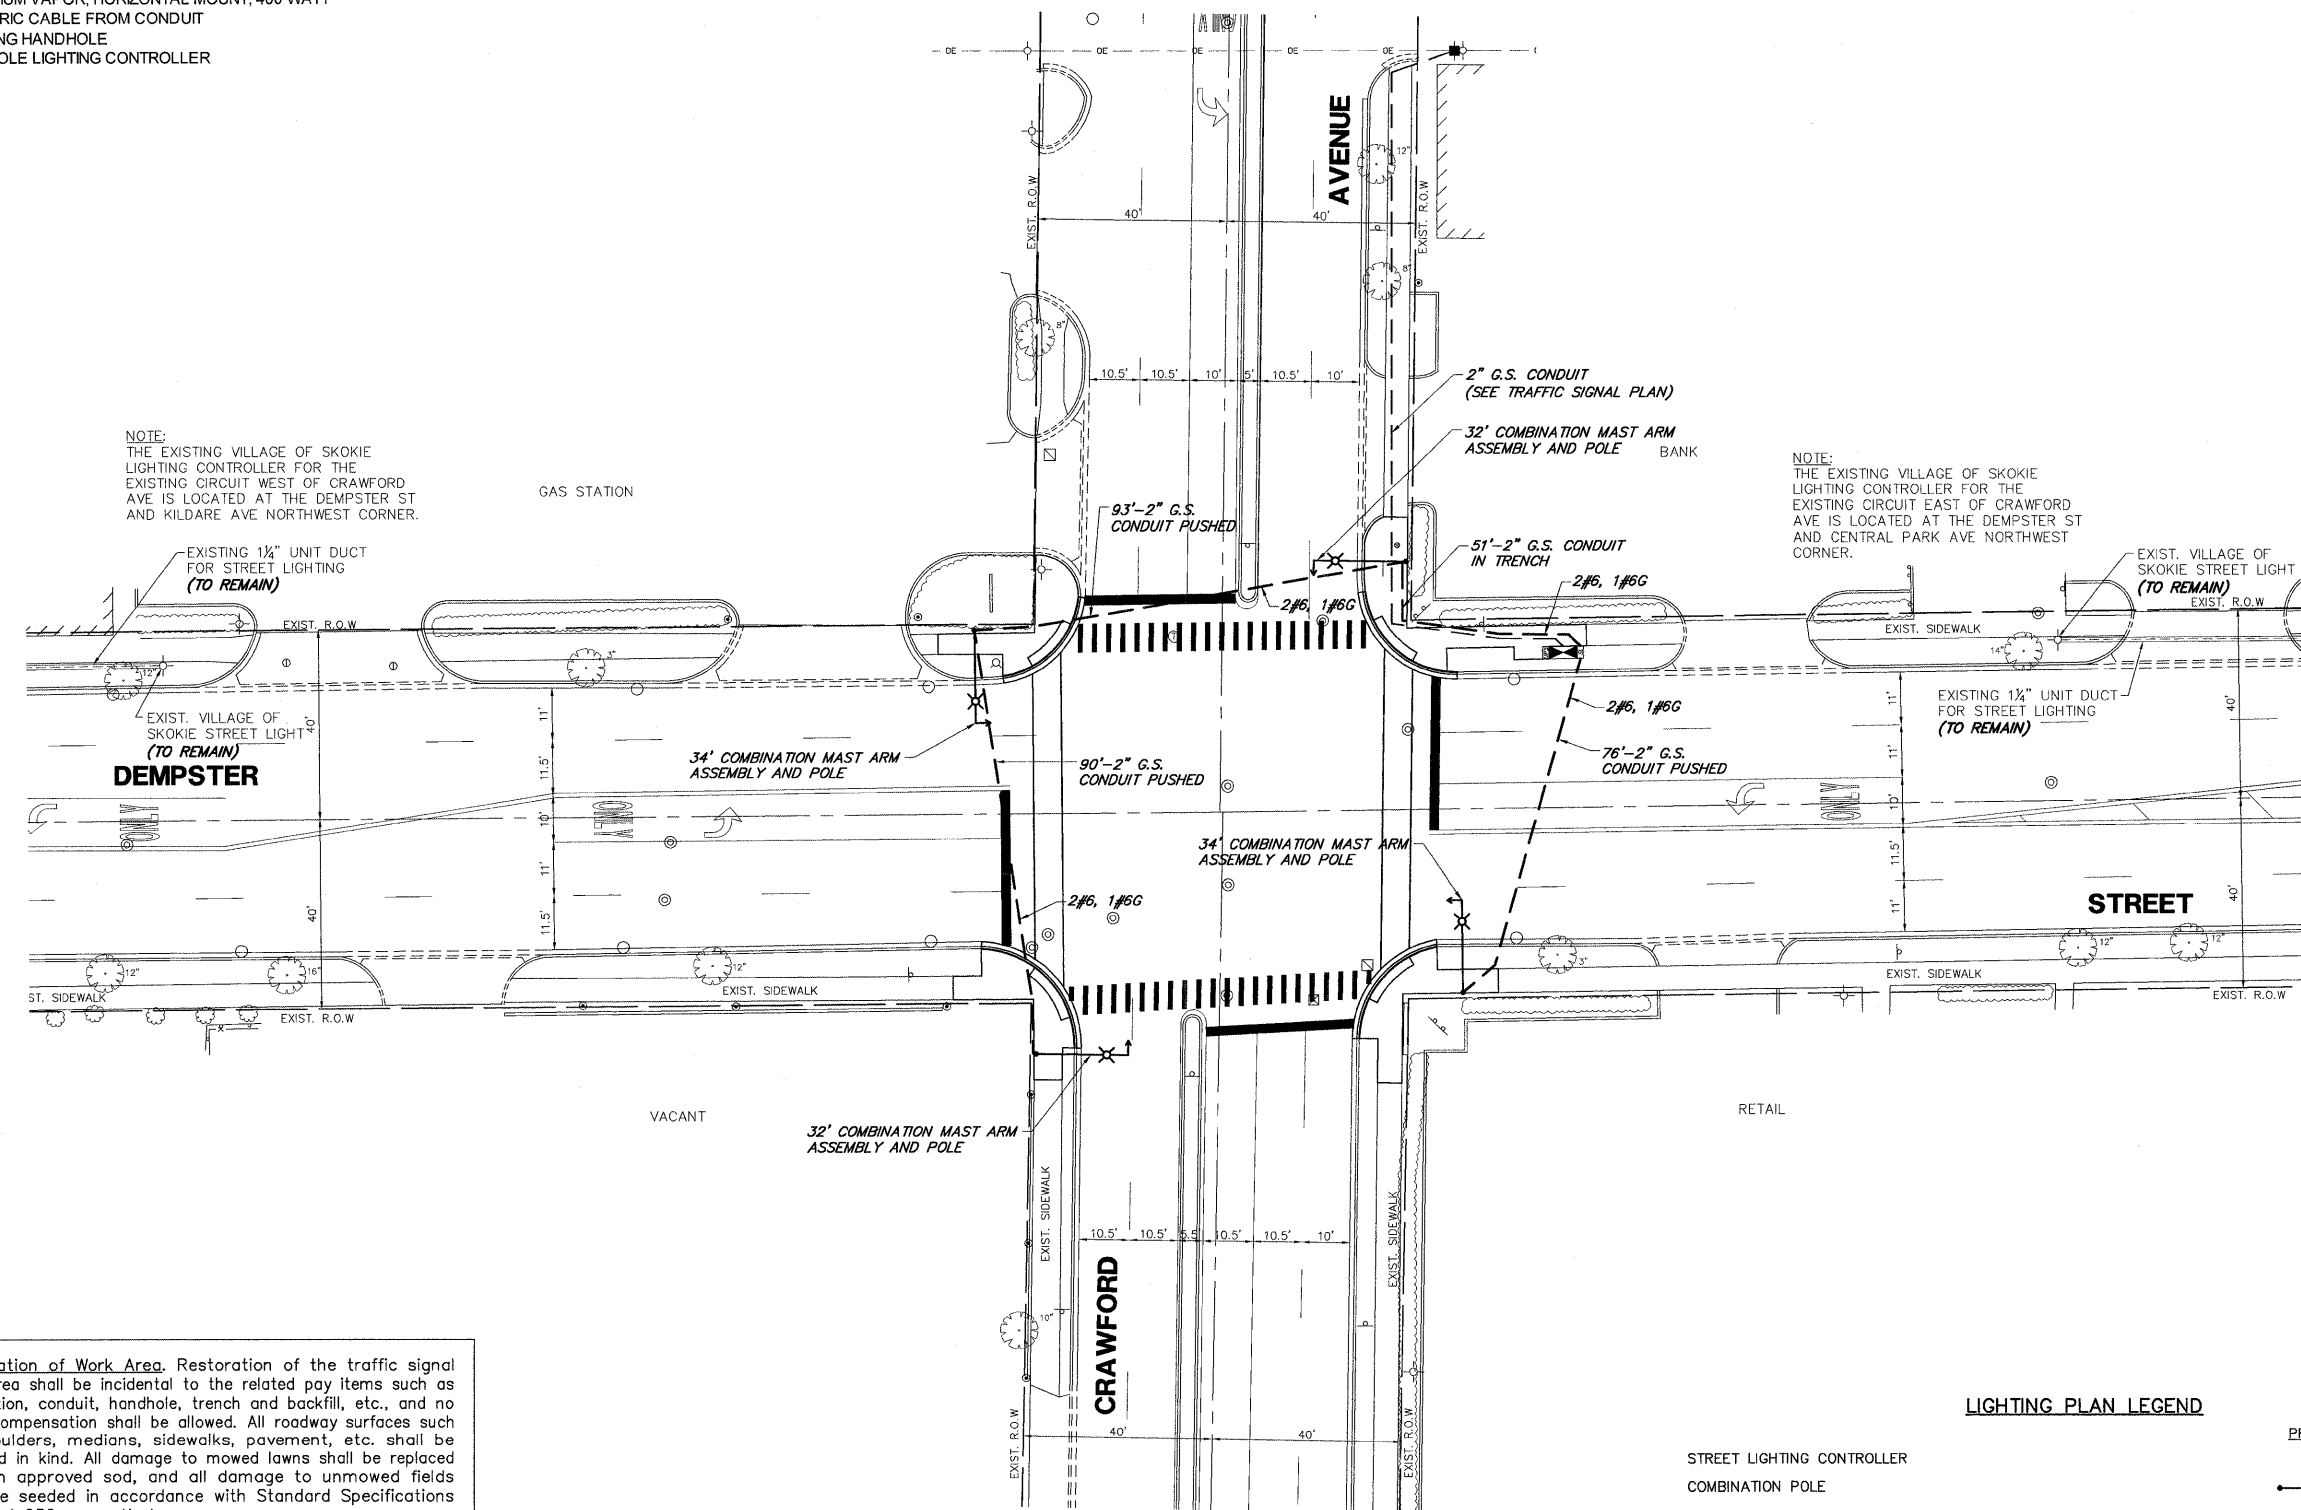


SCHEDULE OF QUANTITIES

DEMPSTER STREET AT CRAWFORD AVENUE INTERSECTION LIGHTING

NO.	QUANT.	UNIT	DESCRIPTION
1.	65	FOOT	CONDUIT IN TRENCH, 2" DIA., GALVANIZED STEEL
2.	300	FOOT	CONDUIT PUSHED, 2" DIA., GALVANIZED STEEL
3.	396	FOOT	ELECTRIC CABLE IN CONDUIT, 600V (XLP-TYPE USE) 3-1/C NO. 6
4.	60	FOOT	TRENCH AND BACKFILL FOR ELECTRICAL WORK
5.	4	EACH	LUMNAIRE, SODIUM VAPOR, HORIZONTAL MOUNT, 400 WATT
6.	960	FOOT	REMOVE ELECTRIC CABLE FROM CONDUIT
7.	2	EACH	REMOVE EXISTING HANDHOLE
8.	1	EACH	COMBINATION POLE LIGHTING CONTROLLER

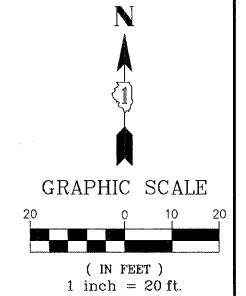

NOTE:
THE EXISTING VILLAGE OF SKOKIE LIGHTING CONTROLLER FOR THE EXISTING CIRCUIT WEST OF CRAWFORD AVE IS LOCATED AT THE DEMPSTER ST AND KILDARE AVE NORTHWEST CORNER.

NOTE:
THE EXISTING VILLAGE OF SKOKIE LIGHTING CONTROLLER FOR THE EXISTING CIRCUIT EAST OF CRAWFORD AVE IS LOCATED AT THE DEMPSTER ST AND CENTRAL PARK AVE NORTHWEST CORNER.

Restoration of Work Area. Restoration of the traffic signal work area shall be incidental to the related pay items such as foundation, conduit, handhole, trench and backfill, etc., and no extra compensation shall be allowed. All roadway surfaces such as shoulders, medians, sidewalks, pavement, etc. shall be replaced in kind. All damage to mowed lawns shall be replaced with an approved sod, and all damage to unmowed fields shall be seeded in accordance with Standard Specifications 252 and 250 respectively.

LIGHTING PLAN LEGEND



FILE NAME = 4085.869-TR1.dwg	USER NAME = ZACH WALLSTEN	DESIGNED - JRD	REVISED -	STATE OF ILLINOIS DEPARTMENT OF TRANSPORTATION	INTERSECTION LIGHTING PLAN DEMPSTER STREET AT CRAWFORD AVENUE			F.A.P. RTE. VARIES	SECTION 2010-006TS	COUNTY COOK	TOTAL SHEETS 58	SHEET NO. 34
PLOT SCALE = 1" = .0833'	DRAWN - ZCW	CHECKED - KLB	REVISED -		SCALE: 1"=20'	SHEET NO.	OF SHEETS	STA.	TO STA.	CONTRACT #: 60K24		
PLOT DATE = 10/29/2010	DATE - 10/29/2010	REVISED -	REVISED -		ILLINOIS FED. AID PROJECT							

CHA #4085.869