



PLAN	SURVEYED	DATE
	PLOTTED	
	CHECKED	
	BY	
	NO.	

PROFILE	SURVEYED	DATE
	PLOTTED	
	CHECKED	
	BY	
	NO.	

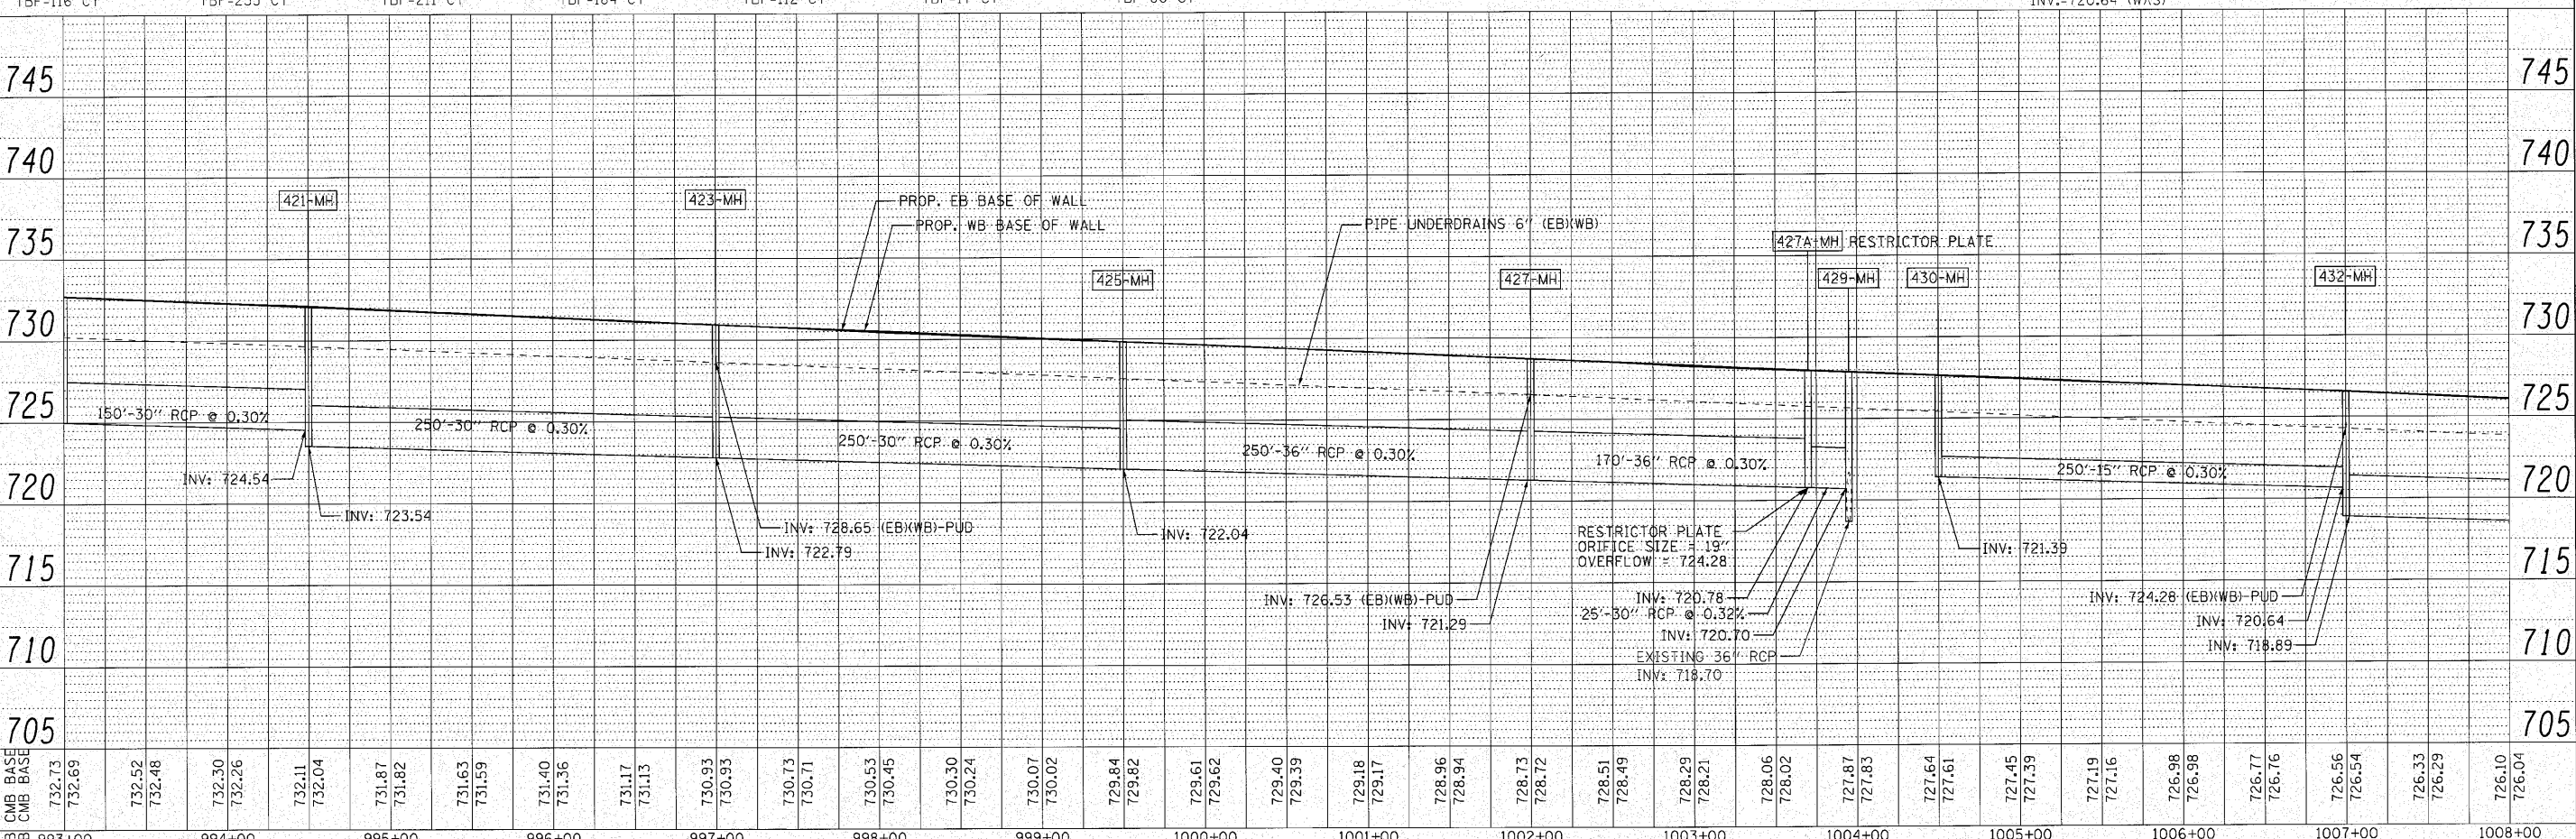

ENGINEERING CONSULTANT	USER NAME: jk,jellman	DESIGNED: CRC	REVISED:	STATE OF ILLINOIS DEPARTMENT OF TRANSPORTATION F.A.I. 80 FROM NS RAILROAD TO US 45 PROPOSED DRAINAGE PLAN AND PROFILE	F.A.I. RTE.: 80	SECTION: 9915&5-1) Y-1	COUNTY: WILL	TOTAL SHEETS: 309	SHEET NO.: 105	
CONSULTING ENGINEERS	PLLOT SCALE: 50.0000' / IN.	DRAWN: JMK	REVISED:		SCALE: 1" = 50'	SHEET NO. 105 OF	SHEETS	STA. 993+00	TO STA. 1008+00	CONTRACT NO. 60M59
	PLLOT DATE: 10/28/2010	CHECKED: MRJ	REVISED:		ILLINOIS FED. AID PROJECT					
		DATE: 10/27/2010	REVISED:							

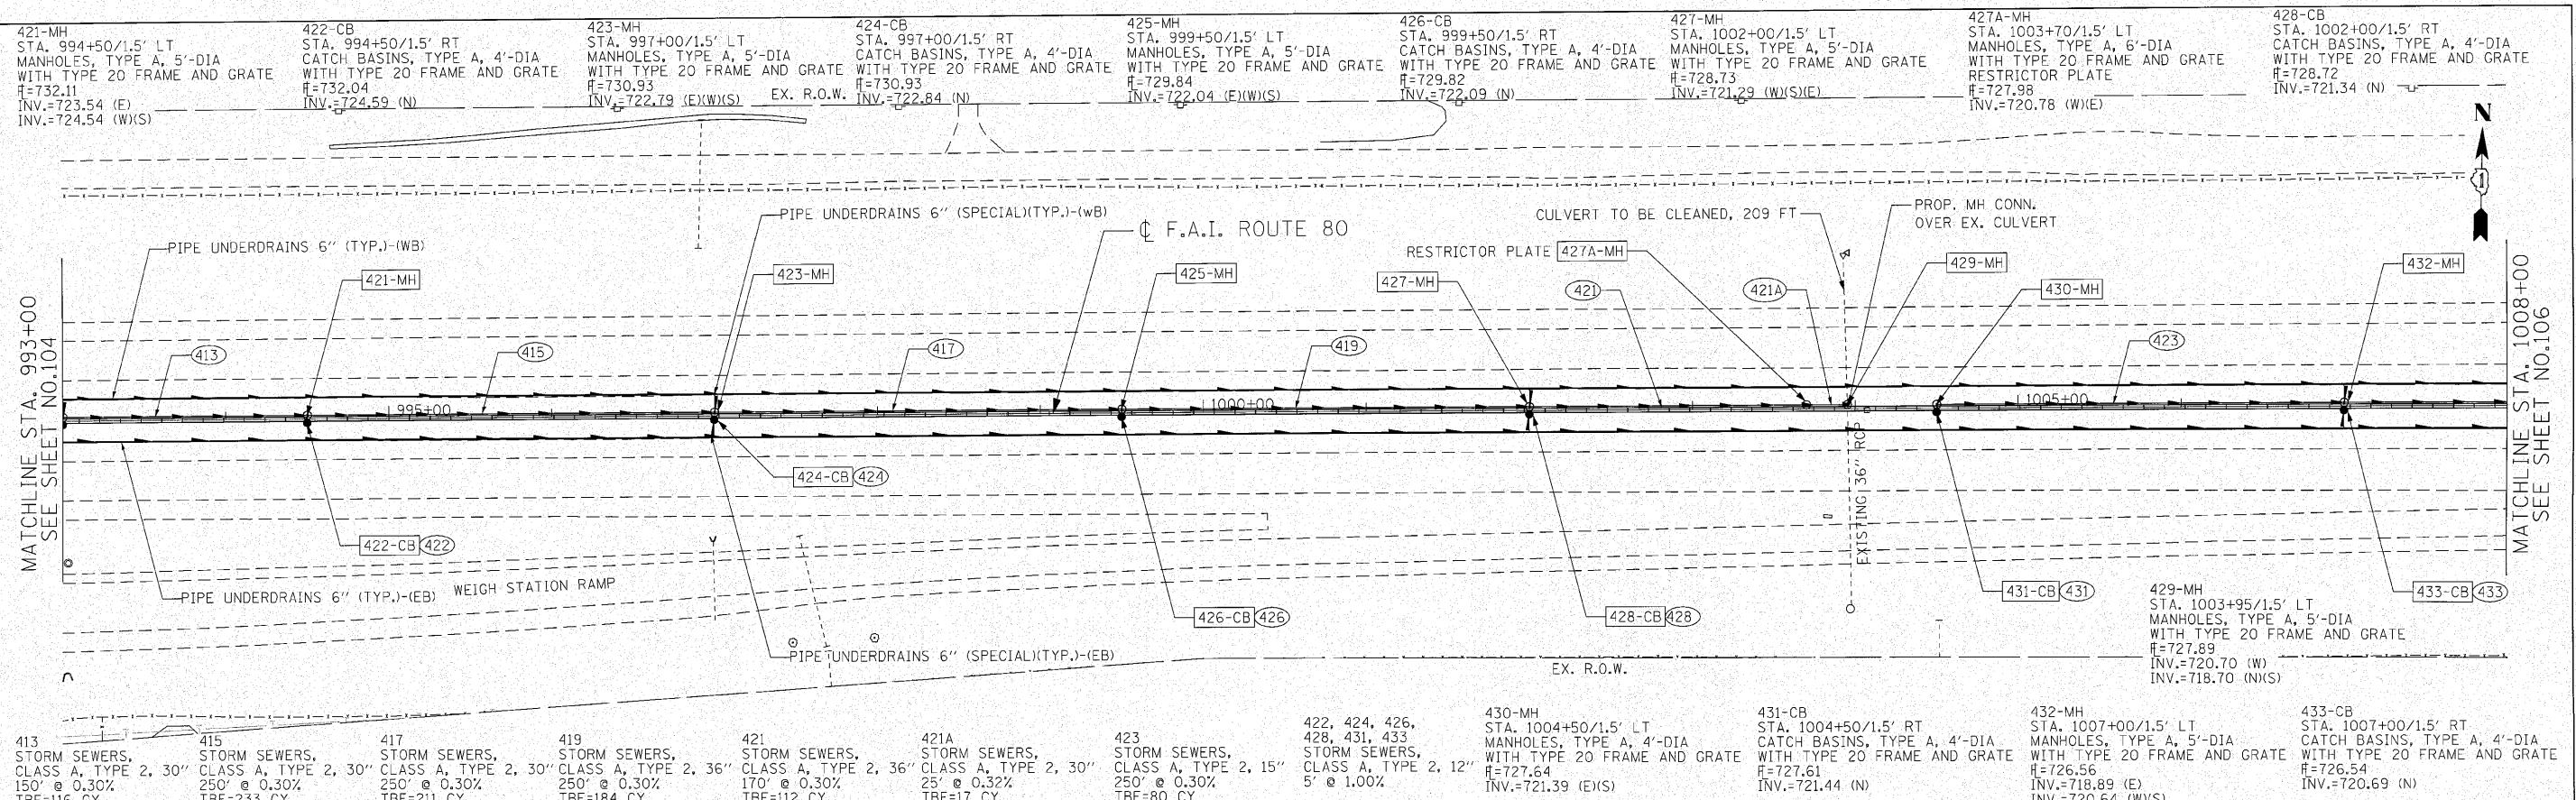