
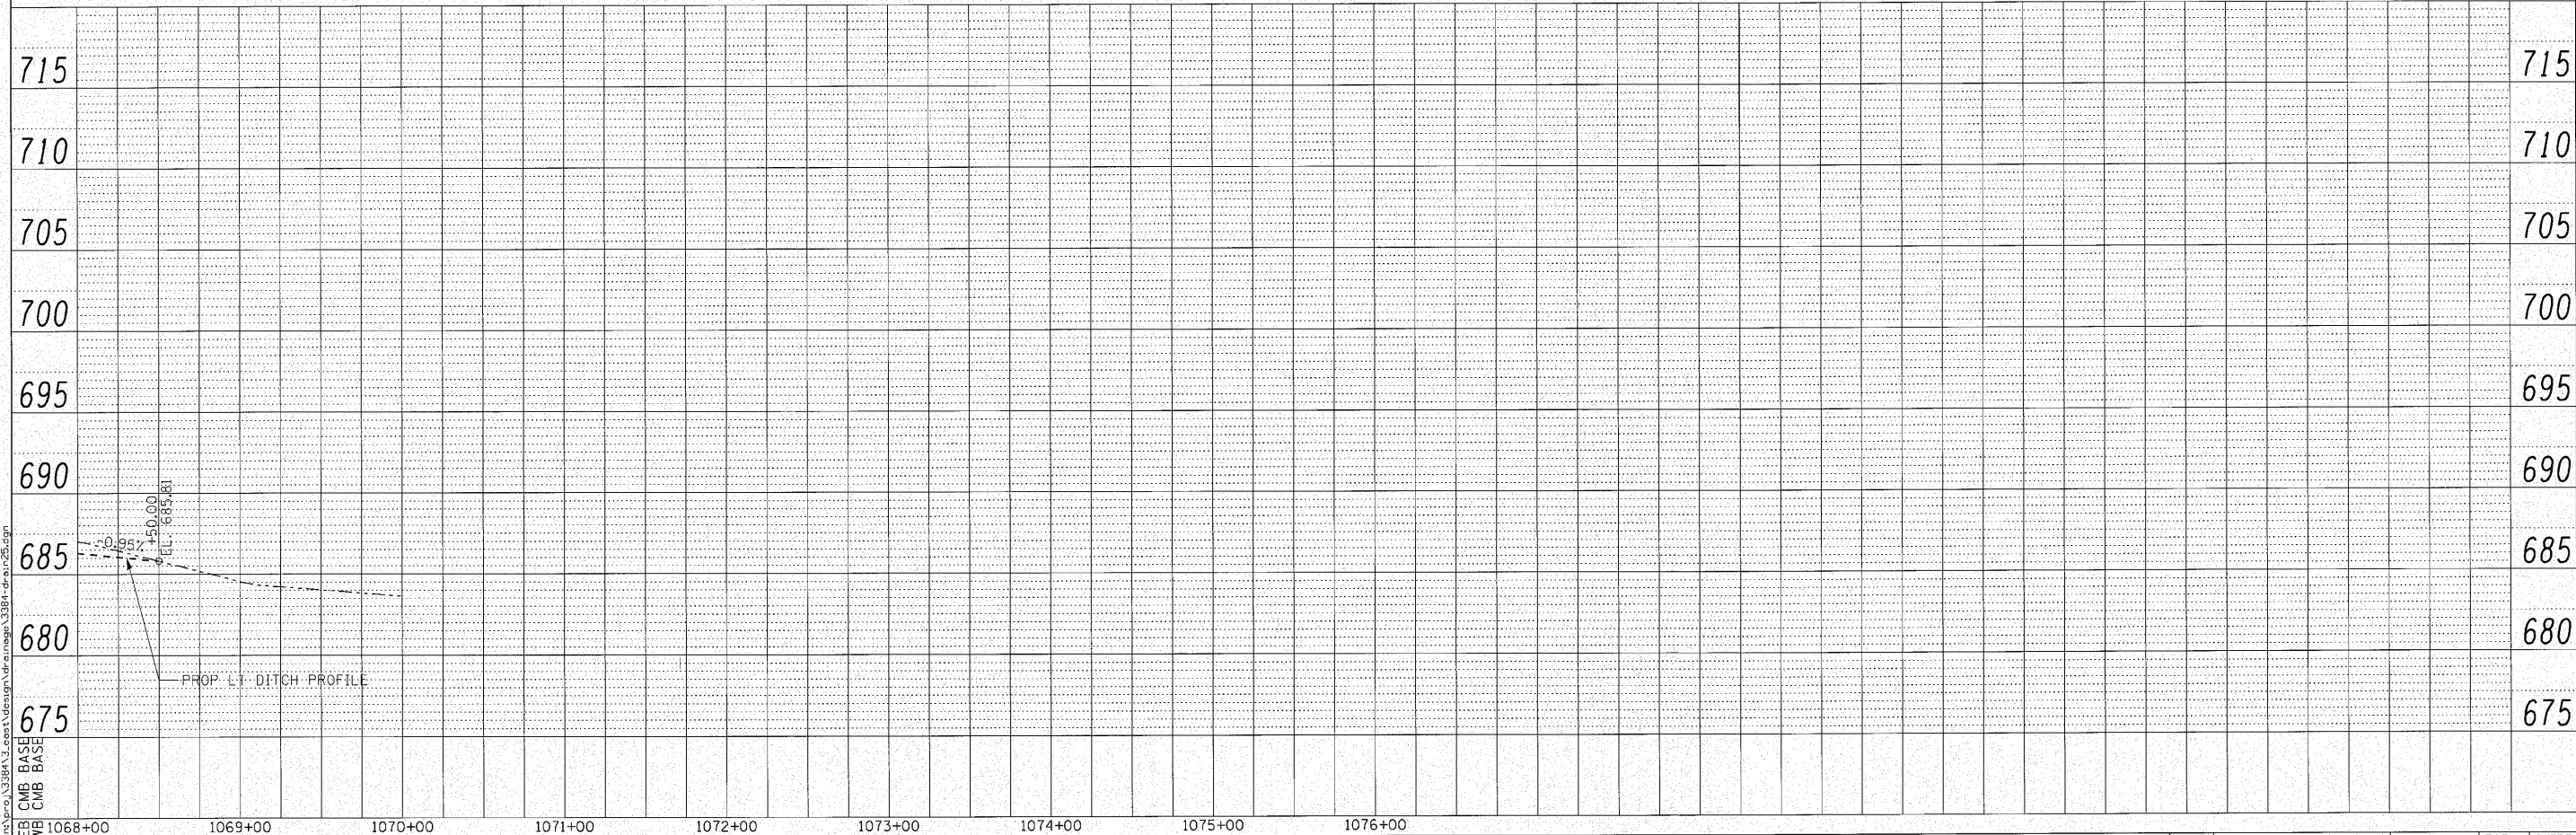


PLAN	REVIEWED	DATE
	PLOTTED	
	FRAMES CHECKED	
	STRUCTURE NOTATIONS CHECKED	
	NO.	

PROFILE	REVIEWED	DATE
	PLOTTED	
	FRAMES CHECKED	
	STRUCTURE NOTATIONS CHECKED	
	NO.	

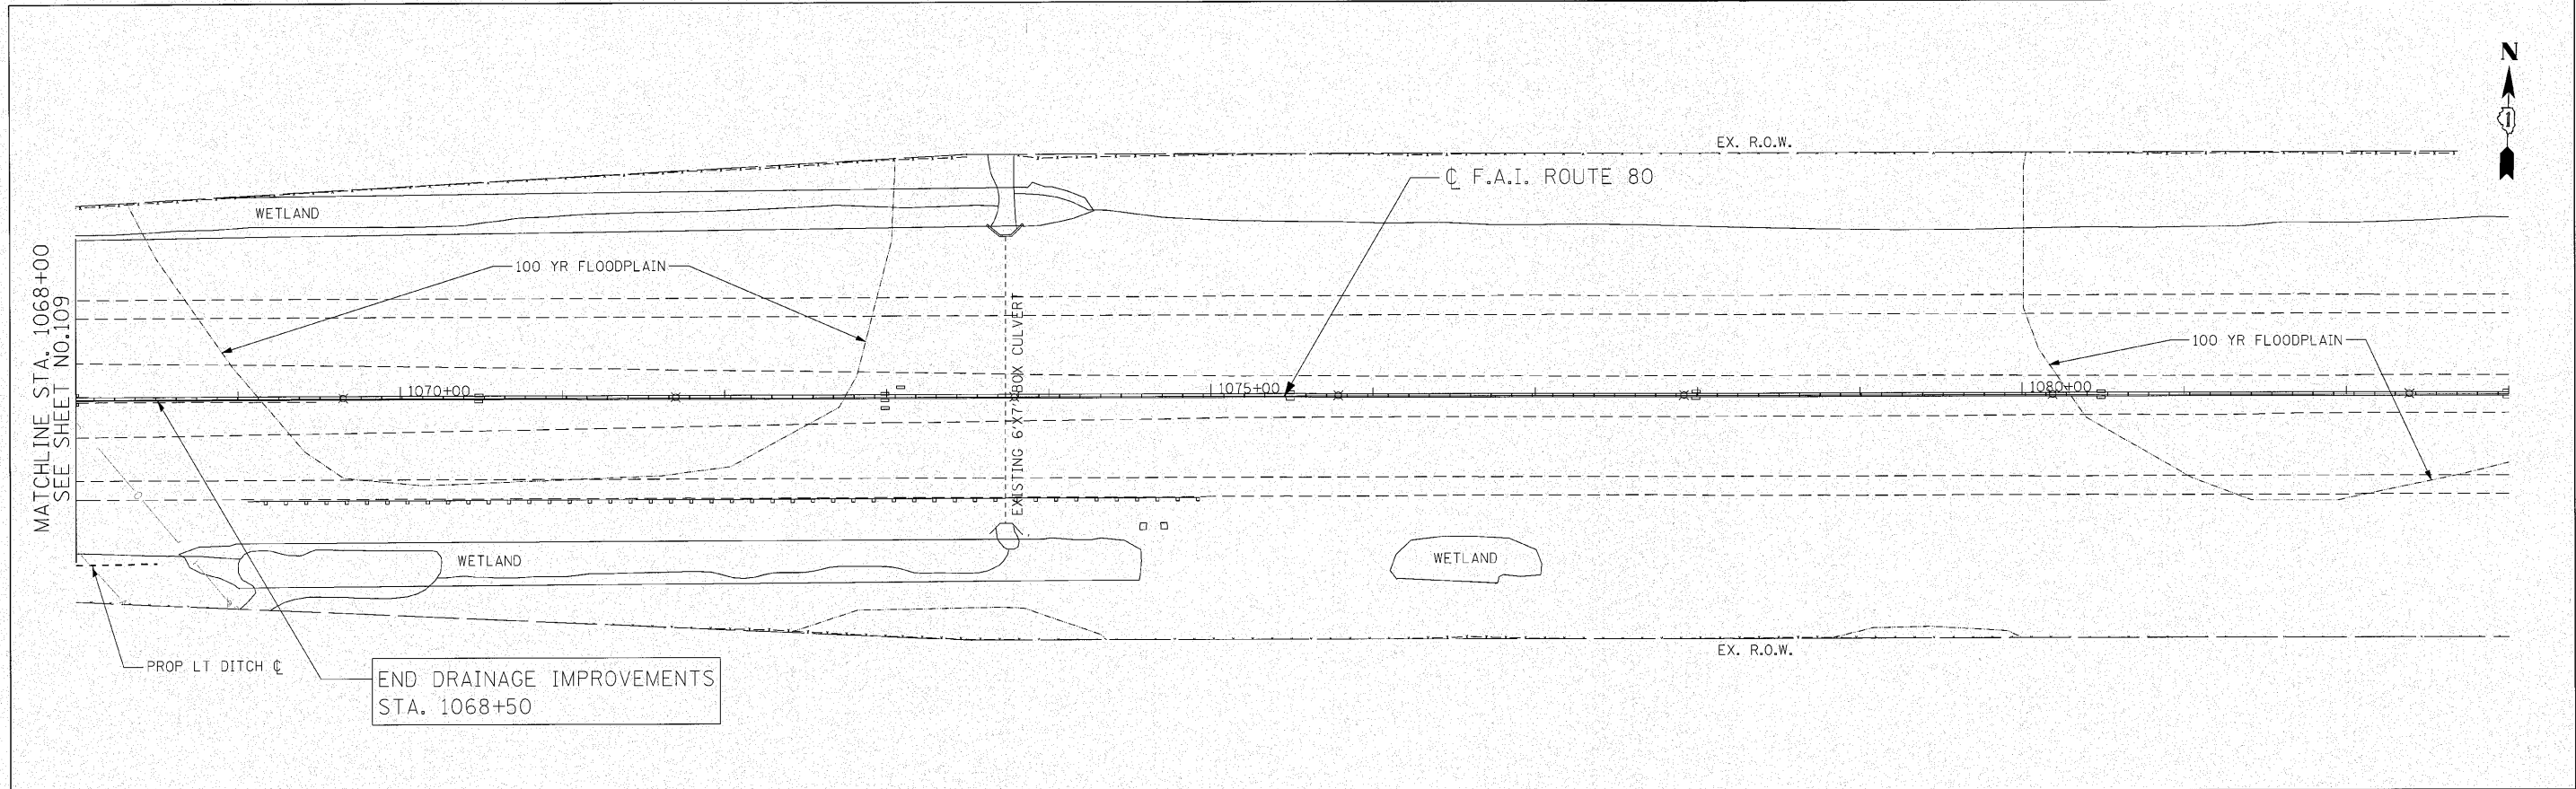

ENGINEERING CONSULTANT  
**Corba Group, Inc.**  
 CONSULTING ENGINEERS  
 6327 North Cumberland Avenue, Suite 402  
 Chicago, Illinois 60630  
 Tel: 773.775.4000 Fax: 773.775.4014  
 Email: info@corba.com

USER NAME = jkellman	DESIGNED - CRC	REVISED -
PLLOT SCALE = 50.0000' / 1" IN.	DRAWN - JMK	REVISED -
PLLOT DATE = 10/28/2010	CHECKED - MRJ	REVISED -
	DATE - 10/27/2010	REVISED -

**STATE OF ILLINOIS**  
**DEPARTMENT OF TRANSPORTATION**

**F.A.I. 80 FROM NS RAILROAD TO US 45**  
**PROPOSED DRAINAGE PLAN AND PROFILE**  
 SCALE: 1" = 50' SHEET NO. OF SHEETS STA. 1068+00 TO STA. 1083+00

F.A.I. RTE.	SECTION	COUNTY	TOTAL SHEETS	SHEET NO.
80	99(5&5-1) Y-1	WILL	309	110
CONTRACT NO. 60M59				
ILLINOIS FED. AID PROJECT				