


SIGN DETAIL
1:75

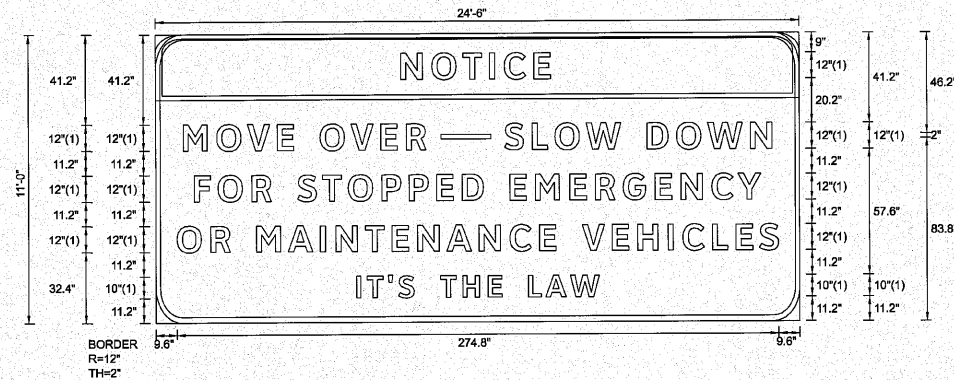

FONT:
(1) ClearviewHwy-5-W
Panel Style: guide_exp_advance_a.ssi
M.U.T.C.D.: 2009 Edition

Panel Style: guide_exp_advance_a.ssi
Dimensions are in inches.tenths

Letter locations are panel edge to lower left corner

SIGN NUMBER	EB-WP-24; 1017 + 10
WIDTH x HGHT.	24'-6" x 11'-0"
BORDER WIDTH	2"
CORNER RADIUS	12"
MOUNTING	Ground
BACKGROUND	TYPE: Reflective COLOR: Green
LEGEND/BORDER	TYPE: Reflective COLOR: Black / Black

SYMBOL	ROT	X	Y	WID	HT

LETTER POSITIONS (X)

																				LENGTH	SERIESSIZE	
N	O	T	I	C	E															68.3	ClearviewHwy-5-W 12	
112.2	126.3	140.5	152.7	159.4	172.8															268.9	ClearviewHwy-5-W 12	
M	O	V	E	O	V	E	R	S	L	O	W	D	O	W	N					258.7	ClearviewHwy-5-W 12	
12.6	27.8	41.9	55.5	75.2	89.3	102.8	114.5	159.5	172.1	182.4	196.7	224.5	238	252.2	271.6					274.8	ClearviewHwy-5-W 12	
F	O	R	S	T	O	P	P	E	D	E	M	E	R	G	E	N	C	Y		111	ClearviewHwy-5-W 10	
17.6	28.4	43.9	64.8	76.2	87.9	103.4	115.9	128.4	140.1	161.7	173.4	189.1	200.8	213.5	228.1	239.8	254	265.9				
O	R	M	A	I	N	T	E	N	A	N	C	E	V	E	H	I	C	L	E	S		
9.6	25	46	60.4	75.1	82.2	95.7	107.9	119.6	132.9	147.6	161.7	175.2	194.8	208.4	220.1	234	240.7	254.2	265	275.7		
I	T		S	T	H	E	L	A	W													
91.5	96.5	106.1	110.7	129.9	140.1	151.7	170.1	178	189.3													

FILE NAME =	DESIGNED - ST	REVISED -
N:\PROJ\3384\3_East\Design\Striping_Signing\DRAWING\signing-dec11\sheet.dgn	CHECKED - FML	REVISED -
USER NAME = jkellman	DATE - 10/2010	REVISED -
PLOT DATE = 12/6/2010		



STATE OF ILLINOIS
DEPARTMENT OF TRANSPORTATION

SIGNING DETAILS		
SCALE: N.T.S.	SHEET NO. OF SHEETS	STA. TO STA.

F.A. RTE. 80	SECTION 99(5&5-1) Y-1	COUNTY WILL	TOTAL SHEETS 309	SHEET NO. 134
FED. ROAD DIST. NO. ILLINOIS		FED. AID PROJECT CONTRACT NO. 60M59		