



**TYPICAL SPLICE DETAIL**  
N.T.S.

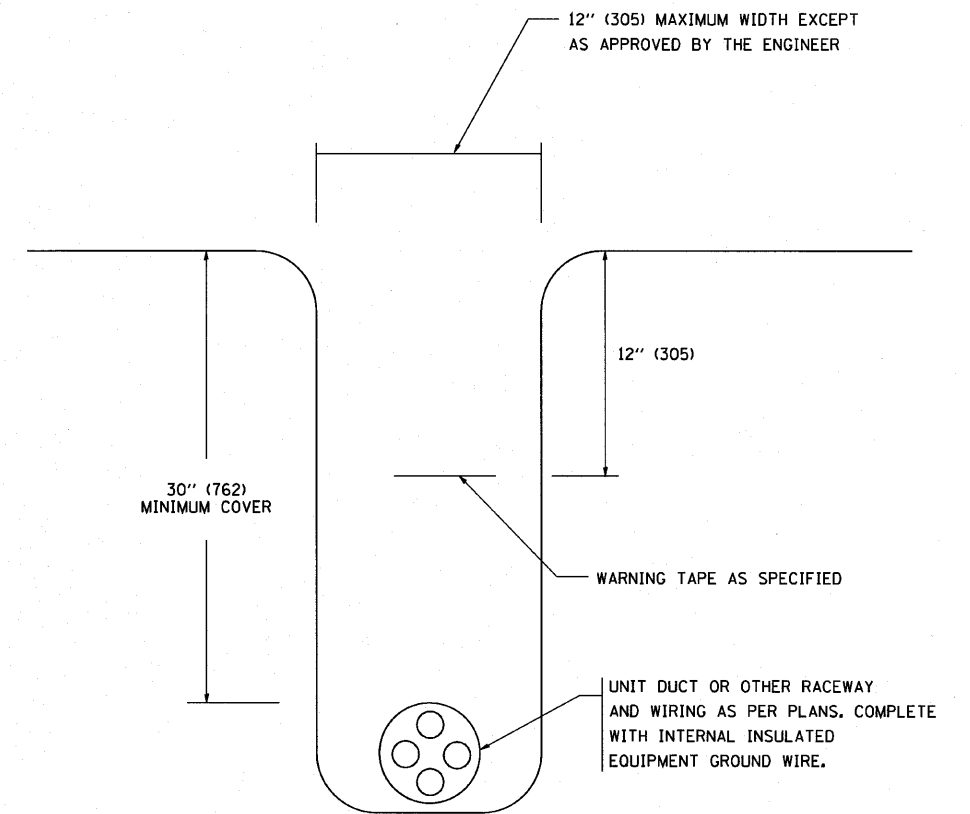

**TYPICAL WIRING IN TRENCH DETAIL**  
N.T.S.

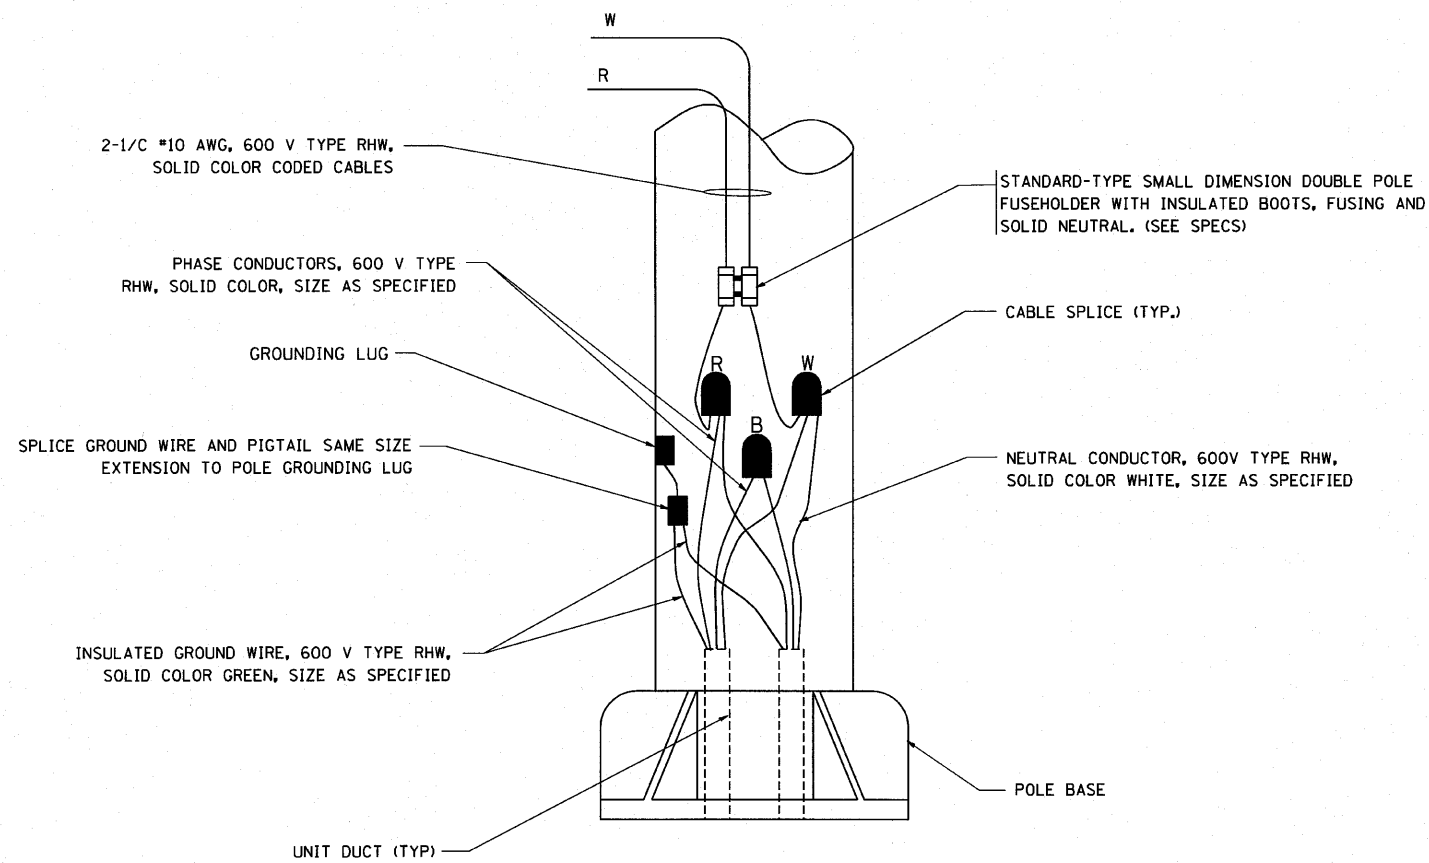

**POLE WIRING DETAIL**  
N.T.S.

FILE NAME =	USER NAME =	DESIGNED -	REVISED -	<b>STATE OF ILLINOIS DEPARTMENT OF TRANSPORTATION</b>	<b>MISC. ELECTRICAL DETAILS SHEET A</b>			F.A. RTE. =	SECTION	COUNTY	TOTAL SHEETS	SHEET NO.
		DRAWN -	REVISED -		3537	(47&22-3)R-2	DuPage	284	154			
PLOT SCALE =	CHECKED -	REVISED -	REVISED -		<b>BE-702</b>			<b>CONTRACT NO. D-91-533-00</b>				
PLOT DATE =	DATE -	REVISED -	REVISED -		FED. ROAD DIST. NO. 1   ILLINOIS FED. AID PROJECT							
				SCALE: NONE	SHEET NO. 1 OF 1 SHEETS	STA.	TO STA.					