


146	147	148	149	150	151	152	153	154
STA 219+65, 15'LT CB TA 4'0" T24 F&G RIM EL 735.35 INV 731.42	STA 222+15, 15'LT CB TA 4'0" T24 F&G RIM EL 738.00 INV 733.94	STA 224+65, 15'LT CB TA 4'0" T24 F&G RIM EL 740.65 INV 736.32	STA 226+65, 93'LT MH TA 4'0" T1F CL RIM EL 746.50 E&W INV 740.44	STA 229+50, 9'RT CB TA 4'0" T24 F&G RIM EL 745.48 INV 740.58	STA 229+65, 9'RT CB TA 4'0" T24 F&G RIM EL 745.52 INV 740.45	STA 230+25, 9'RT CB TA 4'0" T24 F&G RIM EL 745.75 INV 739.90	STA 231+65, 3' RT MH TA 5'0" T1F CL RIM EL 747.62 N&S INV 736.74 W INV 738.60 E INV 742.12	STA 232+75, 7'RT CB TA 4'0" T24 F&G RIM EL 748.24 INV 743.24

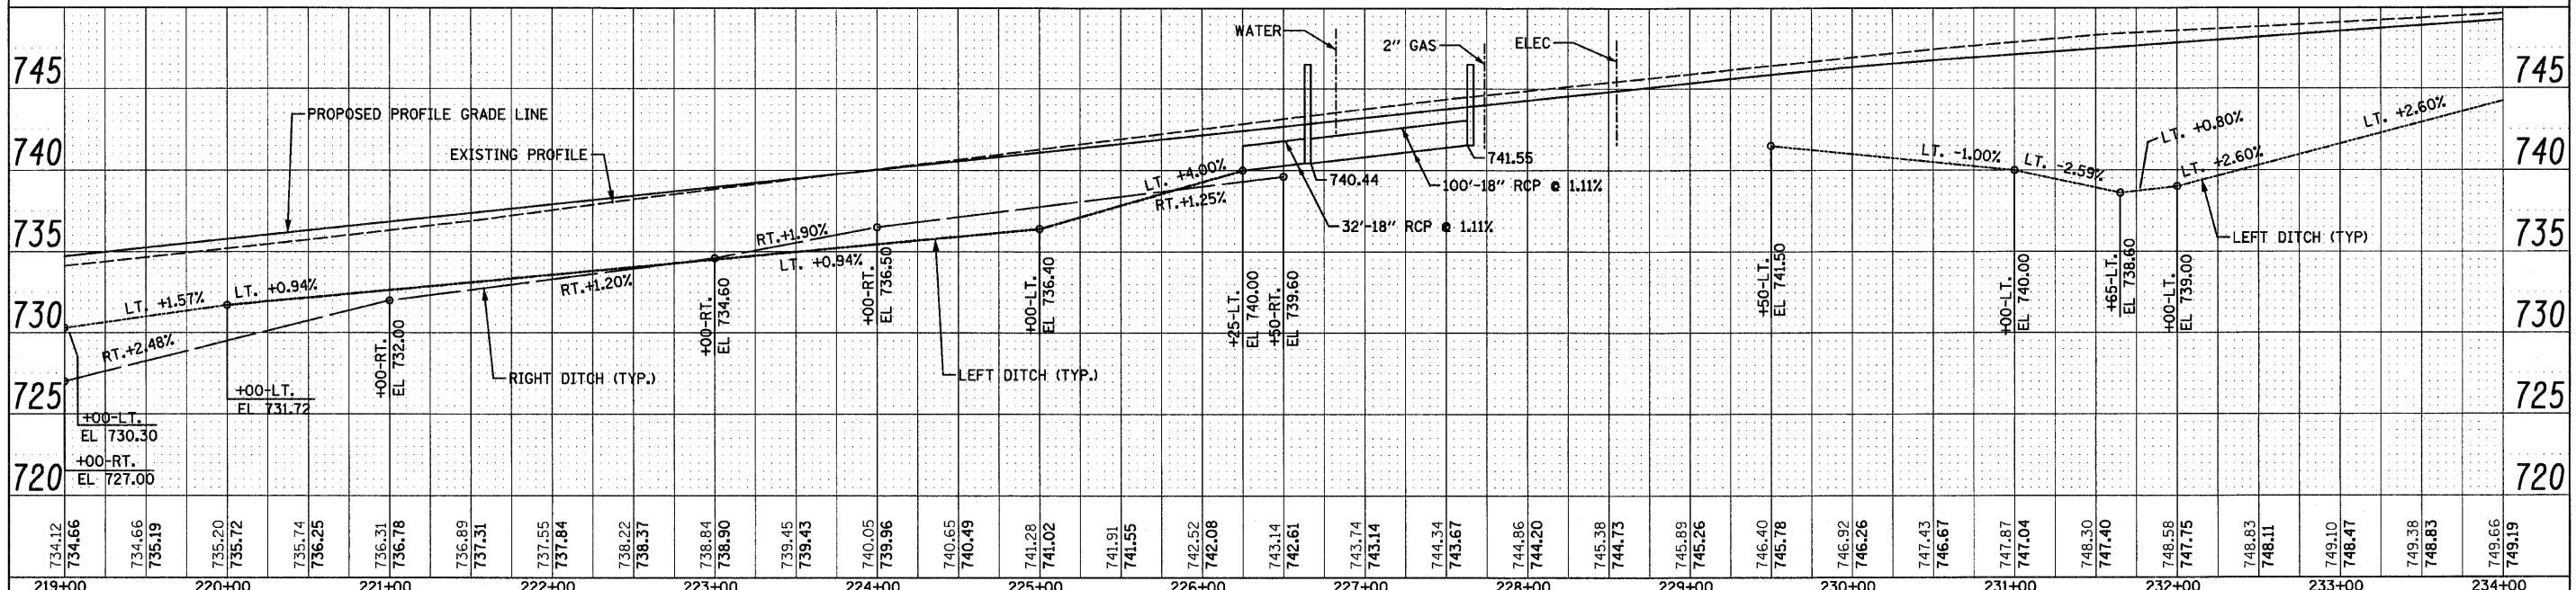

734.12	734.66	734.66	735.19	735.20	735.72	735.74	736.25	736.31	736.78	736.89	737.31	737.55	737.84	738.22	738.37	738.84	738.90	739.45	739.43	740.05	739.96	740.65	740.49	741.28	741.02	741.91	741.55	742.52	742.08	743.14	742.61	743.74	743.14	744.34	743.67	744.86	744.20	745.38	744.73	745.89	745.26	746.40	745.78	746.92	746.26	747.43	746.67	747.87	747.04	748.30	747.40	748.58	747.75	748.83	748.11	749.10	748.47	749.38	748.83	749.66	749.19
219+00	220+00	221+00	222+00	223+00	224+00	225+00	226+00	227+00	228+00	229+00	230+00	231+00	232+00	233+00	234+00																																														

FILE NAME = D162420-shd-drain10.dgn
 PLOT DATE = 12/2/2010
 PLOT SCALE = 50.000' / IN.

CHRISTIAN-ROGE & ASSOCIATES, INC.
 ENGINEERS-PLANNERS-SURVEYORS
 211 WEST WACKER DRIVE
 CHICAGO, ILLINOIS 60606
 PHONE: (312)372-2023 FAX: (312)372-5274

DESIGNED - S.J.P.	REVISED -
DRAWN - A.C.S.	REVISED -
CHECKED - M.P.	REVISED -
DATE - DECEMBER 3, 2010	REVISED -

STATE OF ILLINOIS
DEPARTMENT OF TRANSPORTATION

DRAINAGE PLAN AND PROFILE
IL. RTE. 56

SCALE: 1" = 50'
 SHEET NO. 10 OF 12 SHEETS
 STA. 219+00 TO STA. 234+00

F.A.P. RTE.	SECTION	COUNTY	TOTAL SHEETS	SHEET NO.
365	(58&59) WRS-3	DUPAGE	466	144
CONTRACT NO. 62420			ILLINOIS FED. AID PROJECT	