


172	173	174	175
STA 520+23, 44'RT CB TA 4'Ø T24 F&G RIM EL 720.35 INV 714.18	STA 520+23, 51'LT CB TA 4'Ø T24 F&G RIM EL 720.16 INV 715.16	STA 525+50, 33'LT CB TA 4'Ø T24 F&G RIM EL 720.78 E&N INV 716.03	STA 525+50, 33'RT CB TA 4'Ø T24 F&G RIM EL 720.78 INV 716.33

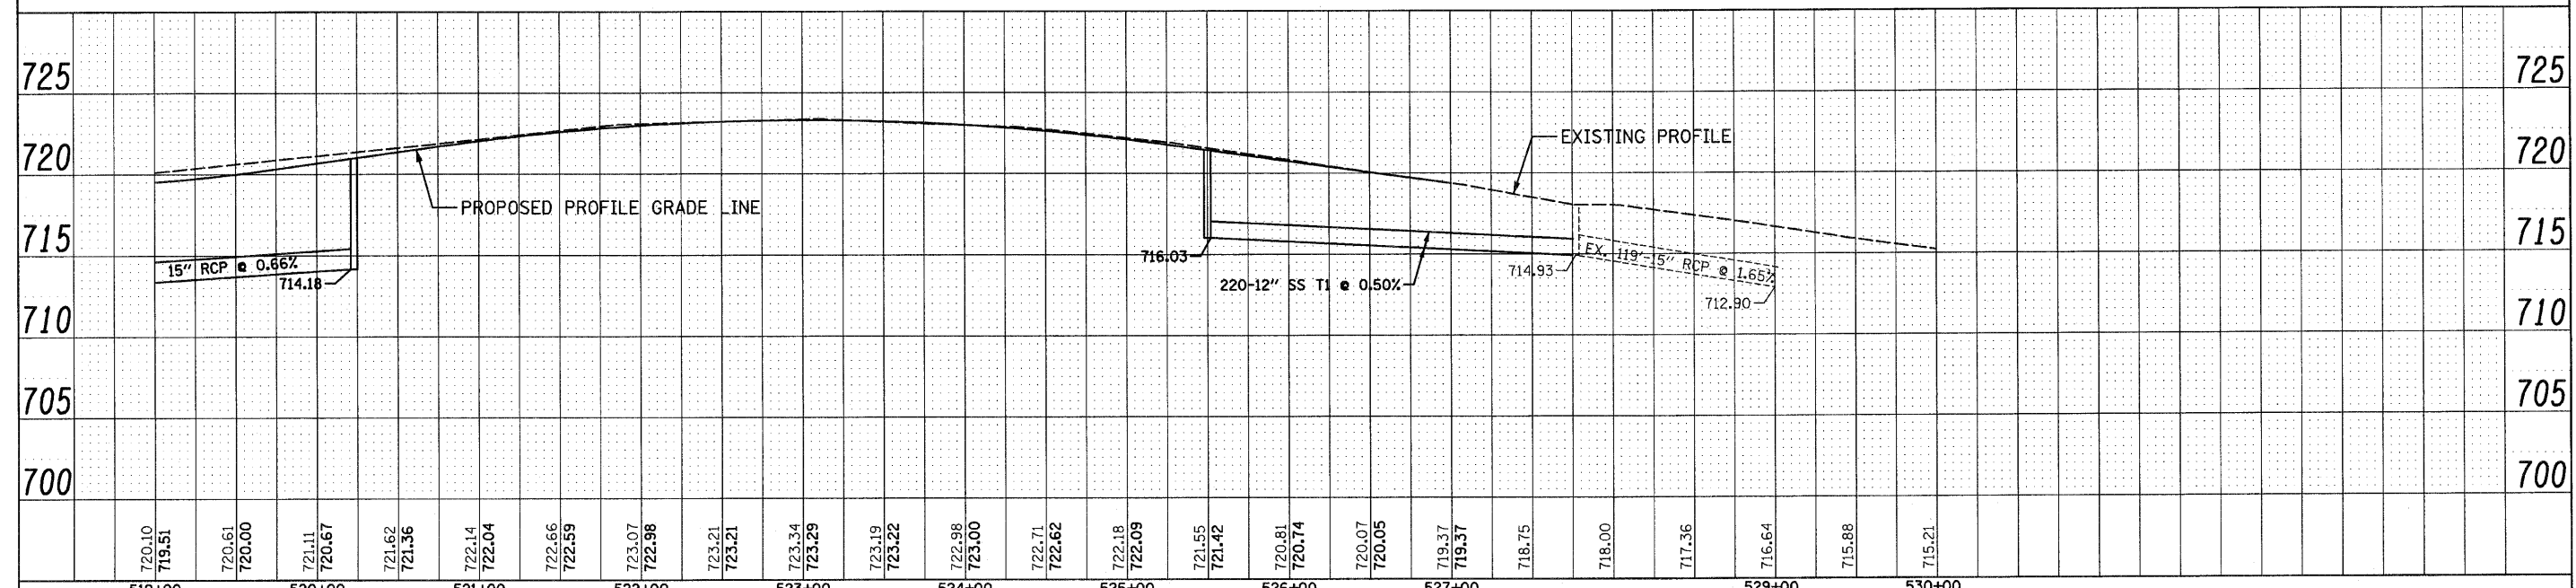

720.10 719.51	720.61 720.00	721.11 720.67	721.62 721.36	722.14 722.04	722.66 722.59	723.07 722.98	723.21 723.21	723.34 723.29	723.19 723.22	722.98 723.00	722.71 722.62	722.18 722.09	721.55 721.42	720.81 720.74	720.07 720.05	719.37 719.37	718.75	718.00	717.36	716.64	715.88	715.21
519+00	520+00	521+00	522+00	523+00	524+00	525+00	526+00	527+00	528+00	529+00	530+00											

FILE NAME = D:\62420-shd-drain\41159.dgn
 PLOT DATE = 12/2/2010
 PLOT SCALE = 50.000' / 1"

CHRISTIAN-ROGE & ASSOCIATES, INC.
 ENGINEERS-PLANNERS-SURVEYORS
 211 WEST WACKER DRIVE
 CHICAGO, ILLINOIS 60606
 PHONE: (312)372-2023 FAX: (312)372-5274

DESIGNED - S.J.P.	REVISED -
DRAWN - A.C.S.	REVISED -
CHECKED - M.P.	REVISED -
DATE - DECEMBER 3, 2010	REVISED -

STATE OF ILLINOIS
DEPARTMENT OF TRANSPORTATION

DRAINAGE PLAN AND PROFILE
IL. RTE. 59

SCALE: 1" = 50' SHEET NO. 2 OF 2 SHEETS STA. 519+00 TO STA. 527+00

F.A.P. RTE. 365	SECTION (58&59) WRS-3	COUNTY DuPAGE	TOTAL SHEETS 466	SHEET NO. 148
CONTRACT NO. 62420				
FED. ROAD DIST. NO. 1 ILLINOIS FED. AID PROJECT				