
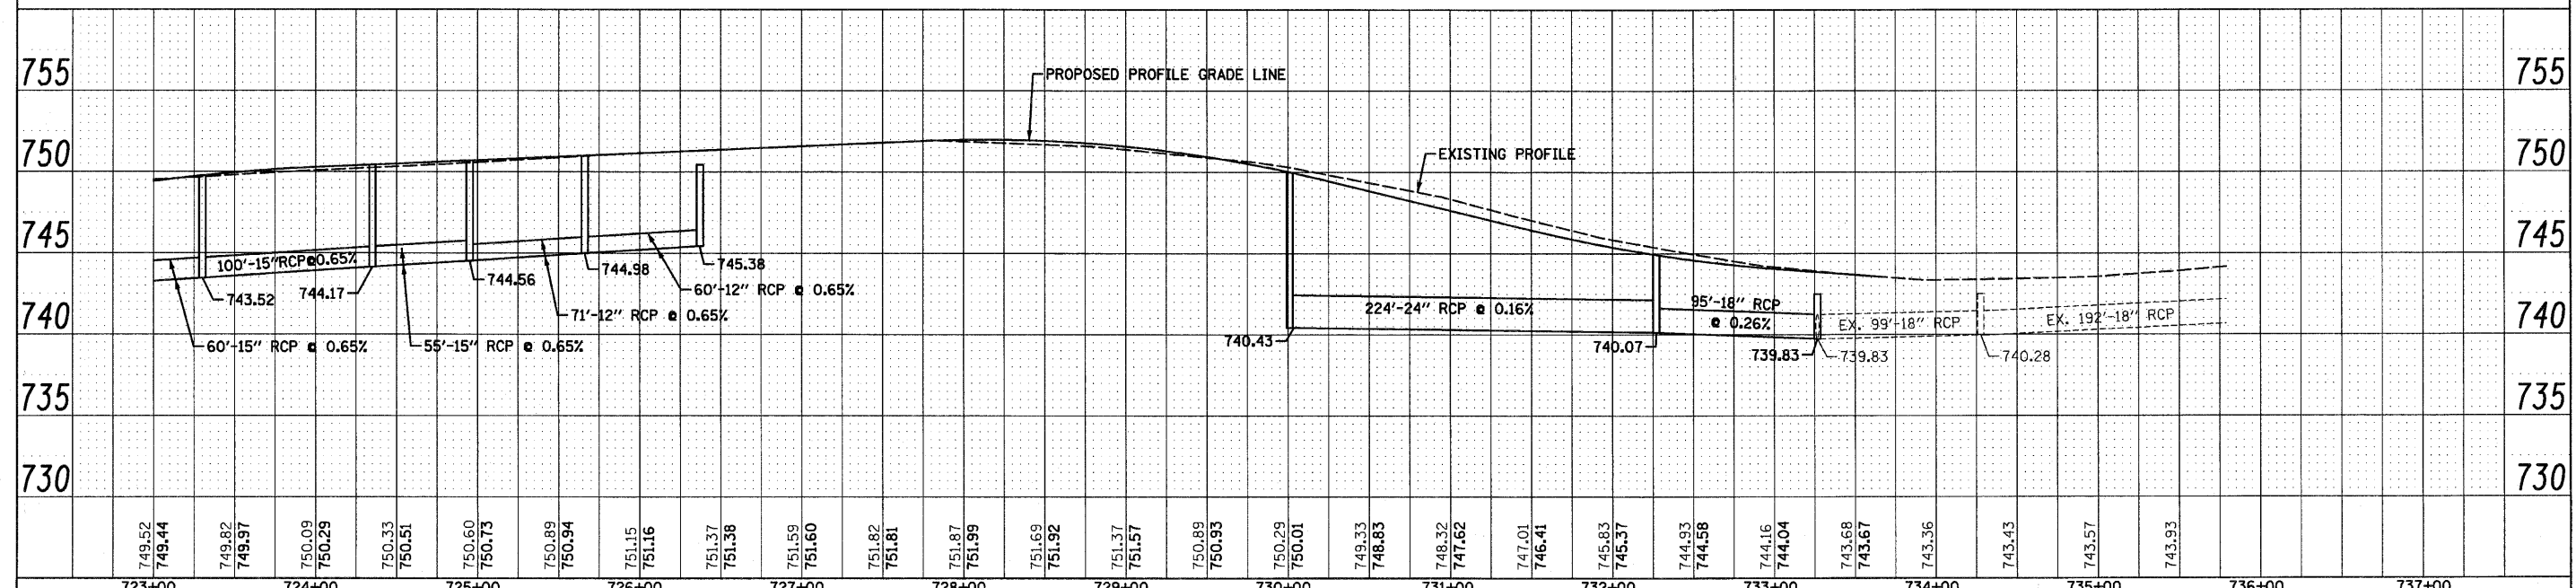


199 STA 723+29, 48'LT CB TA 4'Ø T23 F&G RIM EL 748.59 N&S INV 743.52	201 STA 724+94, 43'LT CB TA 4'Ø T23 F&G RIM EL 749.60 N&S INV 744.53	202 STA 725+70, 37'LT CB TA 4'Ø T23 F&G RIM EL 750.09 N&S INV 744.98	203 STA 726+36, 35'LT CB TA 4'Ø T23 F&G RIM EL 750.44 INV 745.38	205 STA 730+00, 35'LT MH TA 4'Ø T1F CL RIM EL 750.14 N INV 740.43 E INV 745.41	206 STA 732+26, 24'LT CB TA 4'Ø T23 F&G RIM EL 744.45 E&W INV 740.17	208 STA 732+26, 32'LT MH TA 4'Ø T1F CL RIM EL 745.03 N&S INV 740.07 E INV 740.07	209 STA 733+28, 38'LT MH TA 6'Ø T8G RIM EL 742.50 N&S INV 739.83 E&W INV 739.83 (VERIFY EXISTING INVERTS IN FIELD)
---	---	---	---	--	---	--	--

200
STA 724+35, 44.7'RT
CB TA 4'Ø T23 F&G
RIM EL 749.28
N&S INV 744.17

204
STA 730+00, 25.04'LT
CB TA 4'Ø T23 F&G
RIM EL 749.51
INV 745.51

207
STA 732+27, 25'RT
CB TA 4'Ø T23 F&G
RIM EL 744.43
INV 740.65

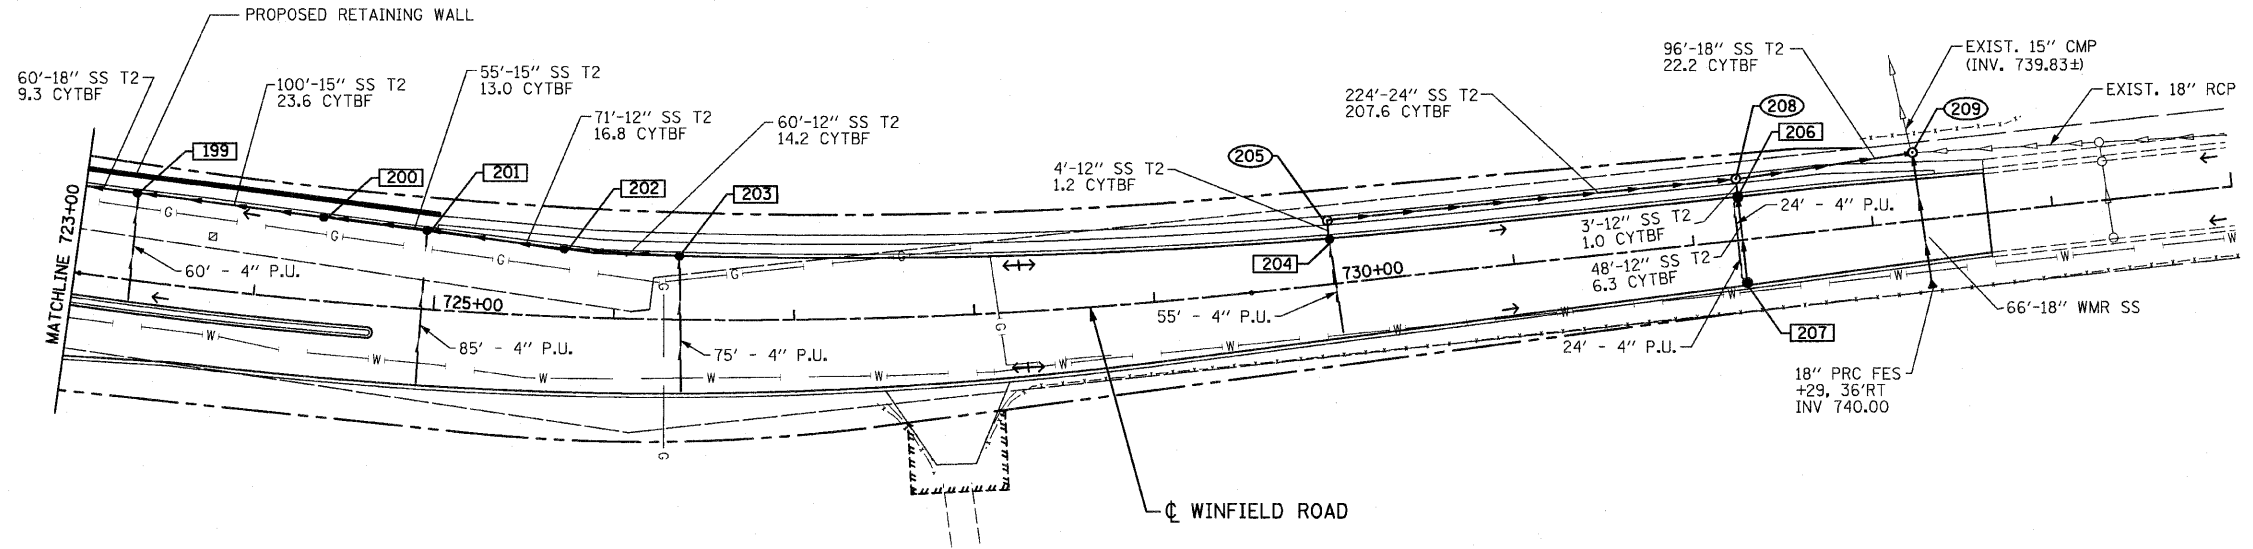

749.52 749.44	749.82 749.97	750.09 750.29	750.33 750.51	750.60 750.73	750.89 750.94	751.15 751.16	751.37 751.38	751.59 751.60	751.82 751.81	751.87 751.99	751.69 751.92	751.37 751.57	750.89 750.93	750.29 750.01	749.33 748.83	748.32 747.62	747.01 746.41	745.83 745.37	744.93 744.58	744.16 744.04	743.68 743.67	743.36	743.43	743.57	743.93	
723+00	724+00	725+00	726+00	727+00	728+00	729+00	730+00	731+00	732+00	733+00	734+00	735+00	736+00	737+00												

FILE NAME = D162420-shd-drain17win.dgn
PLOT DATE = 12/2/2010
PLOT SCALE = 50.000' / IN.

CHRISTIAN-ROGE & ASSOCIATES, INC.
ENGINEERS-PLANNERS-SURVEYORS
211 WEST WACKER DRIVE
CHICAGO, ILLINOIS 60606
PHONE: (312)372-2023 FAX: (312)372-5274

DESIGNED - S.J.P.	REVISED -
DRAWN - A.C.S.	REVISED -
CHECKED - M.P.	REVISED -
DATE - DECEMBER 3, 2010	REVISED -

STATE OF ILLINOIS
DEPARTMENT OF TRANSPORTATION

DRAINAGE PLAN AND PROFILE
WINFIELD ROAD

SCALE: 1" = 50'
SHEET NO. 2 OF 2 SHEETS
STA. 723+00 TO STA. 733+64

F.A.P. RTE. 365	SECTION (58&59) WRS-3	COUNTY DuPAGE	TOTAL SHEETS 466	SHEET NO. 151
FED. ROAD DIST. NO. 1 ILLINOIS FED. AID PROJECT			CONTRACT NO. 62420	