



CONTRACT NO. 62478				
F.A.P. RTE.	SECTION	COUNTY	TOTAL SHEETS	SHEET NO.
353	(12&13)WRS-4	WILL	608	200
STA. 989+00		TO STA. 998+00		
FED. ROAD DIST. NO. 1 ILLINOIS FED. AID PROJECT				



LEGEND

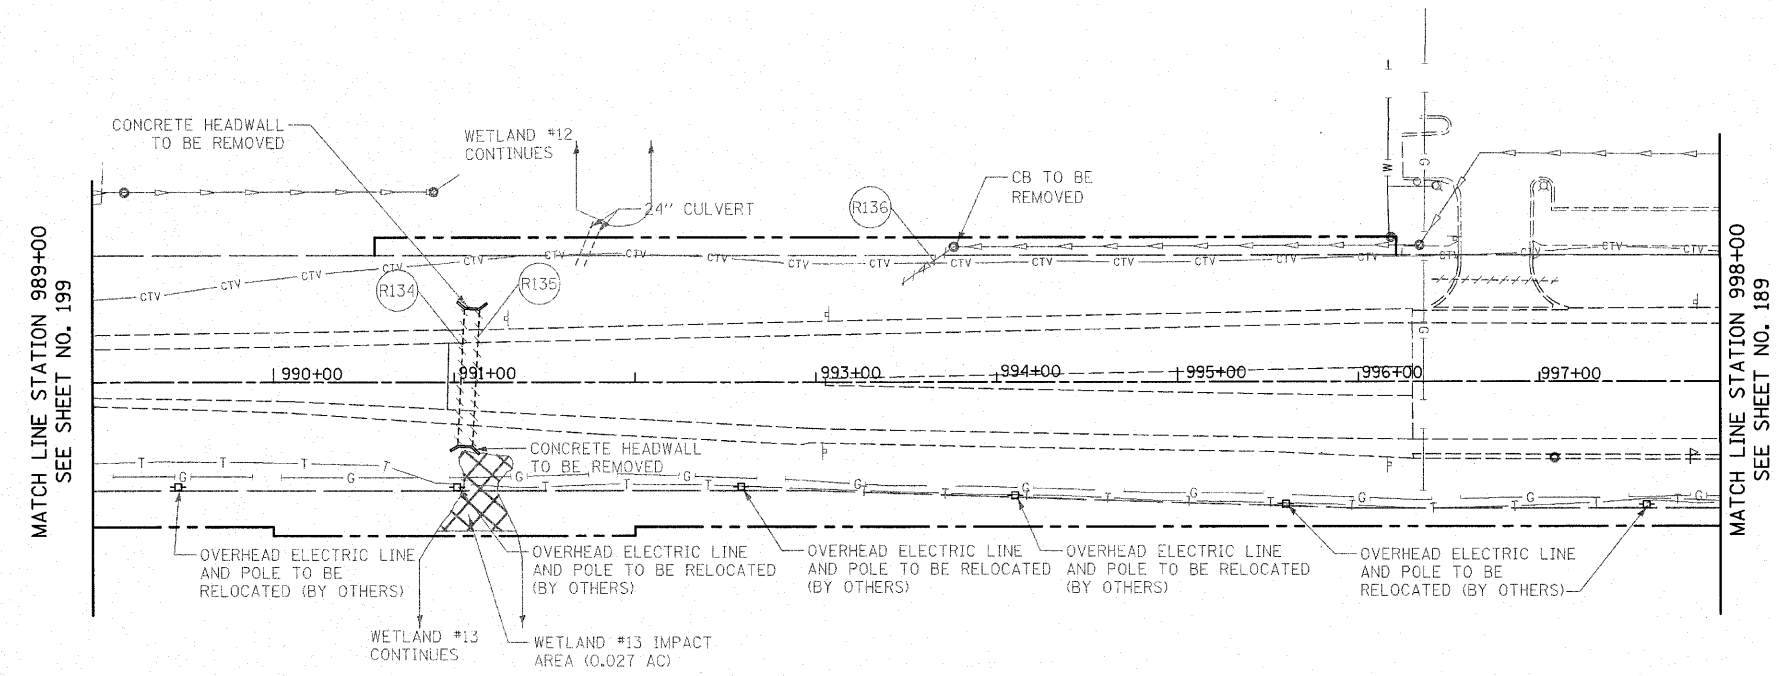

EXISTING HARLEM AVENUE

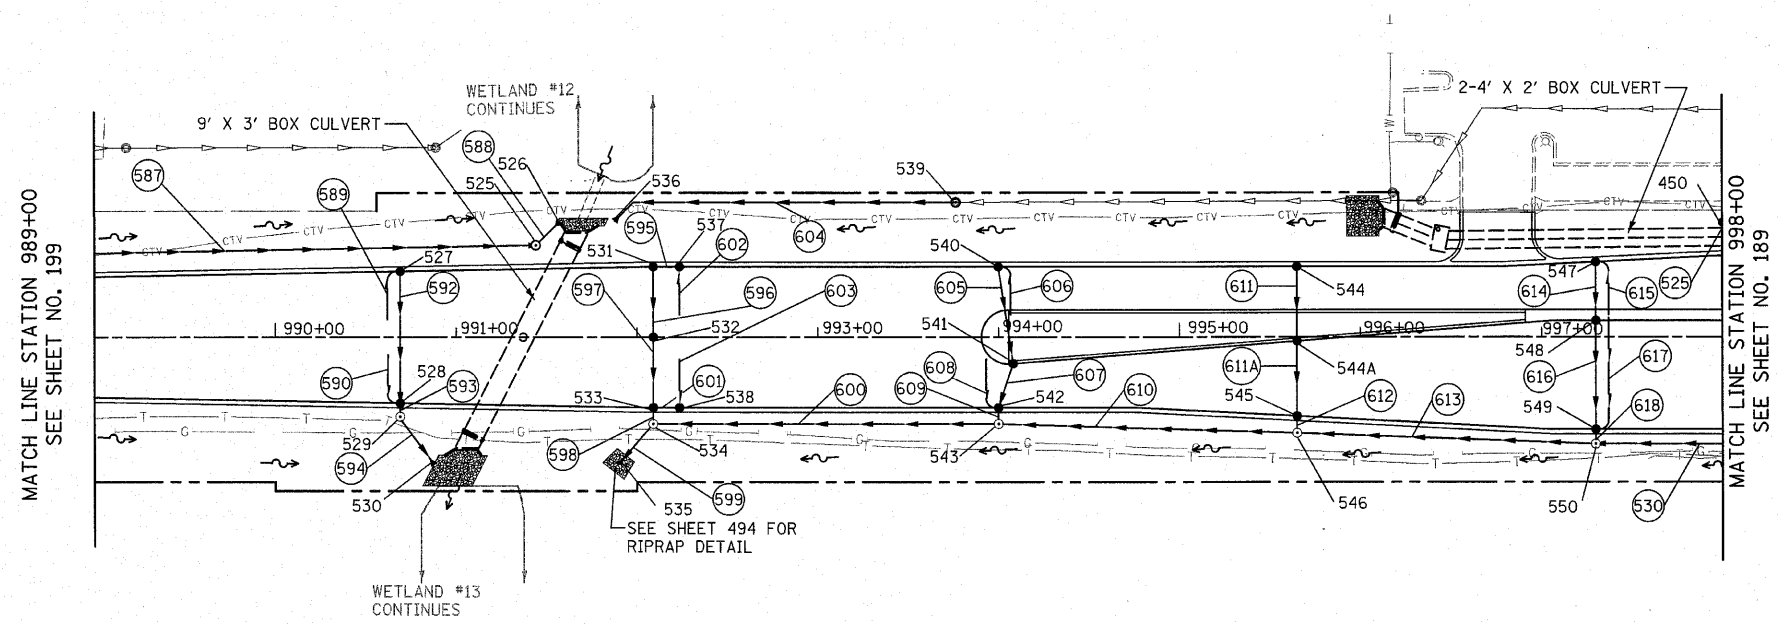

- NOTES:**
- SEE SHEET NO. 215 FOR CORRESPONDING PROFILE
 - SEE SHEETS NO. 476-492 FOR BOX CULVERT PLANS

REVISIONS	
NAME	DATE

ILLINOIS DEPARTMENT OF TRANSPORTATION

**HARLEM AVENUE
DRAINAGE AND UTILITY PLANS**

STATION 989+00 TO STATION 998+00

SCALE IN FEET

DATE 6/11/2010

DRAWN BY DJK
CHECKED BY JRJ