


| | |
|---------------|--|
| DATE | |
| BY | |
| PLAN | |
| NO. | |
| NO. OF SHEETS | |
| DATE | |
| BY | |
| NO. | |
| NO. OF SHEETS | |
| DATE | |
| BY | |
| NO. | |
| NO. OF SHEETS | |

| | |
|---------------|--|
| DATE | |
| BY | |
| PROFILE | |
| NO. | |
| NO. OF SHEETS | |
| DATE | |
| BY | |
| NO. | |
| NO. OF SHEETS | |

SEC GROUP, INC.
 PROJECT CONTACT: A. JAIN
 VILLAGE OF CARPENTERSVILLE
 425 N. Front Street
 Carpentersville, IL 61814
 618.366.1778
 618.366.1779
 618.366.1780
 618.366.1781
 618.366.1782
 618.366.1783
 618.366.1784
 618.366.1785
 618.366.1786
 618.366.1787
 618.366.1788
 618.366.1789
 618.366.1790
 618.366.1791
 618.366.1792
 618.366.1793
 618.366.1794
 618.366.1795
 618.366.1796
 618.366.1797
 618.366.1798
 618.366.1799
 618.366.1800

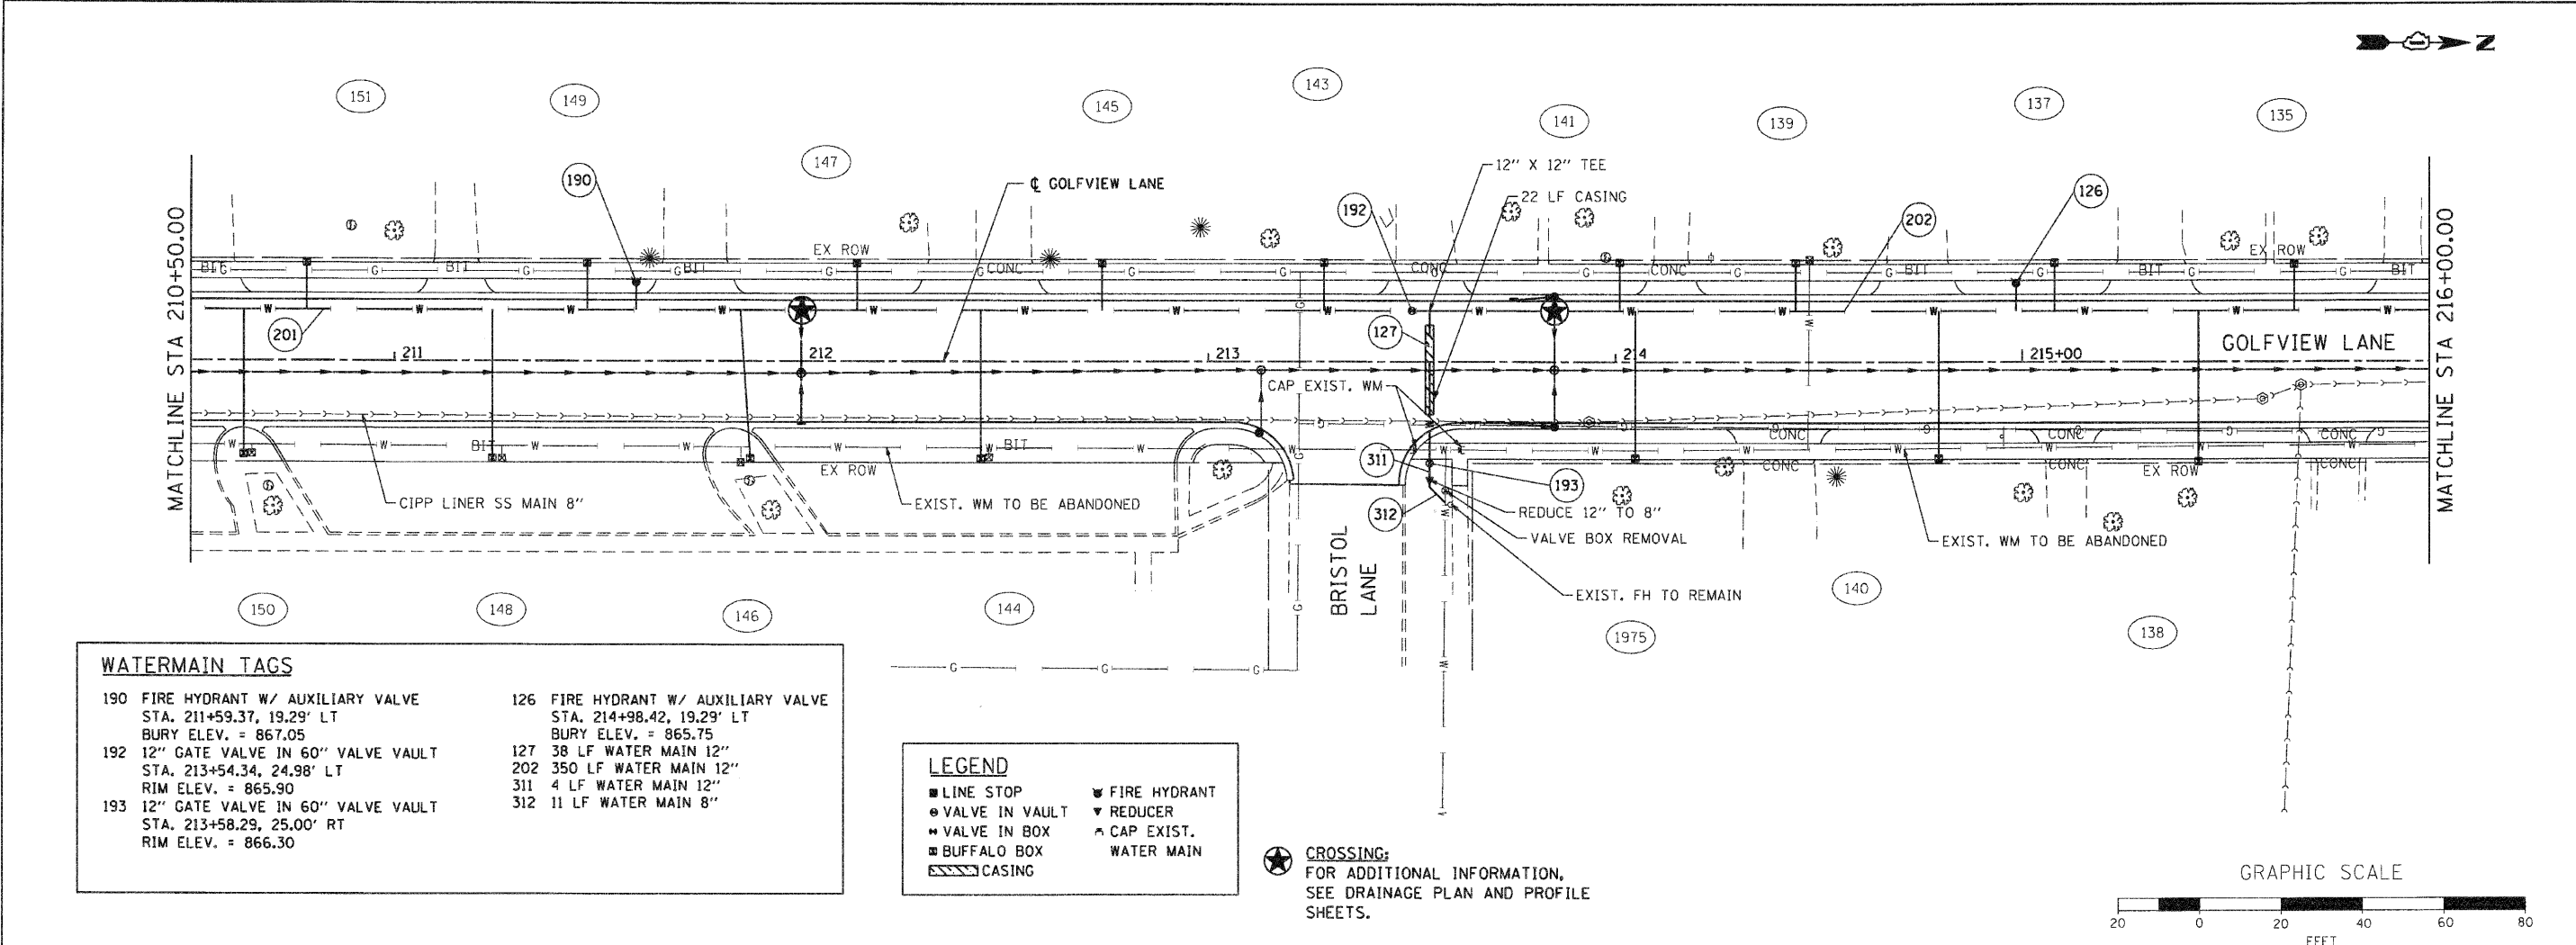



WATERMAIN TAGS

| | |
|--|---|
| 190 FIRE HYDRANT W/ AUXILIARY VALVE STA. 211+59.37, 19.29' LT BURY ELEV. = 867.05 | 126 FIRE HYDRANT W/ AUXILIARY VALVE STA. 214+98.42, 19.29' LT BURY ELEV. = 865.75 |
| 192 12" GATE VALVE IN 60" VALVE VAULT STA. 213+54.34, 24.98' LT RIM ELEV. = 865.90 | 127 38 LF WATER MAIN 12" |
| 193 12" GATE VALVE IN 60" VALVE VAULT STA. 213+58.29, 25.00' RT RIM ELEV. = 866.30 | 202 350 LF WATER MAIN 12" |
| | 311 4 LF WATER MAIN 12" |
| | 312 11 LF WATER MAIN 8" |

LEGEND

| | |
|------------------|----------------|
| ■ LINE STOP | ▼ FIRE HYDRANT |
| ● VALVE IN VAULT | ▼ REDUCER |
| ■ VALVE IN BOX | ▲ CAP EXIST. |
| ■ BUFFALO BOX | ▲ WATER MAIN |
| ▨ CASING | |

 CROSSING:
 FOR ADDITIONAL INFORMATION,
 SEE DRAINAGE PLAN AND PROFILE
 SHEETS.

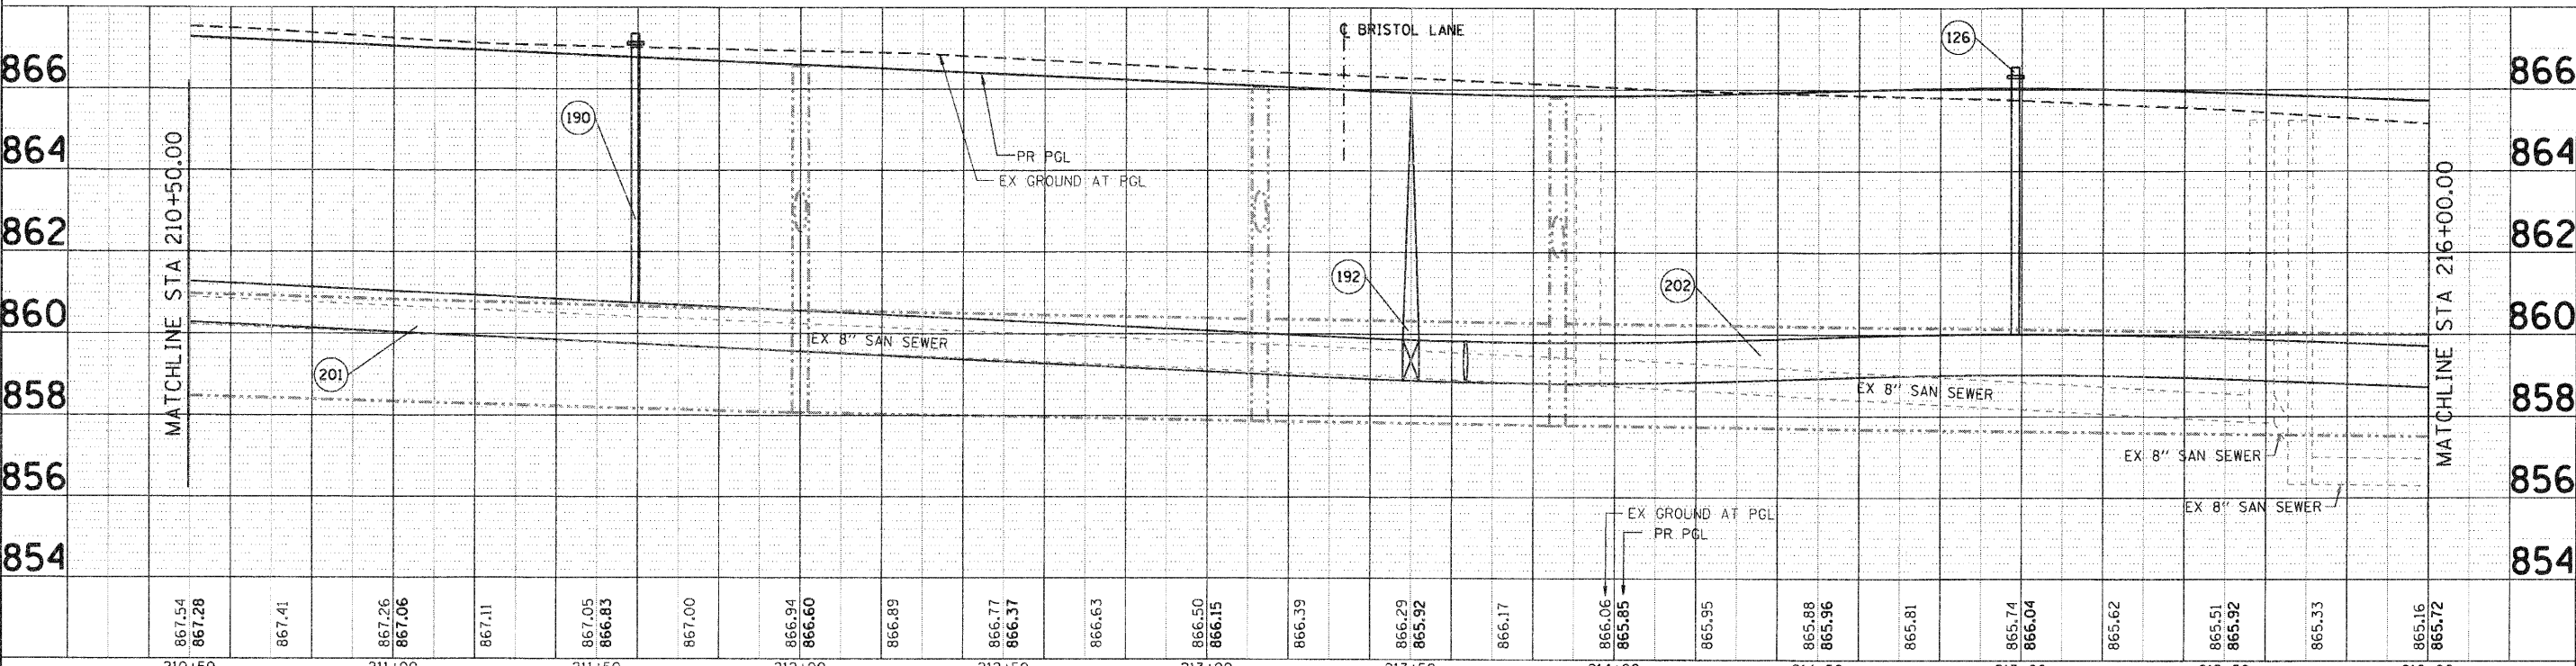

| | | | | | | | | | | | | | | | | | | | | | | |
|------------------|--------|------------------|--------|------------------|--------|------------------|--------|------------------|--------|------------------|--------|------------------|--------|------------------|--------|------------------|--------|------------------|--------|------------------|--------|------------------|
| 210+50 | 211+00 | 211+50 | 212+00 | 212+50 | 213+00 | 213+50 | 214+00 | 214+50 | 215+00 | 215+50 | 216+00 | | | | | | | | | | | |
| 867.54 867.28 | 867.41 | 867.26 867.06 | 867.11 | 867.05 866.83 | 867.00 | 866.94 866.60 | 866.89 | 866.77 866.37 | 866.63 | 866.50 866.15 | 866.39 | 866.29 865.92 | 866.17 | 866.06 865.85 | 865.95 | 865.88 865.96 | 865.81 | 865.74 866.04 | 865.62 | 865.51 865.92 | 865.33 | 865.16 865.72 |

SEC Group, Inc.
 An IIR Group Company
 425 N. Front Street
 Carpentersville, IL 61814
 618.366.1778
 618.366.1779
 618.366.1780
 618.366.1781
 618.366.1782
 618.366.1783
 618.366.1784
 618.366.1785
 618.366.1786
 618.366.1787
 618.366.1788
 618.366.1789
 618.366.1790
 618.366.1791
 618.366.1792
 618.366.1793
 618.366.1794
 618.366.1795
 618.366.1796
 618.366.1797
 618.366.1798
 618.366.1799
 618.366.1800

| | | | | | |
|-----------|---------------|----------|-------------|---------|---|
| USER NAME | - CHe-uke | DESIGNED | - C. PIEPER | REVISED | - |
| DRAWN | - R. BEST | REVISED | - | | |
| CHECKED | - T. HAMILTON | REVISED | - | | |
| DATE | - 10/25/10 | REVISED | - | | |

VILLAGE OF CARPENTERSVILLE

WATERMAIN AND SANITARY SEWER PLAN AND PROFILE
GOLFVIEW LANE

| | | | | |
|---|----------------|--------|--------------------|-----------|
| F.A. RTE. | SECTION | COUNTY | TOTAL SHEETS | SHEET NO. |
| | 06-00074-00-FP | KANE | 211 | 77 |
| * FAU 2414, FAU 1280, FAP 343 | | | CONTRACT NO. 63504 | |
| FED. ROAD DIST. NO. [ILLINOIS] FED. AID PROJECT | | | | |

SCALE: 1" = 20' SHEET NO. 8 OF 20 SHEETS STA. 210+50 TO STA. 216+00